

 


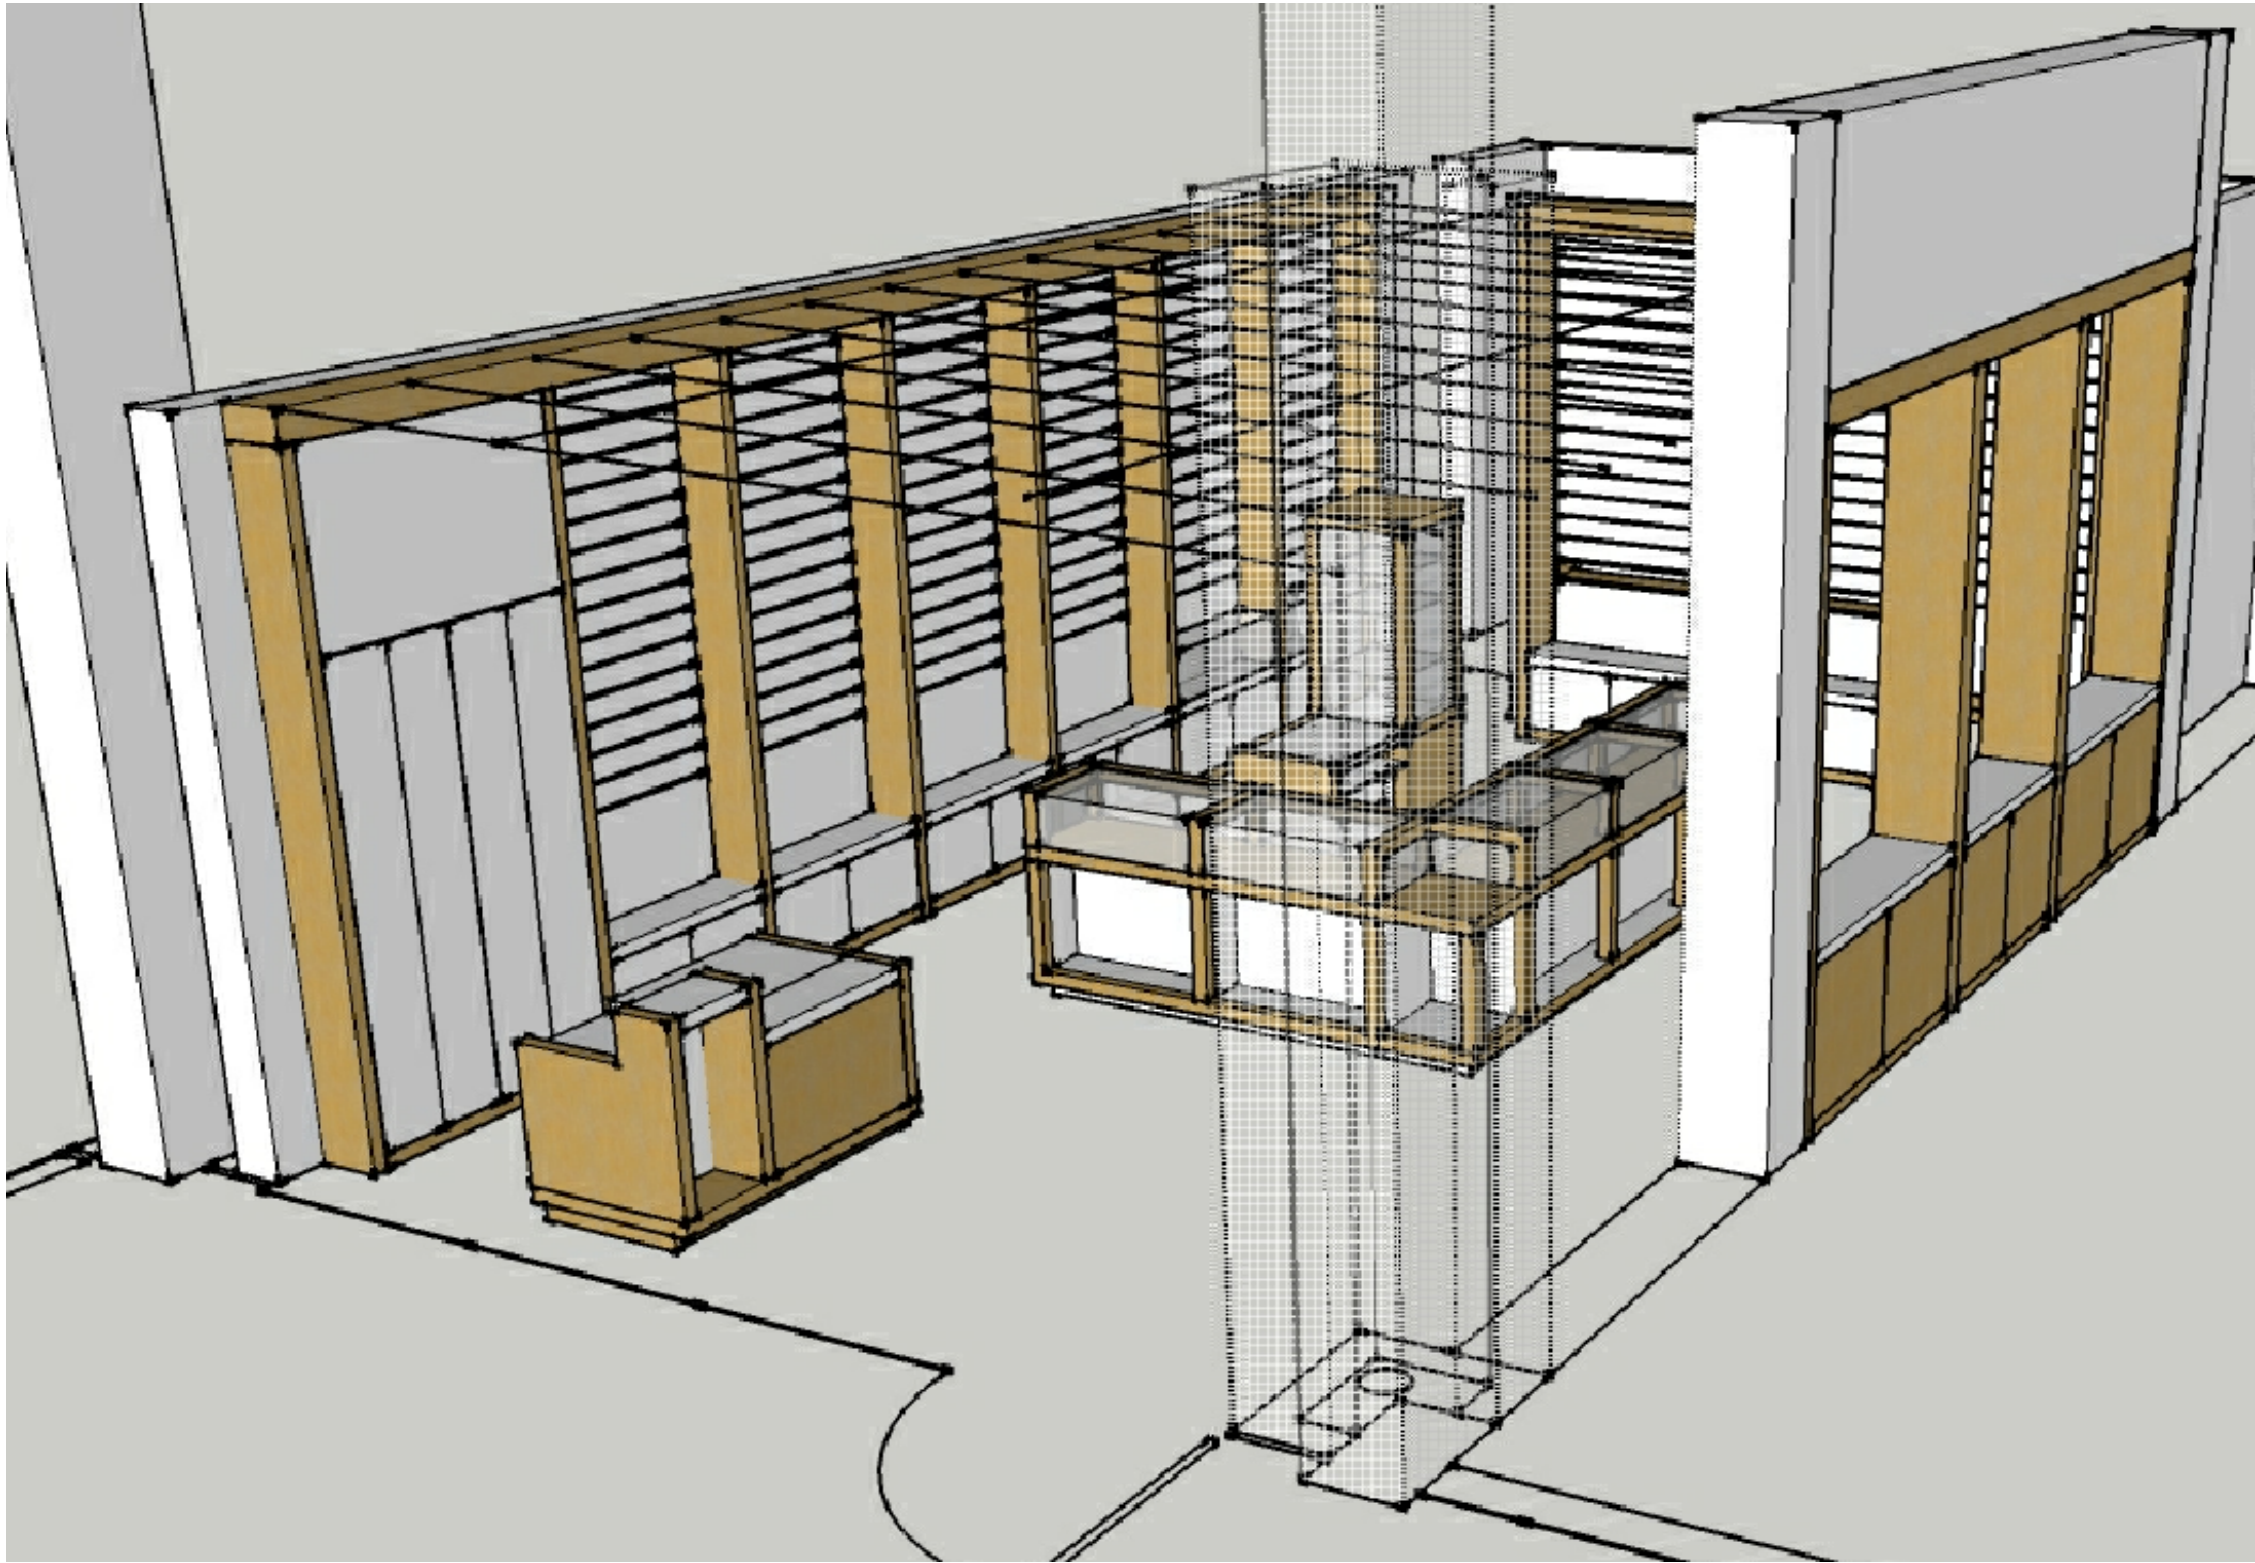

② PERSPECTIVE - OVERALL CONCEPT
N.T.S.

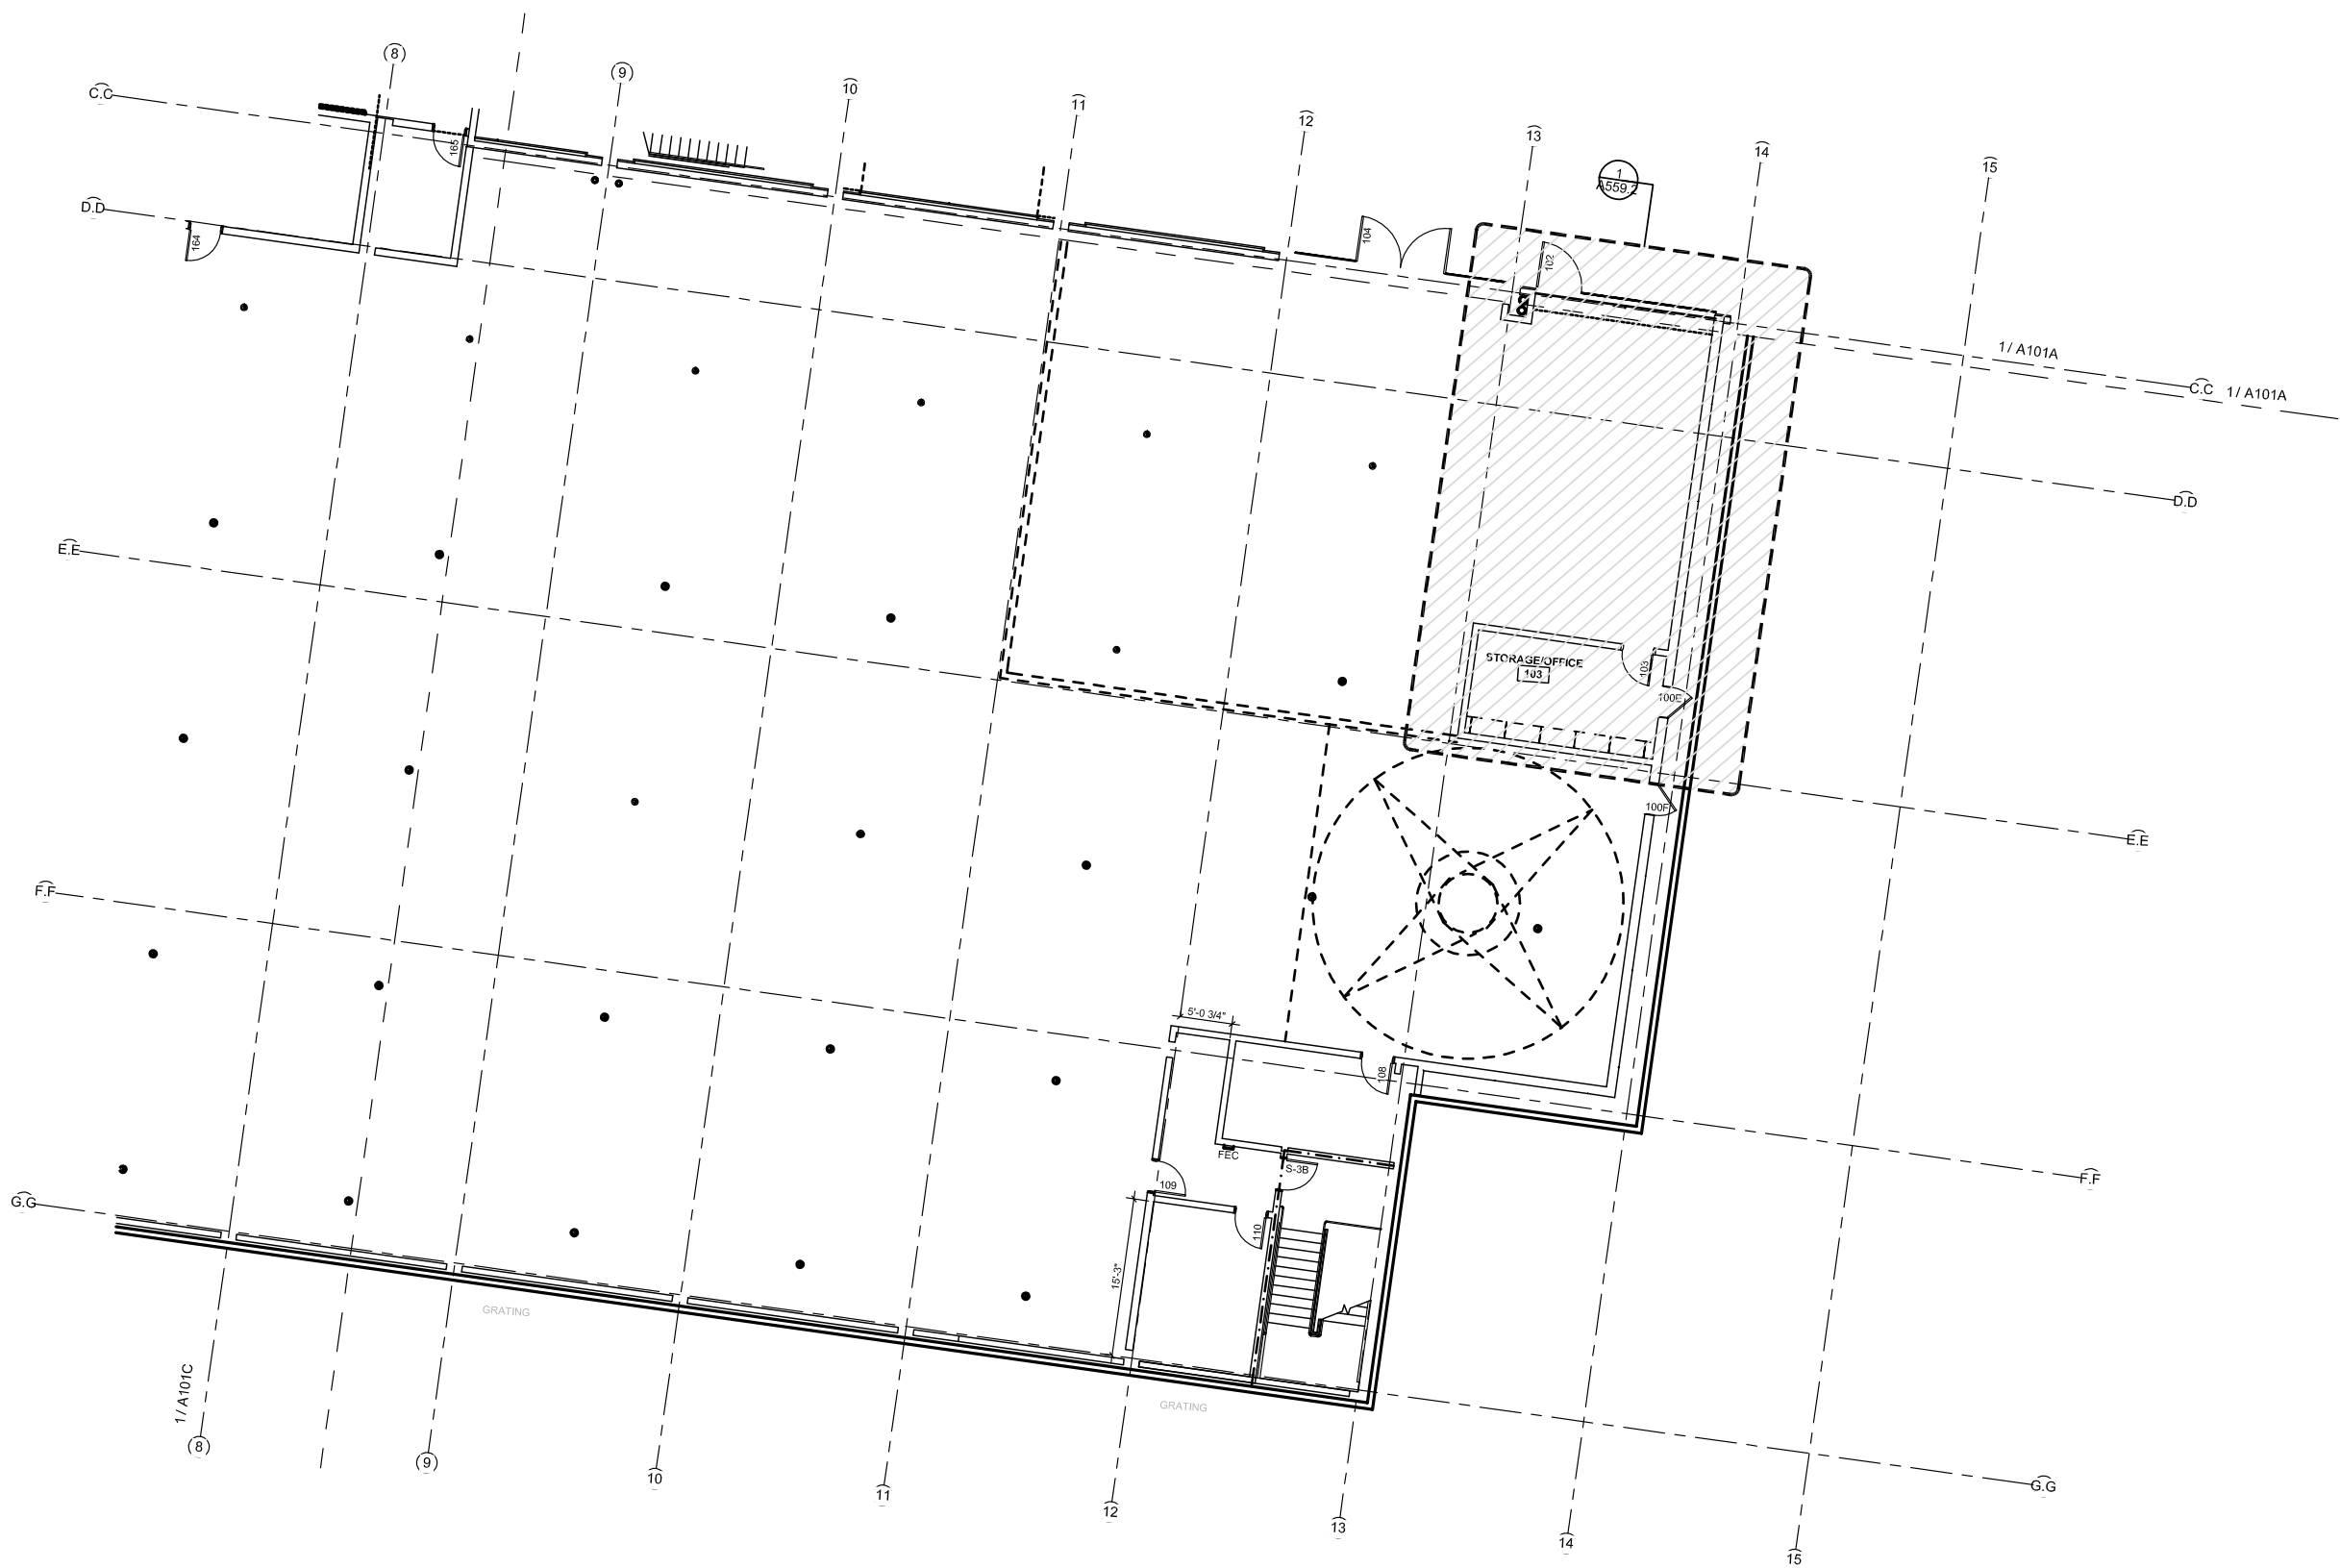


① FIRST FLOOR PLAN - SE - KEY
1/16" = 1'-0"



ROOM FINISH SCHEDULE

NO	NAME	FLOOR			BASE			WALL 1			WALL 2			WALL 3			WALL 4			CEILING				REMARKS
		MAT	FIN	COL	MAT	FIN	COL	MAT	FIN	COL	MAT	FIN	COL	MAT	FIN	COL	MAT	FIN	COL	MAT	FIN	COL	HT	
102	GIFT SHOP	CONC	CPT1	-	WDB	-	-	GLS/GWB	P1	-	GWB	MPI 52	P1	GWB	MPI 52	P1	GLS/GWB	MPI 52	P1	ACT2	-	-	12'-0	PLAM SOLID CORE WHITE
-	-	-	-	-	-	-	-	-	-	-	-	-	-	-	-	-	-	-	-	-	-	-	-	-
-	-	-	-	-	-	-	-	-	-	-	-	-	-	-	-	-	-	-	-	-	-	-	-	-

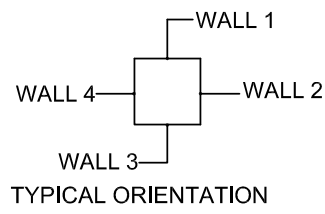

FINISH LEGEND


** REFERENCE SHEET A660 FOR FINISH LEGEND

③ DOOR SCHEDULE

MARK	LEVEL	OVERALL WIDTH	OVERALL HEIGHT	DOOR				FRAME			REMARKS
				TYPE	MTL	FIN	GLAZING	TYPE	MTL	FIN	
102B	TOC FLR 1	7'-5 1/2"	10'-0"	D8	GLS	N/A	TYPE GL-6	BY MFR	ALUMN.	FAC	ACTIVE LEAF: 3'-6" / SEE DETAILS
-	-	- - -	- - -	-	-	-	-	-	-	-	-
-	-	- - -	- - -	-	-	-	-	-	-	-	-


GENERAL NOTES:

- VERIFY ALL EXISTING & NEW OPENINGS. NOTIFY ARCHITECT OF ANY DISCREPANCIES BETWEEN ACTUAL CONDITIONS & INFORMATION WITH THESE DOCUMENTS.
- DIMENSIONS ARE TO EDGE OF FRAME AND GIVEN FOR INFORMATION ONLY. REFER TO DETAILS FOR DIMENSION & RELATIONSHIP(S) TO ADJACENT FINISHES.
- REFER TO SHEET A559.5 & A559.6 FOR DETAILS
- INTERIOR GLAZING TYPE TO BE GL-6 UNLESS OTHERWISE NOTED

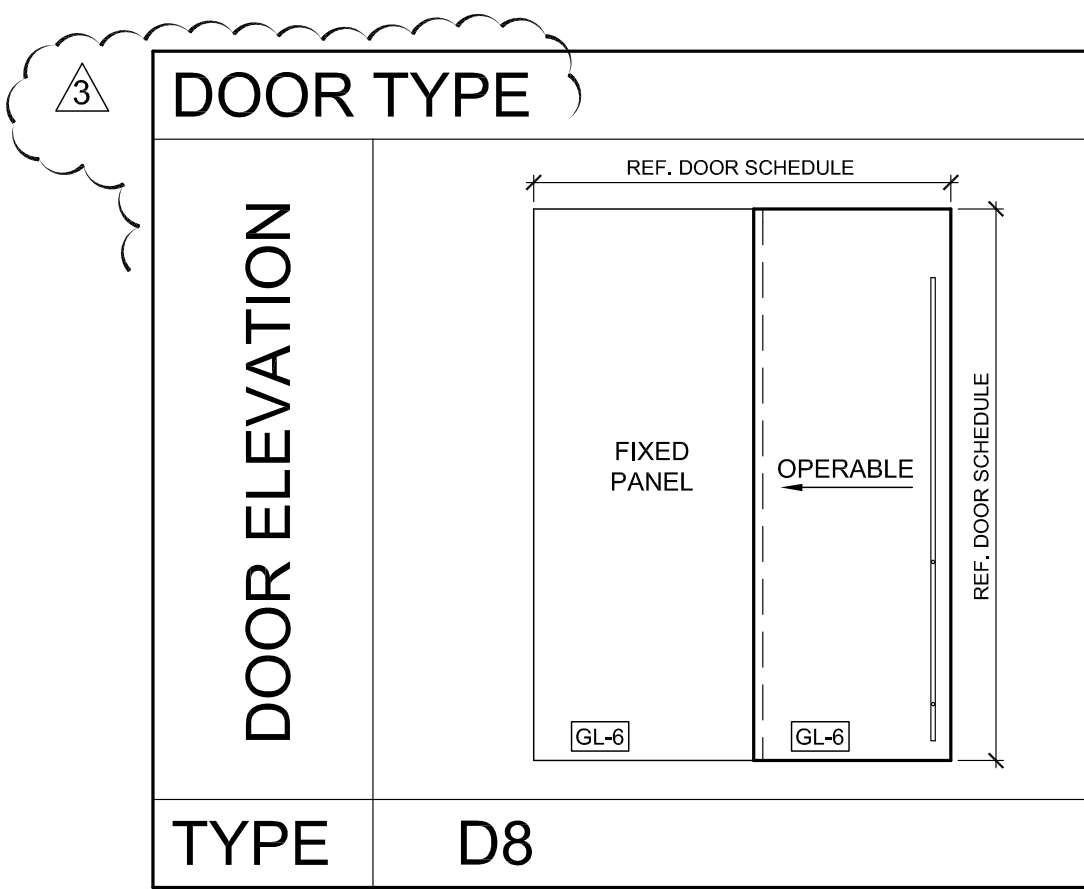

REVISIONS:

- 06.22.12 SUPPLEMENTAL INFO
- 07.03.12 SUPPLEMENTAL INFO

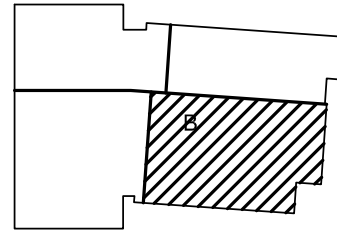

KEYPLAN - (NTS)


CONSTRUCTION DOCUMENTS

06.22.2012


KEY PLAN/
SCHEDULE

A559.1

RFI #0715

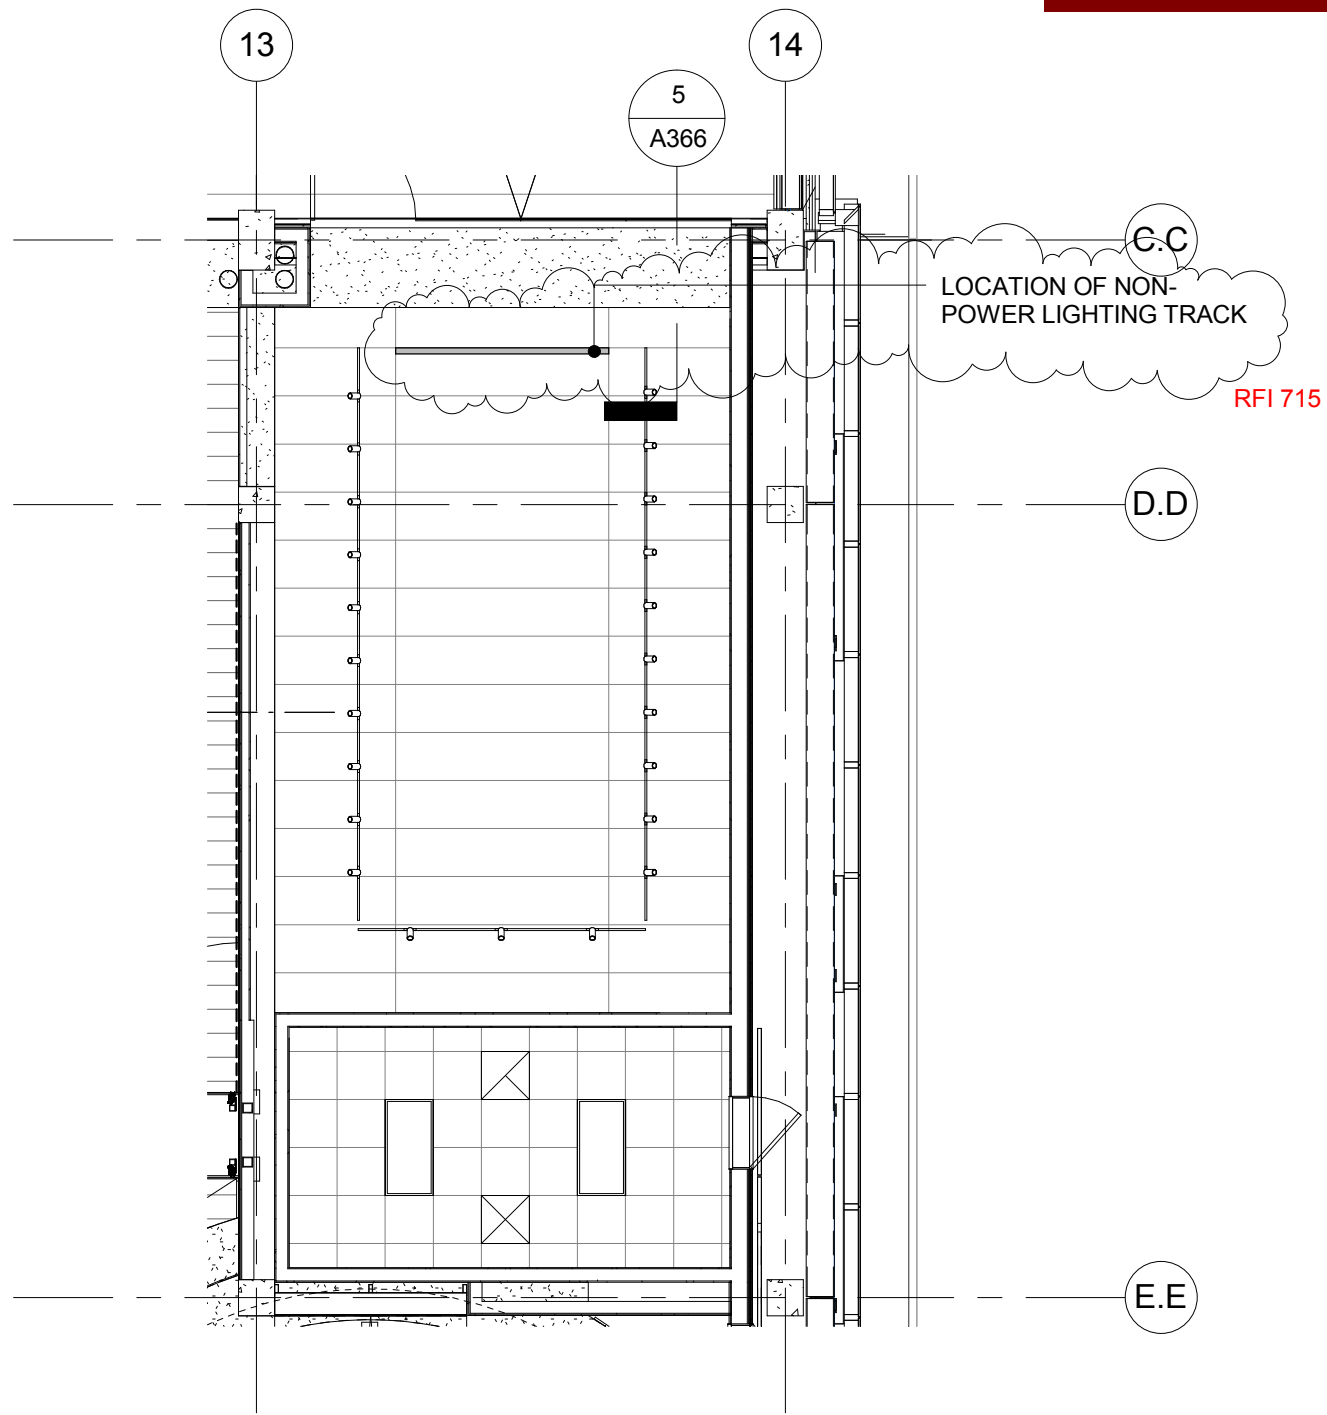

① ENLARGED RCP - GIFT SHOP
1/8" = 1'-0"

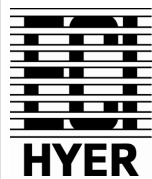


101 West Benson Blvd., Ste. 306
Anchorage, AK 99503
907.561.5543 p
907.562.3213 f
www.sclhyer.com

OWNER
STATE OF ALASKA:
LIBRARY ARCHIVES
MUSEUM

CEILING TRACK @ GIFT SHOP	
Project number	10-0005
Date	01/15/15
Drawn by	DPP
Checked by	Scale 1/8" = 1'-0"

RFI #0715

12/17/14 - PROVIDE CHANGE TO IB
PER RFI, LIGHTING TRACK WITH
PRODUCT DATA AND DETAILS.

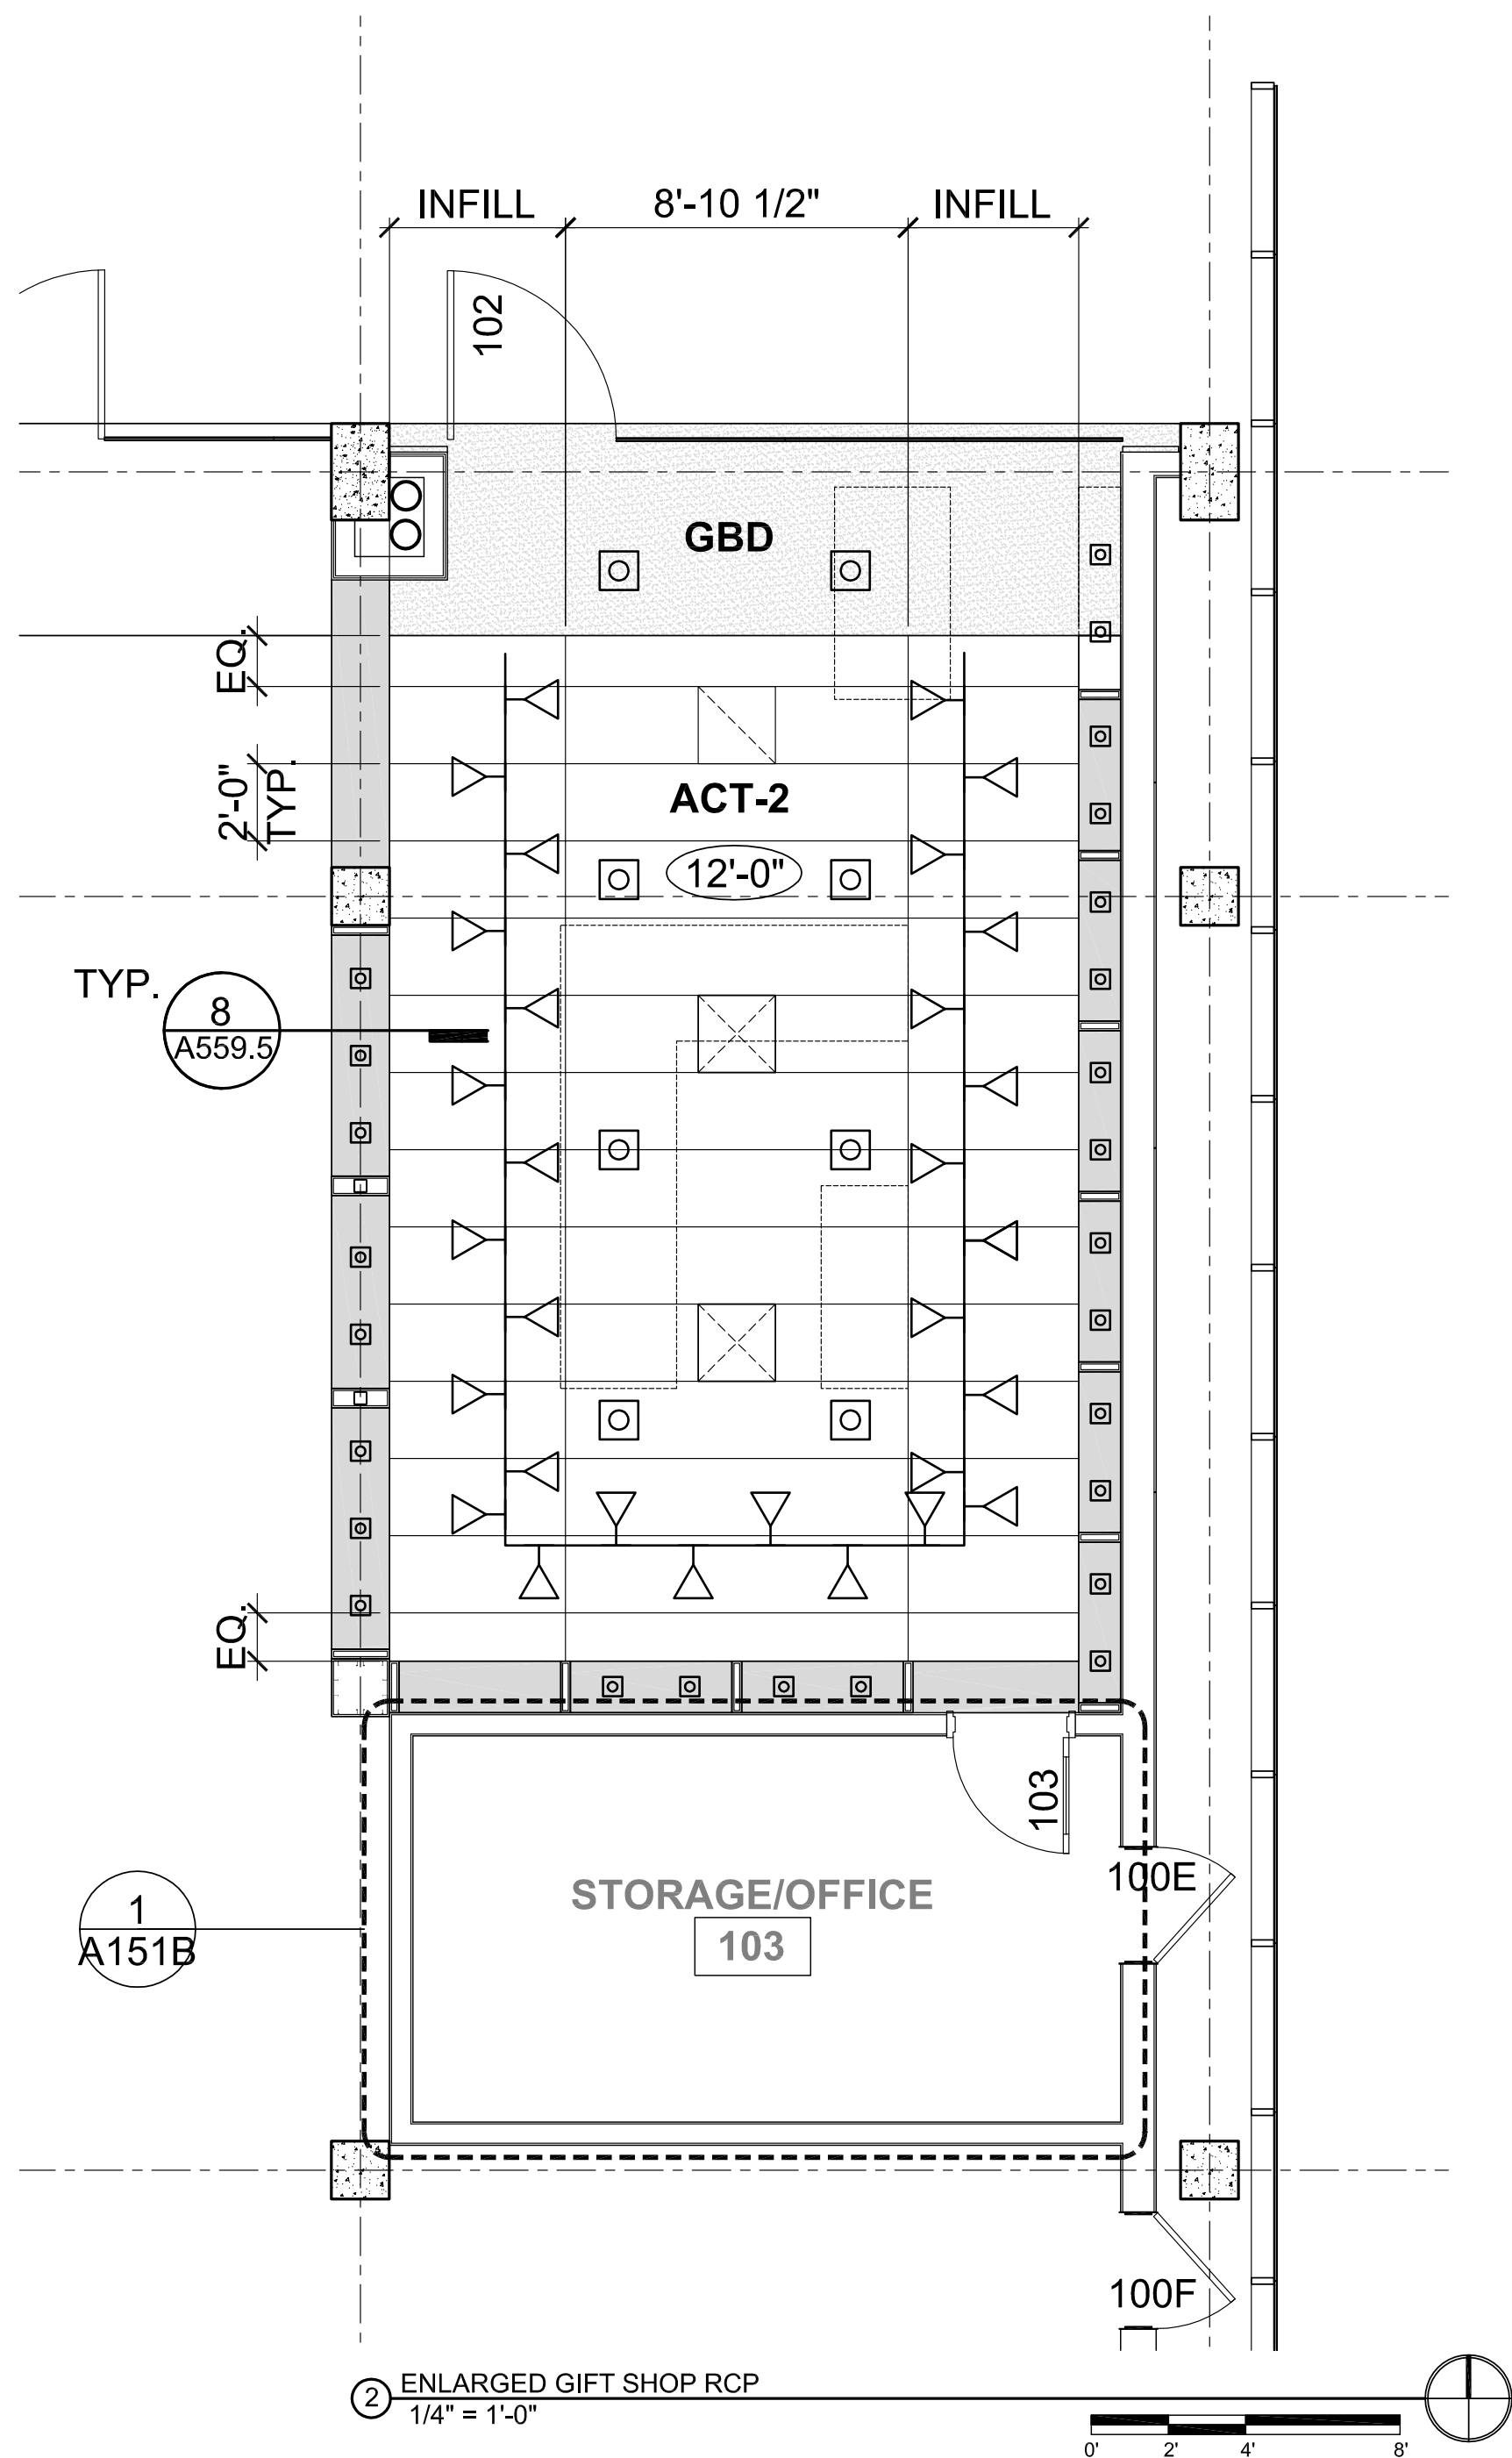

GENERAL NOTES - REFLECTED CEILING PLAN

- A. ALL CEILING HEIGHTS ARE FROM FINISH FLOOR ELEVATION UNLESS OTHERWISE NOTED.
- B. REF G-100 SERIES DRAWINGS FOR CODE SUMMARIES AND EXTENT OF FIRE-RATED CONSTRUCTION.
- C. REF A015 FOR TYPICAL CEILING FRAMING
- D. SEE MECHANICAL DRAWINGS FOR LOCATIONS OF DIFFUSERS, GRILLES, EXPOSED DUCTWORK AND OTHER MECHANICAL ITEMS IN CEILING.
- E. DETAIL CUTS INDICATE TYPICAL CONDITIONS UNLESS OTHERWISE NOTED.
- F. REF ELECTRICAL PLANS FOR LIGHTING FIXTURE TYPES.

LIGHT FIXTURE TO BE CENTERED IN ROOM OR CEILING BAY UNLESS OTHERWISE NOTED.

PROVIDE CEILING FRAMING CAPABLE OF SUPPORTING ALL TRIM WORK AND LIGHTING INDICATED.

STRUCTURAL SUPPORT OF GYPSUM FRAMED CEILING STRUCTURE FROM NON-COMPOSITE METAL DECK IS NOT ALLOWED.

COORDINATE ALL CEILING FRAMING AND SEISMIC RESTRAINT MEMBERS WITH ALL MECHANICAL PLUMBING, ELECTRICAL LIGHTING, FIRESPRINKLER PIPING, AND OTHER EQUIPMENT. (PRIOR TO INSTALLATION, CONTRACTOR IS REQUIRED TO PROVIDE A COORDINATION CEILING DRAWING SHOWING ALL SUBCONTRACTOR WORK IN AND ABOVE CEILING AREAS. THIS WORK TO SHOW ALL MECHANICAL SYSTEMS (HVAC EQUIPMENT, DUCTWORK, PLUMBING, PIPING, CONTROLS, FIRE PROTECTION SYSTEMS); ELECTRICAL SYSTEMS (LIGHTS, CONTROLS, FIRE AND LIFE SAFETY LIGHTING); STRUCTURAL LIMITATIONS; AND INTEGRATED CEILING HANGERS AND SUPPORT.)

L. VERIFY ALL SPRINKLER HEAD LOCATIONS WITH FIRE PROTECTION DRAWINGS.

M. FIRE SPRINKLER HEADS AND OTHER DEVICES ARE SHOWN FOR ARCHITECTURAL INTENT ONLY IN SELECTED ROOMS. DEVICES NOT SHOWN SHOULD NOT BE INTERPRETED THAT THEY ARE NOT REQUIRED. IT IS THE RESPONSIBILITY OF THE CONTRACTOR TO SATISFY THE REQUIREMENTS OF THE LOCAL JURISDICTION FOR QUANTITY AND LOCATION OF ALL DEVICES THROUGHOUT THE PROJECT. OBTAIN APPROVAL OF THE LAYOUT FROM THE ARCHITECT PRIOR TO INSTALLATION OF ALL SYSTEMS AND DEVICES.


N. EXPOSED STRUCTURE SERVES AS THE FINISHED CEILING SURFACE IN MANY AREAS. WHEN SERVICES (MECHANICAL, ELECTRICAL, ETC.) ARE EXPOSED CAREFUL COORDINATION IS REQUIRED TO ENSURE THAT LAYOUT IS COMPATIBLE WITH ARCHITECTURAL LAYOUT. THESE PLANS SHOW THE GENERAL INTENT FOR THE FINAL APPEARANCE OF THE LAYOUTS. ADDITIONAL ELEMENTS MAY BE REQUIRED FOR A FULLY FUNCTIONAL SYSTEM AND THESE SHOULD BE INCLUDED USING SIMILAR STRATEGIES FOR LAYOUT AS INDICATED IN THESE PLANS.

MATERIAL

- ACT 2: (2'-9" X 8'-6" MAX)
- GYPSUM BOARD (PAINTED)


GENERAL NOTES - PLAN

- A. REFERENCE CIVIL DRAWINGS FOR GRADING AND HORIZONTAL CONTROL DRAWINGS.
- B. REF LANDSCAPE DRAWINGS FOR ALL SITE MATERIALS, LAYOUT, AND ACCESS COMPLIANCE SITE/PATH OF TRAVEL DRAWINGS.
- C. REFERENCE A-000 SERIES FOR ABBREVIATIONS, SYMBOLS AND GENERAL DIMENSIONING NOTES.
- D. REF A-010 SERIES DRAWINGS FOR ALL WALL TYPE DETAILS AND FIRE-RATED ASSEMBLIES. IF WALL TYPE IS NOT NOTED IN THE PLAN THEN THE WALL TYPE SHALL BE 3.6 @ FLOOR 1 CONDITIONS & 3.3 @ FLOOR 2 CONDITIONS
- E. REF A-017 & A-018 DRAWINGS FOR TYPICAL METAL STUD FRAMING DETAILS AND GUIDELINES.
- F. REF G-100 SERIES DRAWINGS FOR CODE SUMMARIES AND EXTENT OF FIRE-RATED CONSTRUCTION.
- G. REF A-640 DRAWINGS FOR EXTERIOR FRAME TYPES.
- H. REF A-620 SERIES DRAWINGS FOR INTERIOR FRAME TYPES.
- J. REF STRUCTURAL DRAWINGS FOR DIMENSIONS AND ELEVATIONS OF STRUCTURAL SLAB AND WALL ELEMENTS.
- K. OFOI ELEMENTS INCLUDE ALL FURNITURE, WORKSTATIONS, LIBRARY EQUIPMENT AND CARTS, RETAIL FIXTURES & EQUIPMENT (INDICATED AS DASHED)
- L. CONTRACTOR TO PROVIDE: BUILT IN CASEWORK, LOCKERS, LIBRARY FIXED SHELVING, STORAGE SHELVING, MOBILE & FIXED SECURE SHELVING, LAB EQUIPMENT, INSTALLATION OF OWNER PROVIDED SHOP EQUIPMENT.

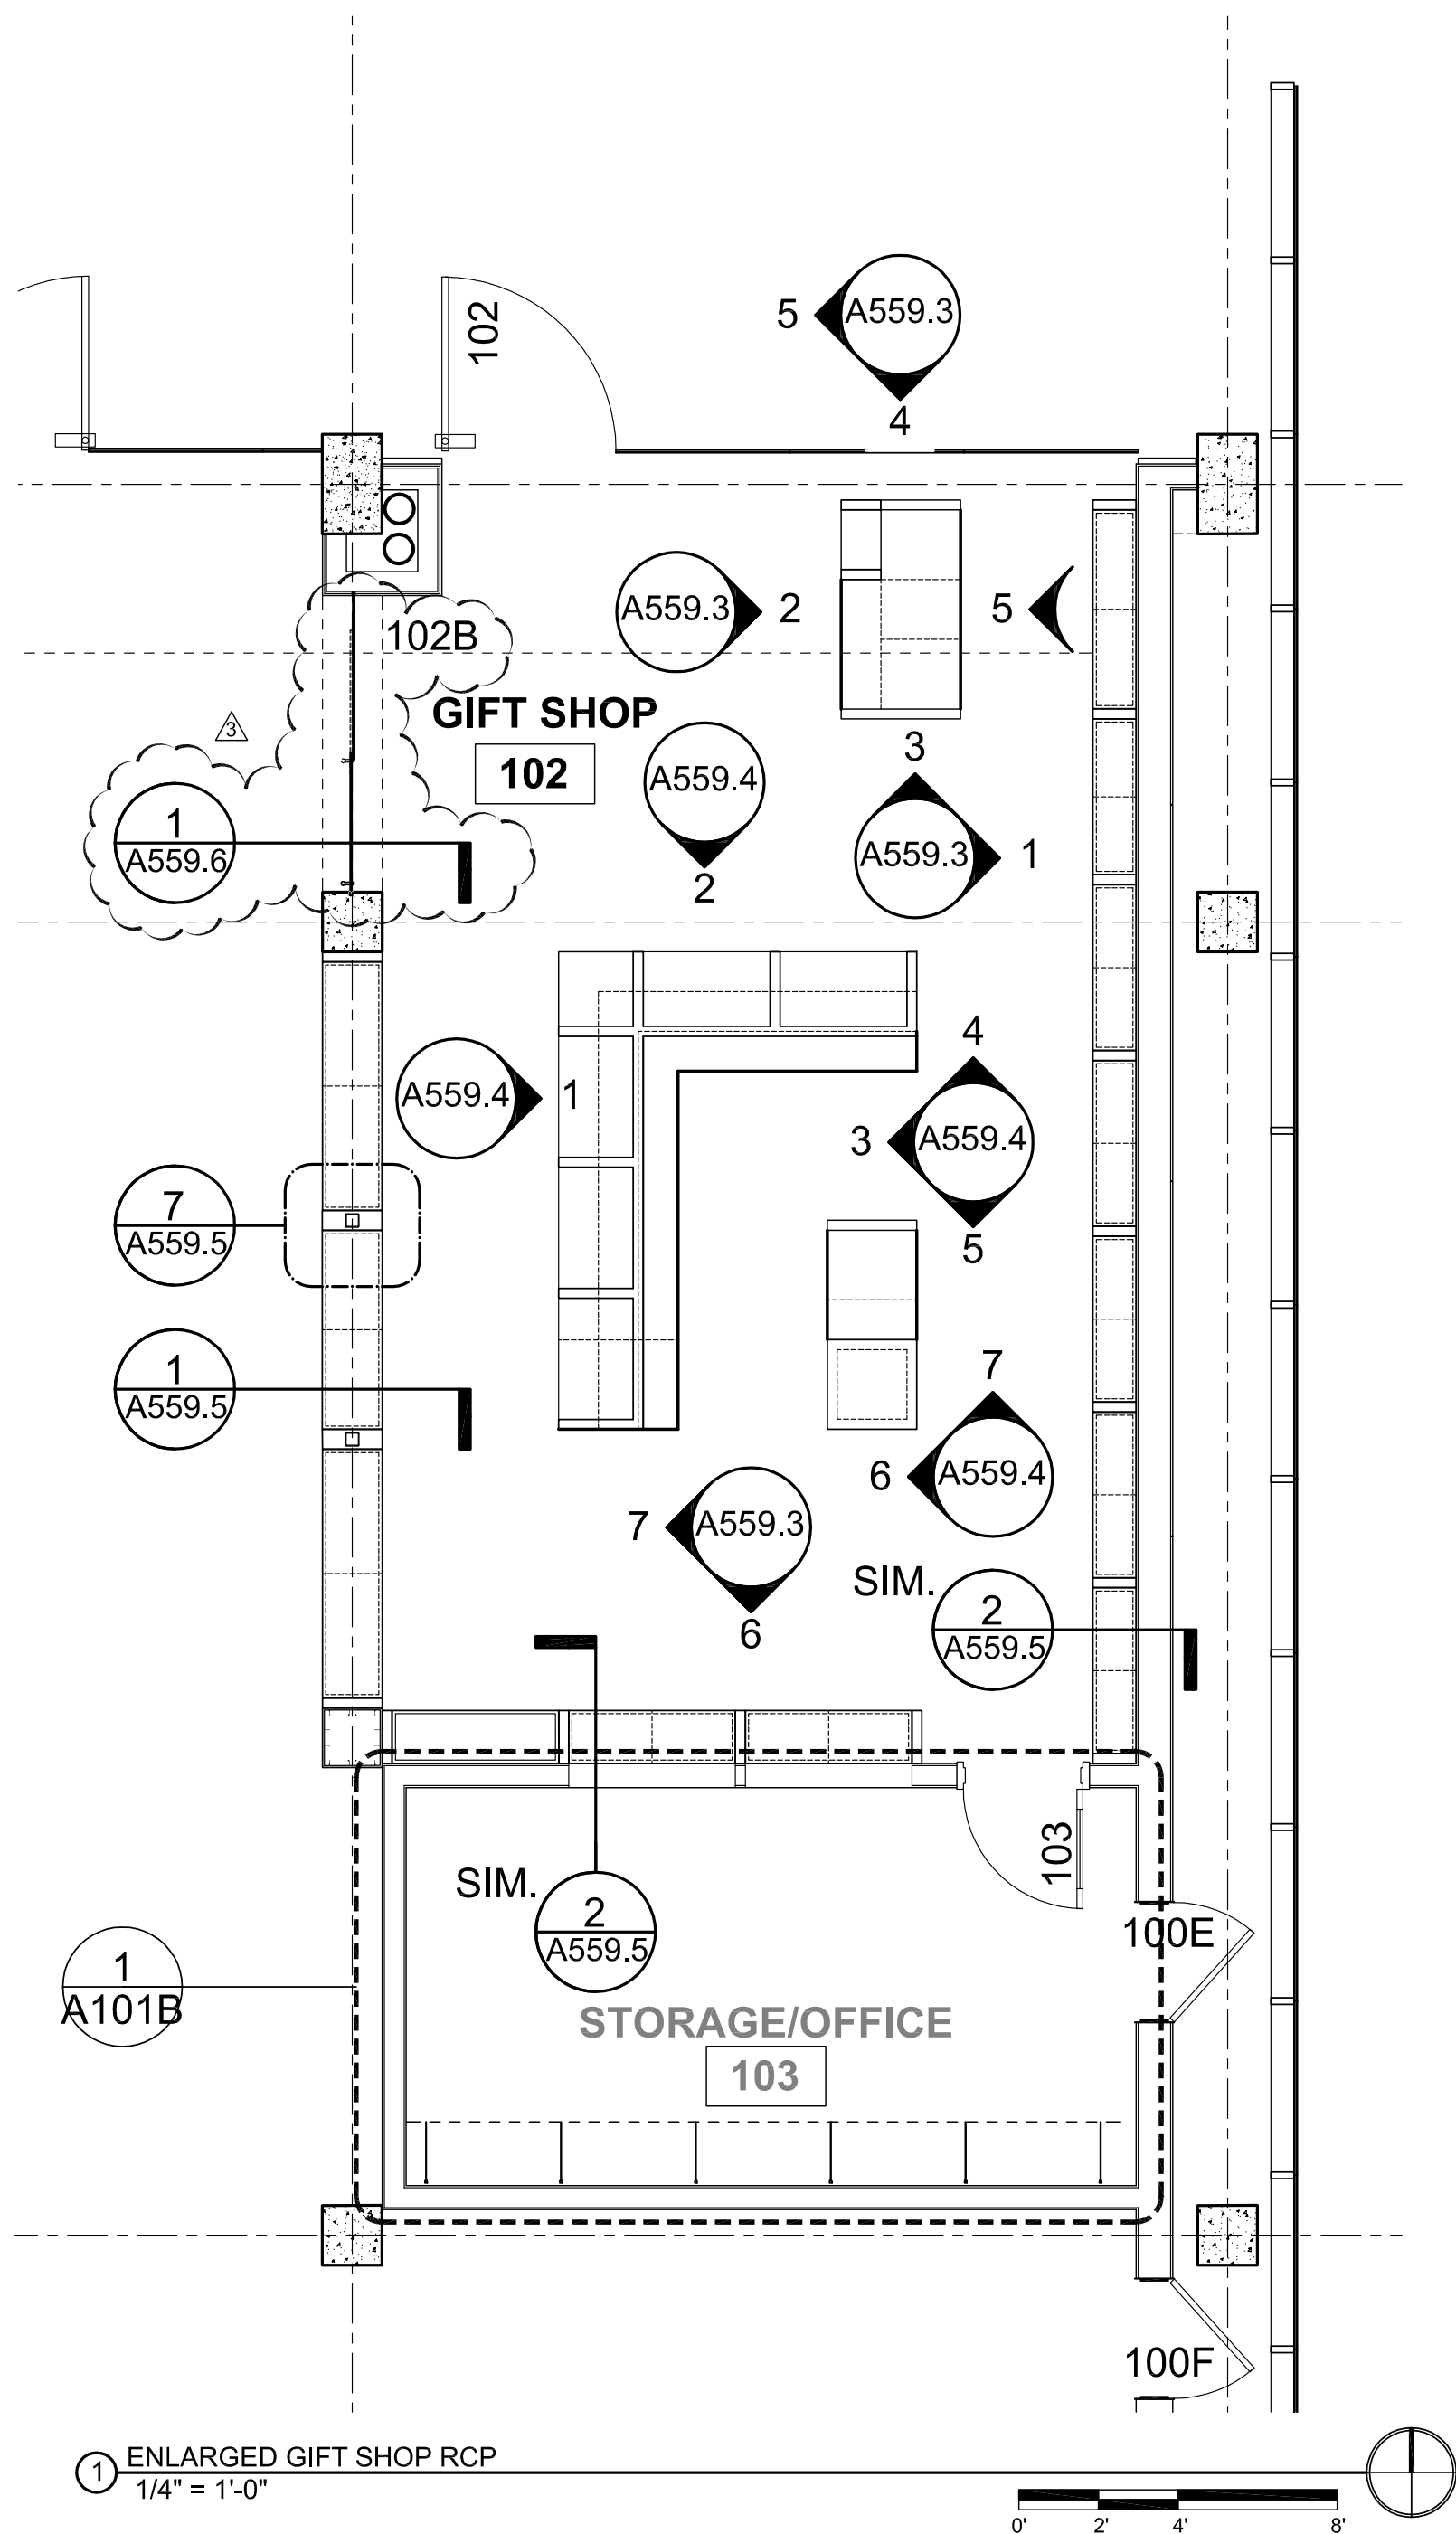

REVISIONS:

- 06.22.12 SUPPLEMENTAL INFO
- 07.03.12 SUPPLEMENTAL INFO

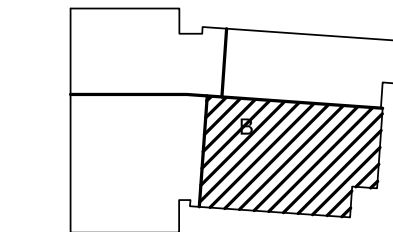

KEYPLAN - (NTS)

CONSTRUCTION
DOCUMENTS

07.03.2012


FLOOR
PLANS

A559.2


ECI/HYER :: THA ARCHITECTURE
DEPARTMENT OF EDUCATION & EARLY DEVELOPMENT
DEPARTMENT OF TRANSPORTATION & PUBLIC FACILITIES
AKSAS PROJECT NO. 68816

STATE OF ALASKA
LIBRARY ARCHIVES MUSEUM


RFI #0931

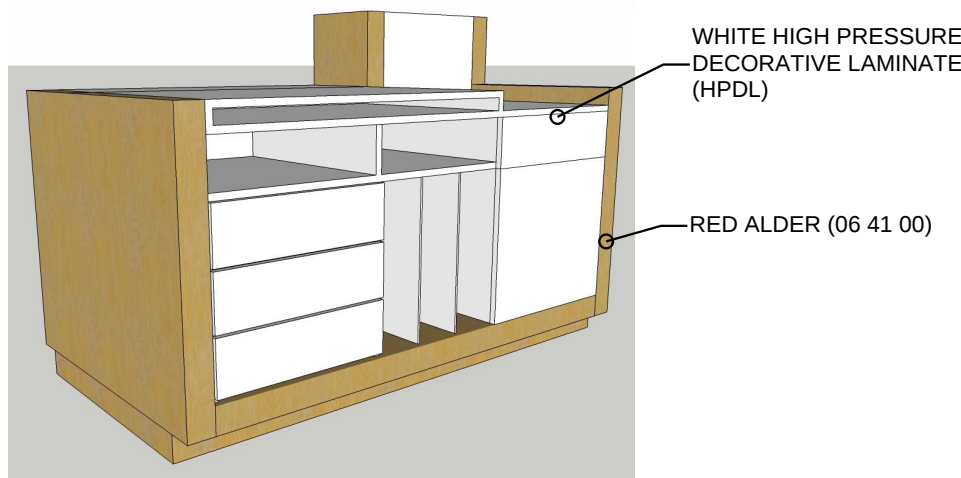


GIFT SHOP CASE 1 - BACK PERSPECTIVE
3D VIEW TO SHOW FINISH INTENT

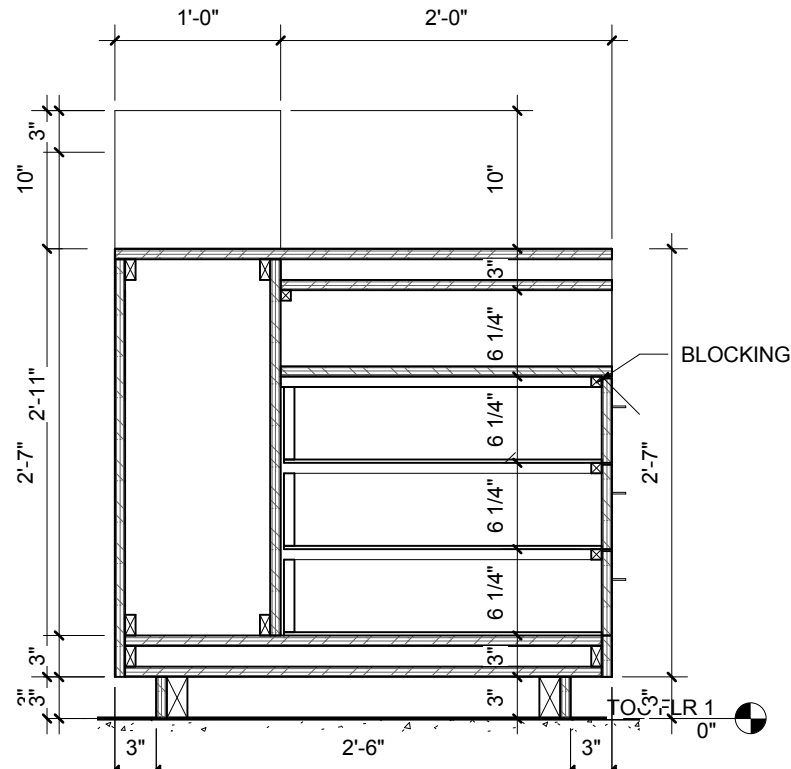


3 GIFT SHOP CASE 1 - SECTION2
1" = 1'-0"

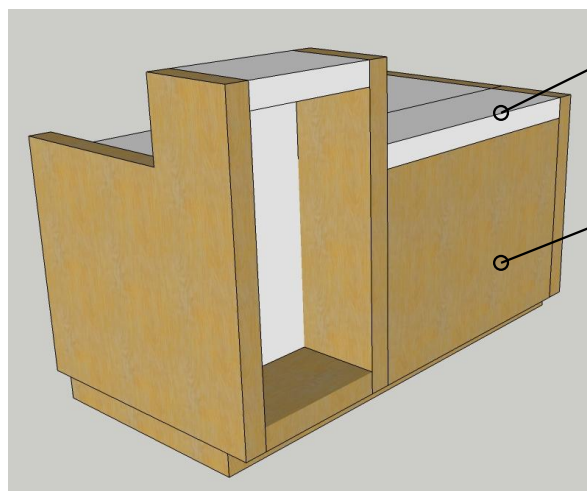

GIFT SHOP CASE 1 - FRONT PERSPECTIVE
3D VIEW TO SHOW FINISH INTENT

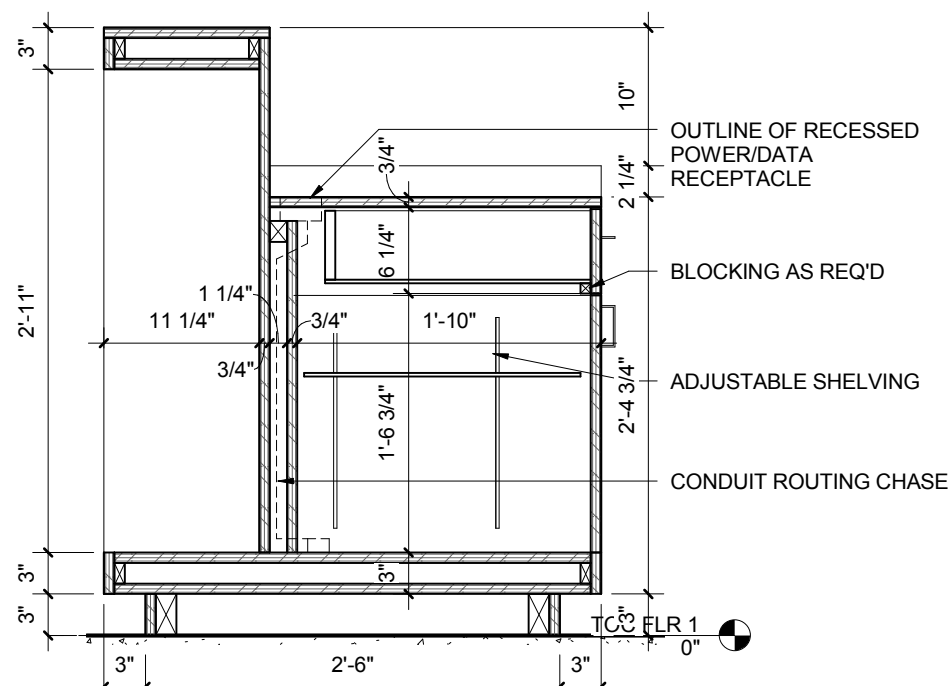

2 GIFT SHOP CASE 1 - SECTION1
1" = 1'-0"

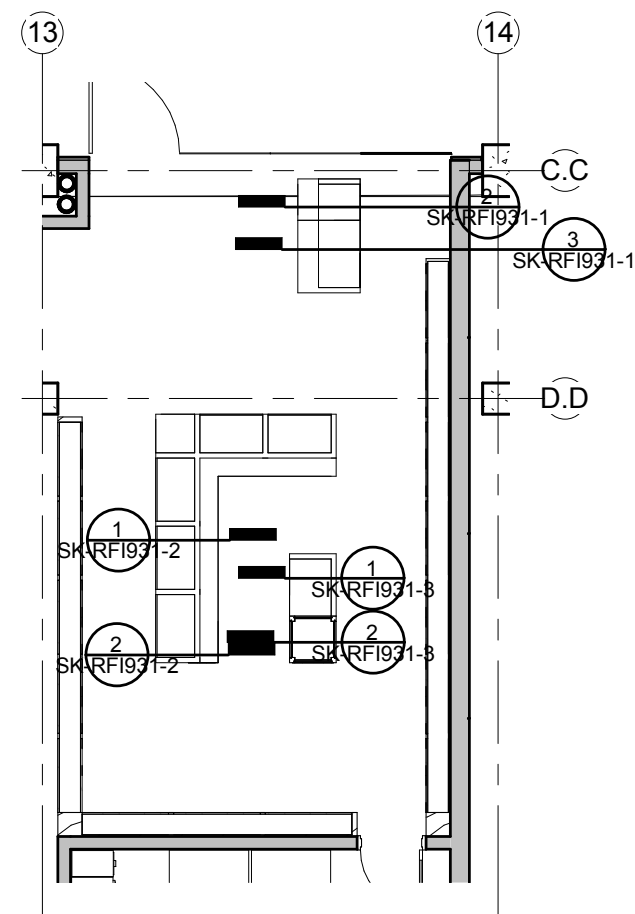

1 GIFT SHOP CASEWORK - KEYPLAN
1/8" = 1'-0"




OWNER
STATE OF ALASKA :
LIBRARY ARCHIVES
MUSEUM

GIFT SHOP CASEWORK	
Project number	10-0005
Date	06/02/15
Drawn by	DPP
Checked by	Scale As indicated

6/2/2015 10:18:51 PM

RFI #0897

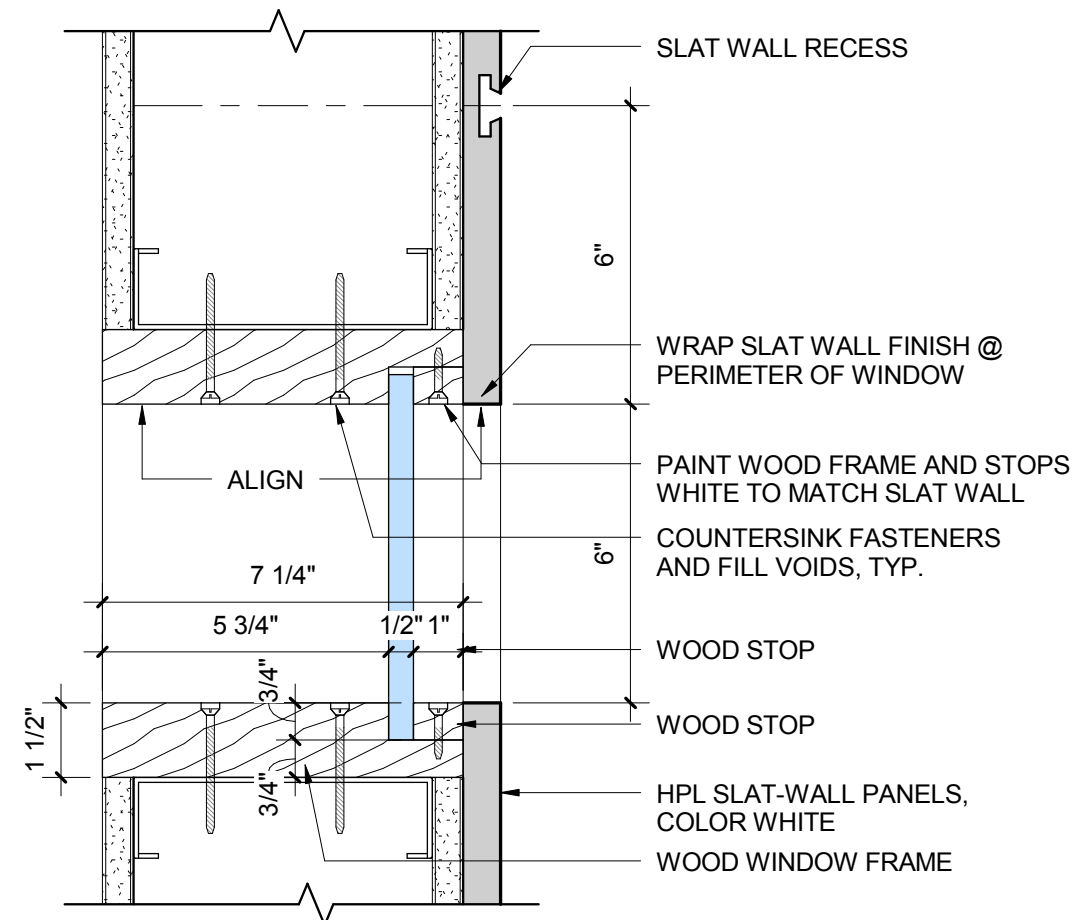


2 MUSEUM GIFT SHOP - WINDOW DETAIL
3" = 1'-0"



OWNER
STATE OF ALASKA :
LIBRARY ARCHIVES
MUSEUM

MUSEUM GIFT SHOP - WINDOW DETAIL	
Project number	10-0005
Date	05/12/15
Drawn by	DPP
Checked by	Scale 3" = 1'-0"

5/12/2015 3:40:52 PM

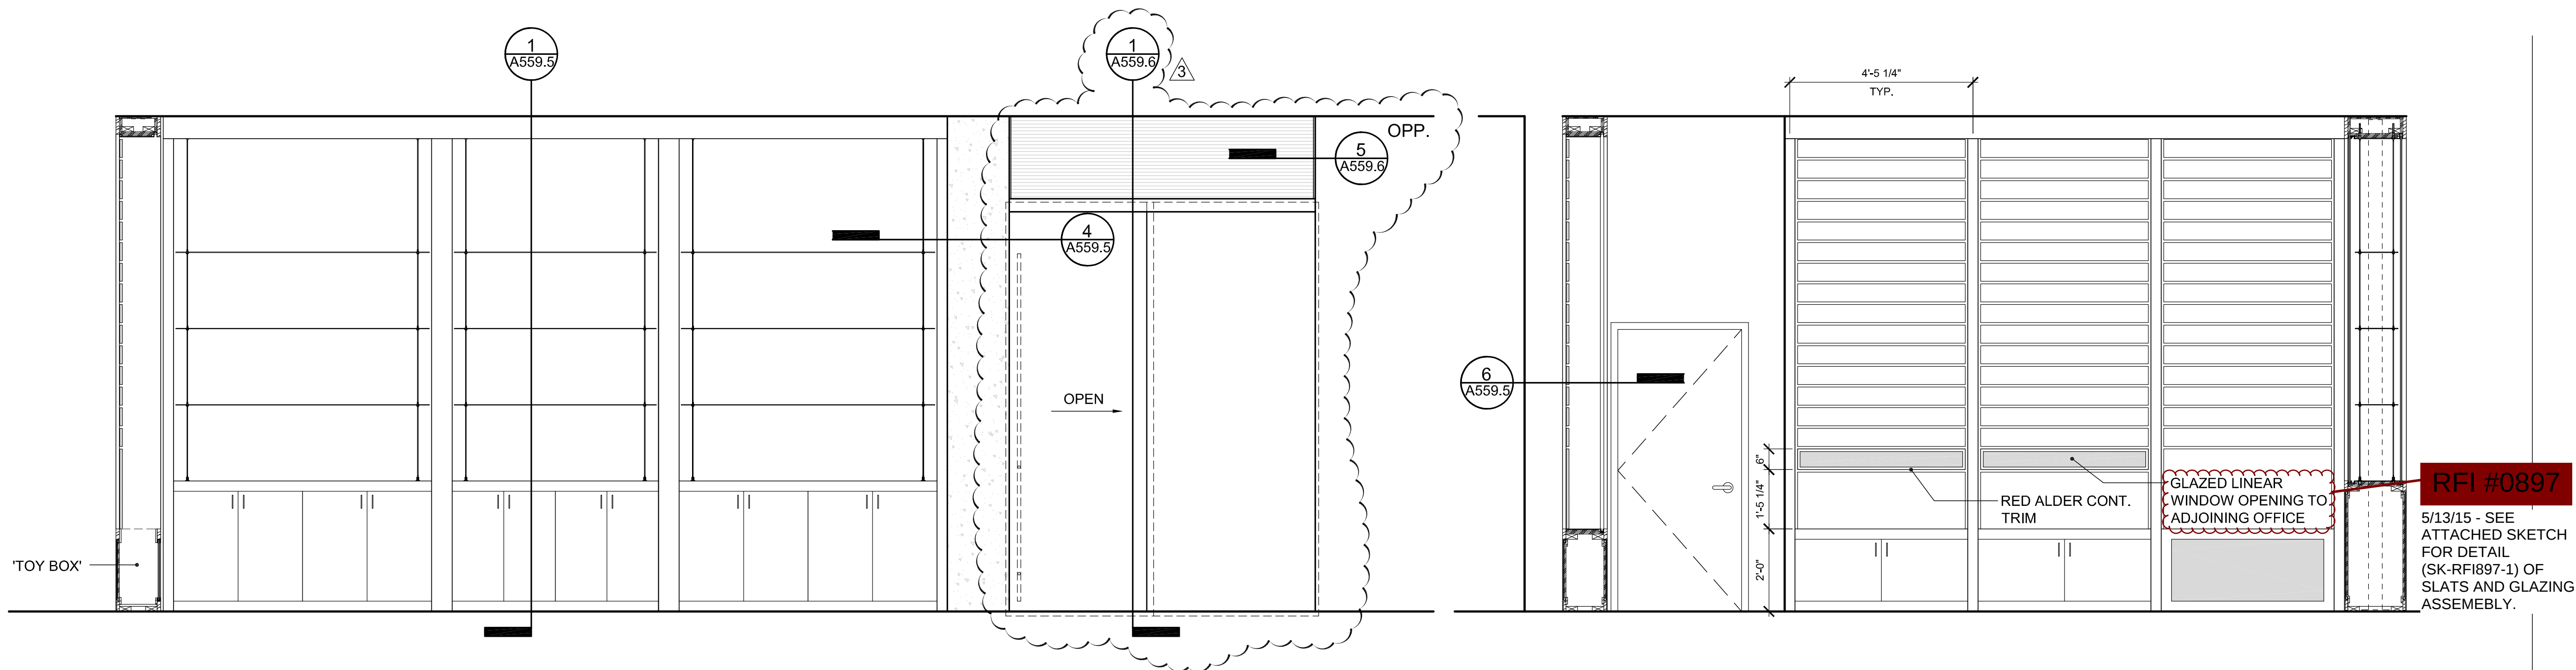

7 EAST ELEVATION - DISPLAY CASES & STORAGE
1/2" = 1'-0"

6 NORTH ELEVATION - DISPLAY CASES & STORAGE
1/2" = 1'-0"


GIFT SHOP CASEWORK: OUTLINE SPECIFICATION

NOTE:
THE MATERIALS AND PRODUCTS SPECIFIED IN THESE GENERAL NOTES ARE SPECIFIC, BUT NOT LIMITED TO FINISH CARPENTRY AND ARCHITECTURAL CASEWORK FOR THE GIFT SHOP. THIS IS ADDITIONAL INFORMATION AND IN NO WAY ALLEVIATES THE CONTRACTOR FROM REVIEWING AND EXECUTING THE PROJECT SPECIFICATION AND APPLICABLE CONTRACT DOCUMENTS, PERTAINING TO, BUT NOT LIMITED TO SPECIFICATION SECTION 06 41 00.

- ALL WOOD CASEWORK TO BE RED ALDER, CUT AND FINISH AS OUTLINED IN SPECIFICATION SECTION 06 41 00, 2.02.
- ALL HIGH PRESSURE DECORATIVE LAMINATE (HPDL) WILL BE WHITE IN COLOR TO MATCH THE HPDL SLATWALL PANELS
- SLATWALL PANELS: BASIS OF DESIGN, 'SLATWALL SYSTEMS', www.slatwallsystems.com
 - PROVIDE DECORATIVE VINYL SNAP IN C-CHANNELS BETWEEN EA, HORIZONTAL BOARD, AT EA, REVEAL - TYP. COLOR TO BE WHITE TO MATCH HPDL PANEL COLOR
 - PROVIDE MILL FINISH ALUMINUM 'L' ANGLE MOUNTED TO ALL EXTERIOR EDGES OF THE SLATWALL PANELS - TYP.
 - PROVIDE A MIN. \$500 ALLOWANCE FOR SLATWALL ORGANIZERS AND MERCHANDISERS - FINAL SELECTIONS TO BE MADE BY THE OWNER.
 - PROVIDE THE 12" CHROME STRAIGHT ARM SHELF BRACKETS - (4) SHELVES PER CASE, (2) BRACKETS PER SHELF, TYP.

RFI #0931

6/3/15 - SEE ATTACHED SKETCHED SKETCH SK-RFI931-1 FOR ADDITIONAL FINISH CLARIFICATIONS AND SECTION VIEWS.

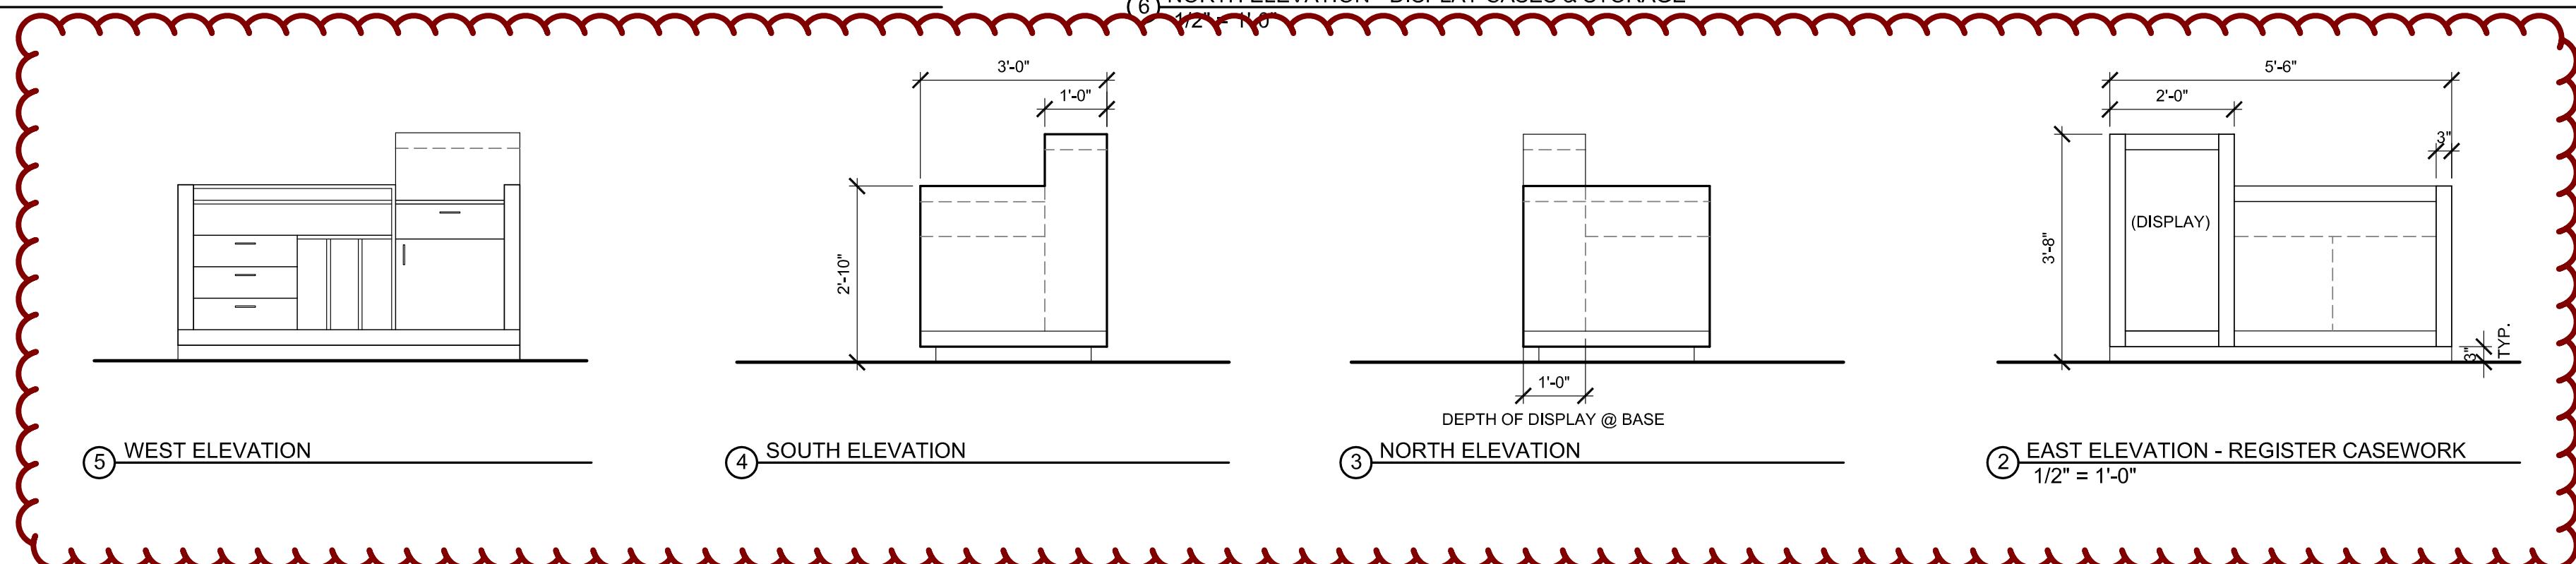


5 WEST ELEVATION

4 SOUTH ELEVATION

3 NORTH ELEVATION

2 EAST ELEVATION - REGISTER CASEWORK
1/2" = 1'-0"

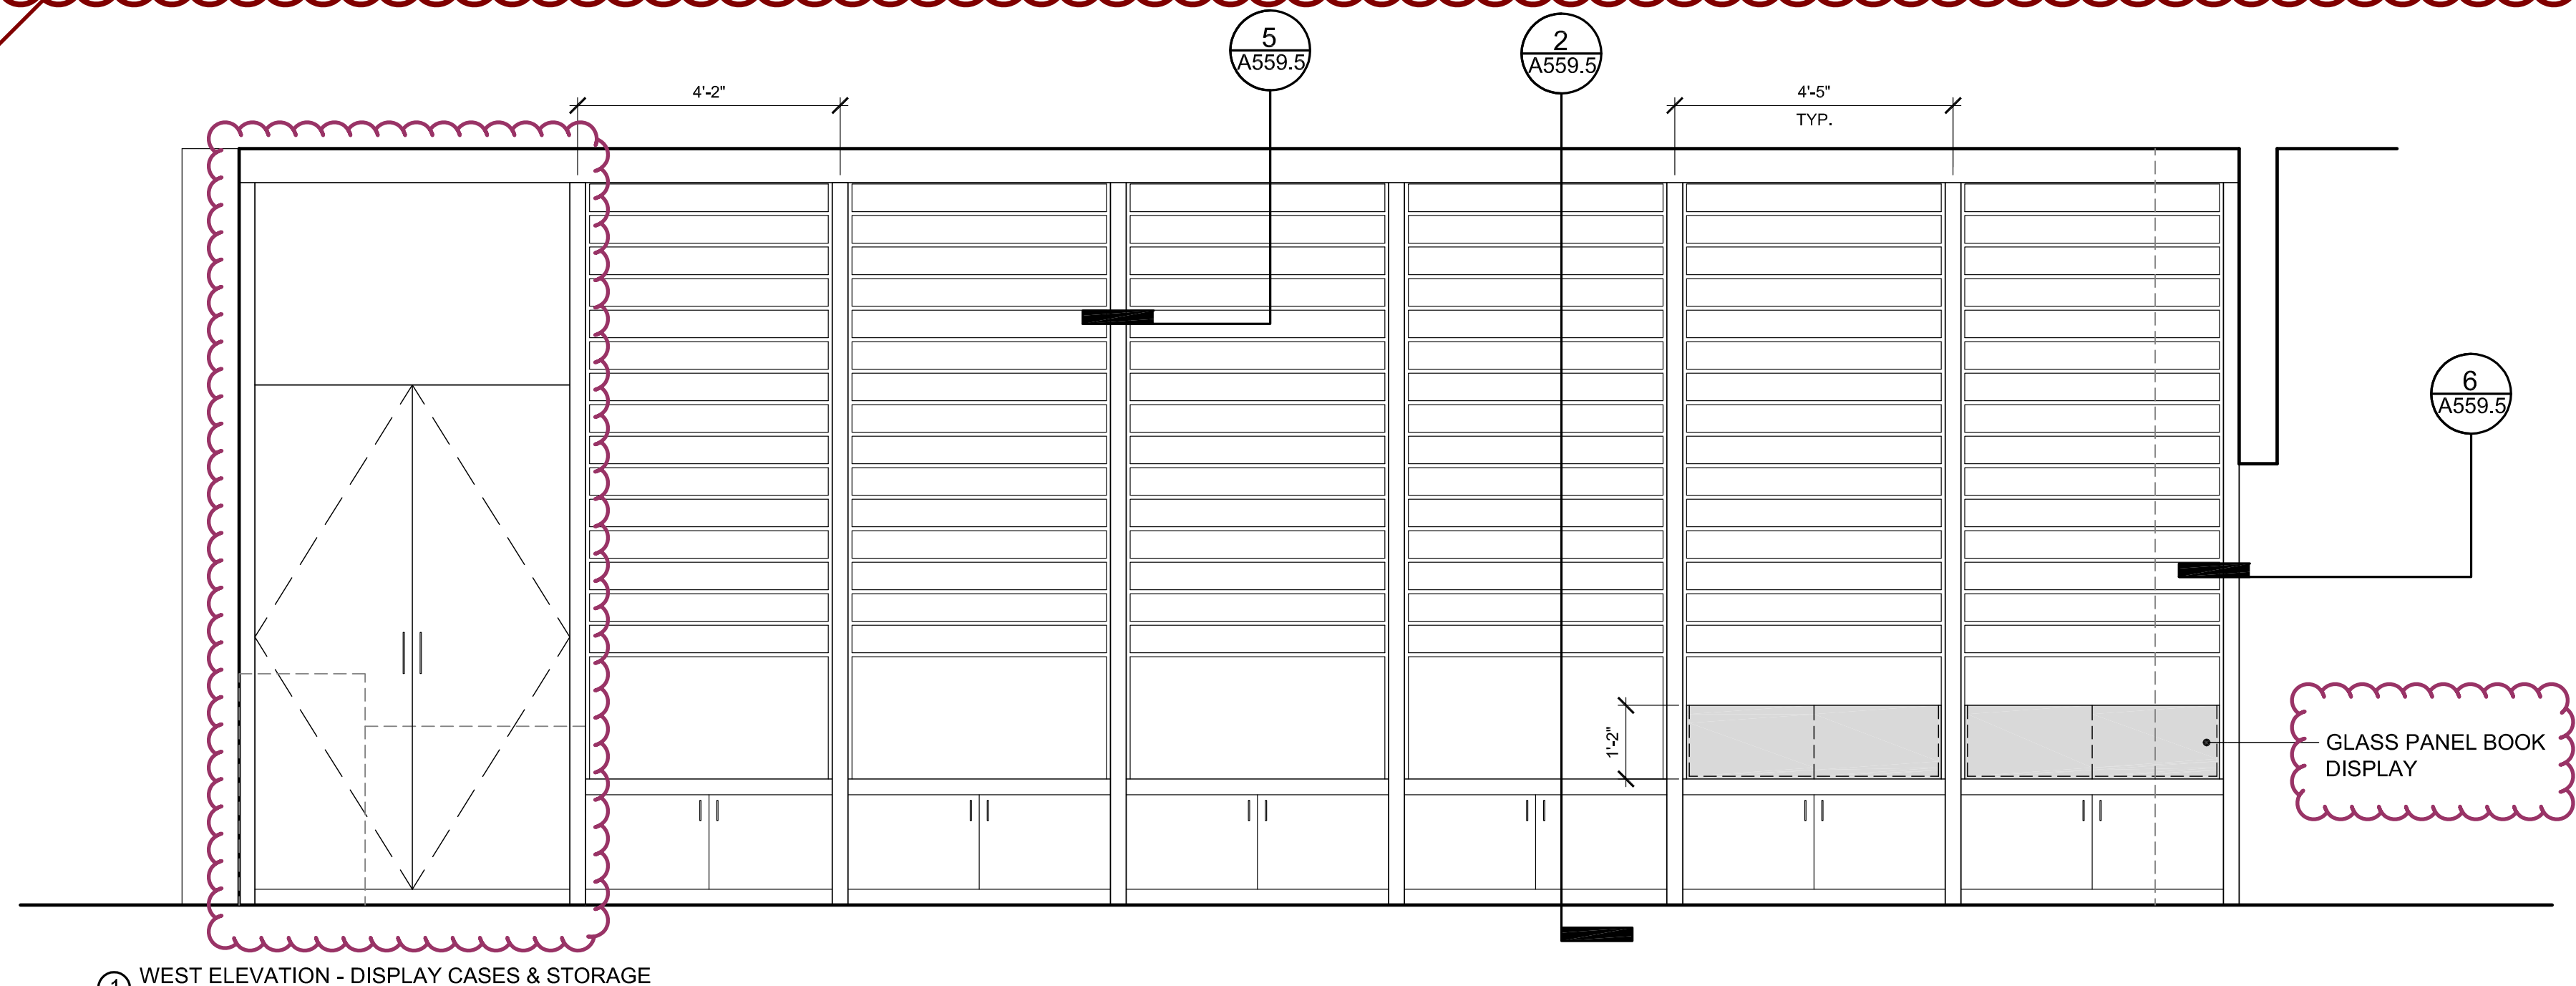


1 WEST ELEVATION - DISPLAY CASES & STORAGE
1/2" = 1'-0"

RFI# 1096

8/27/15- door is designed to have behind gift shop register for storage. Door hardware per RFI for Bi fold doors.

RFI# 1085

8/27/15- See RFI sketch SK-RFI1085-1 for details on glass panel book displays.

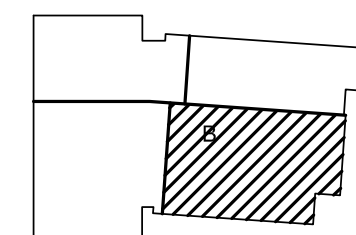


KEYPLAN - (NTS)

CONSTRUCTION DOCUMENTS

07.03.2012



INTERIOR ELEVATIONS

A559.3

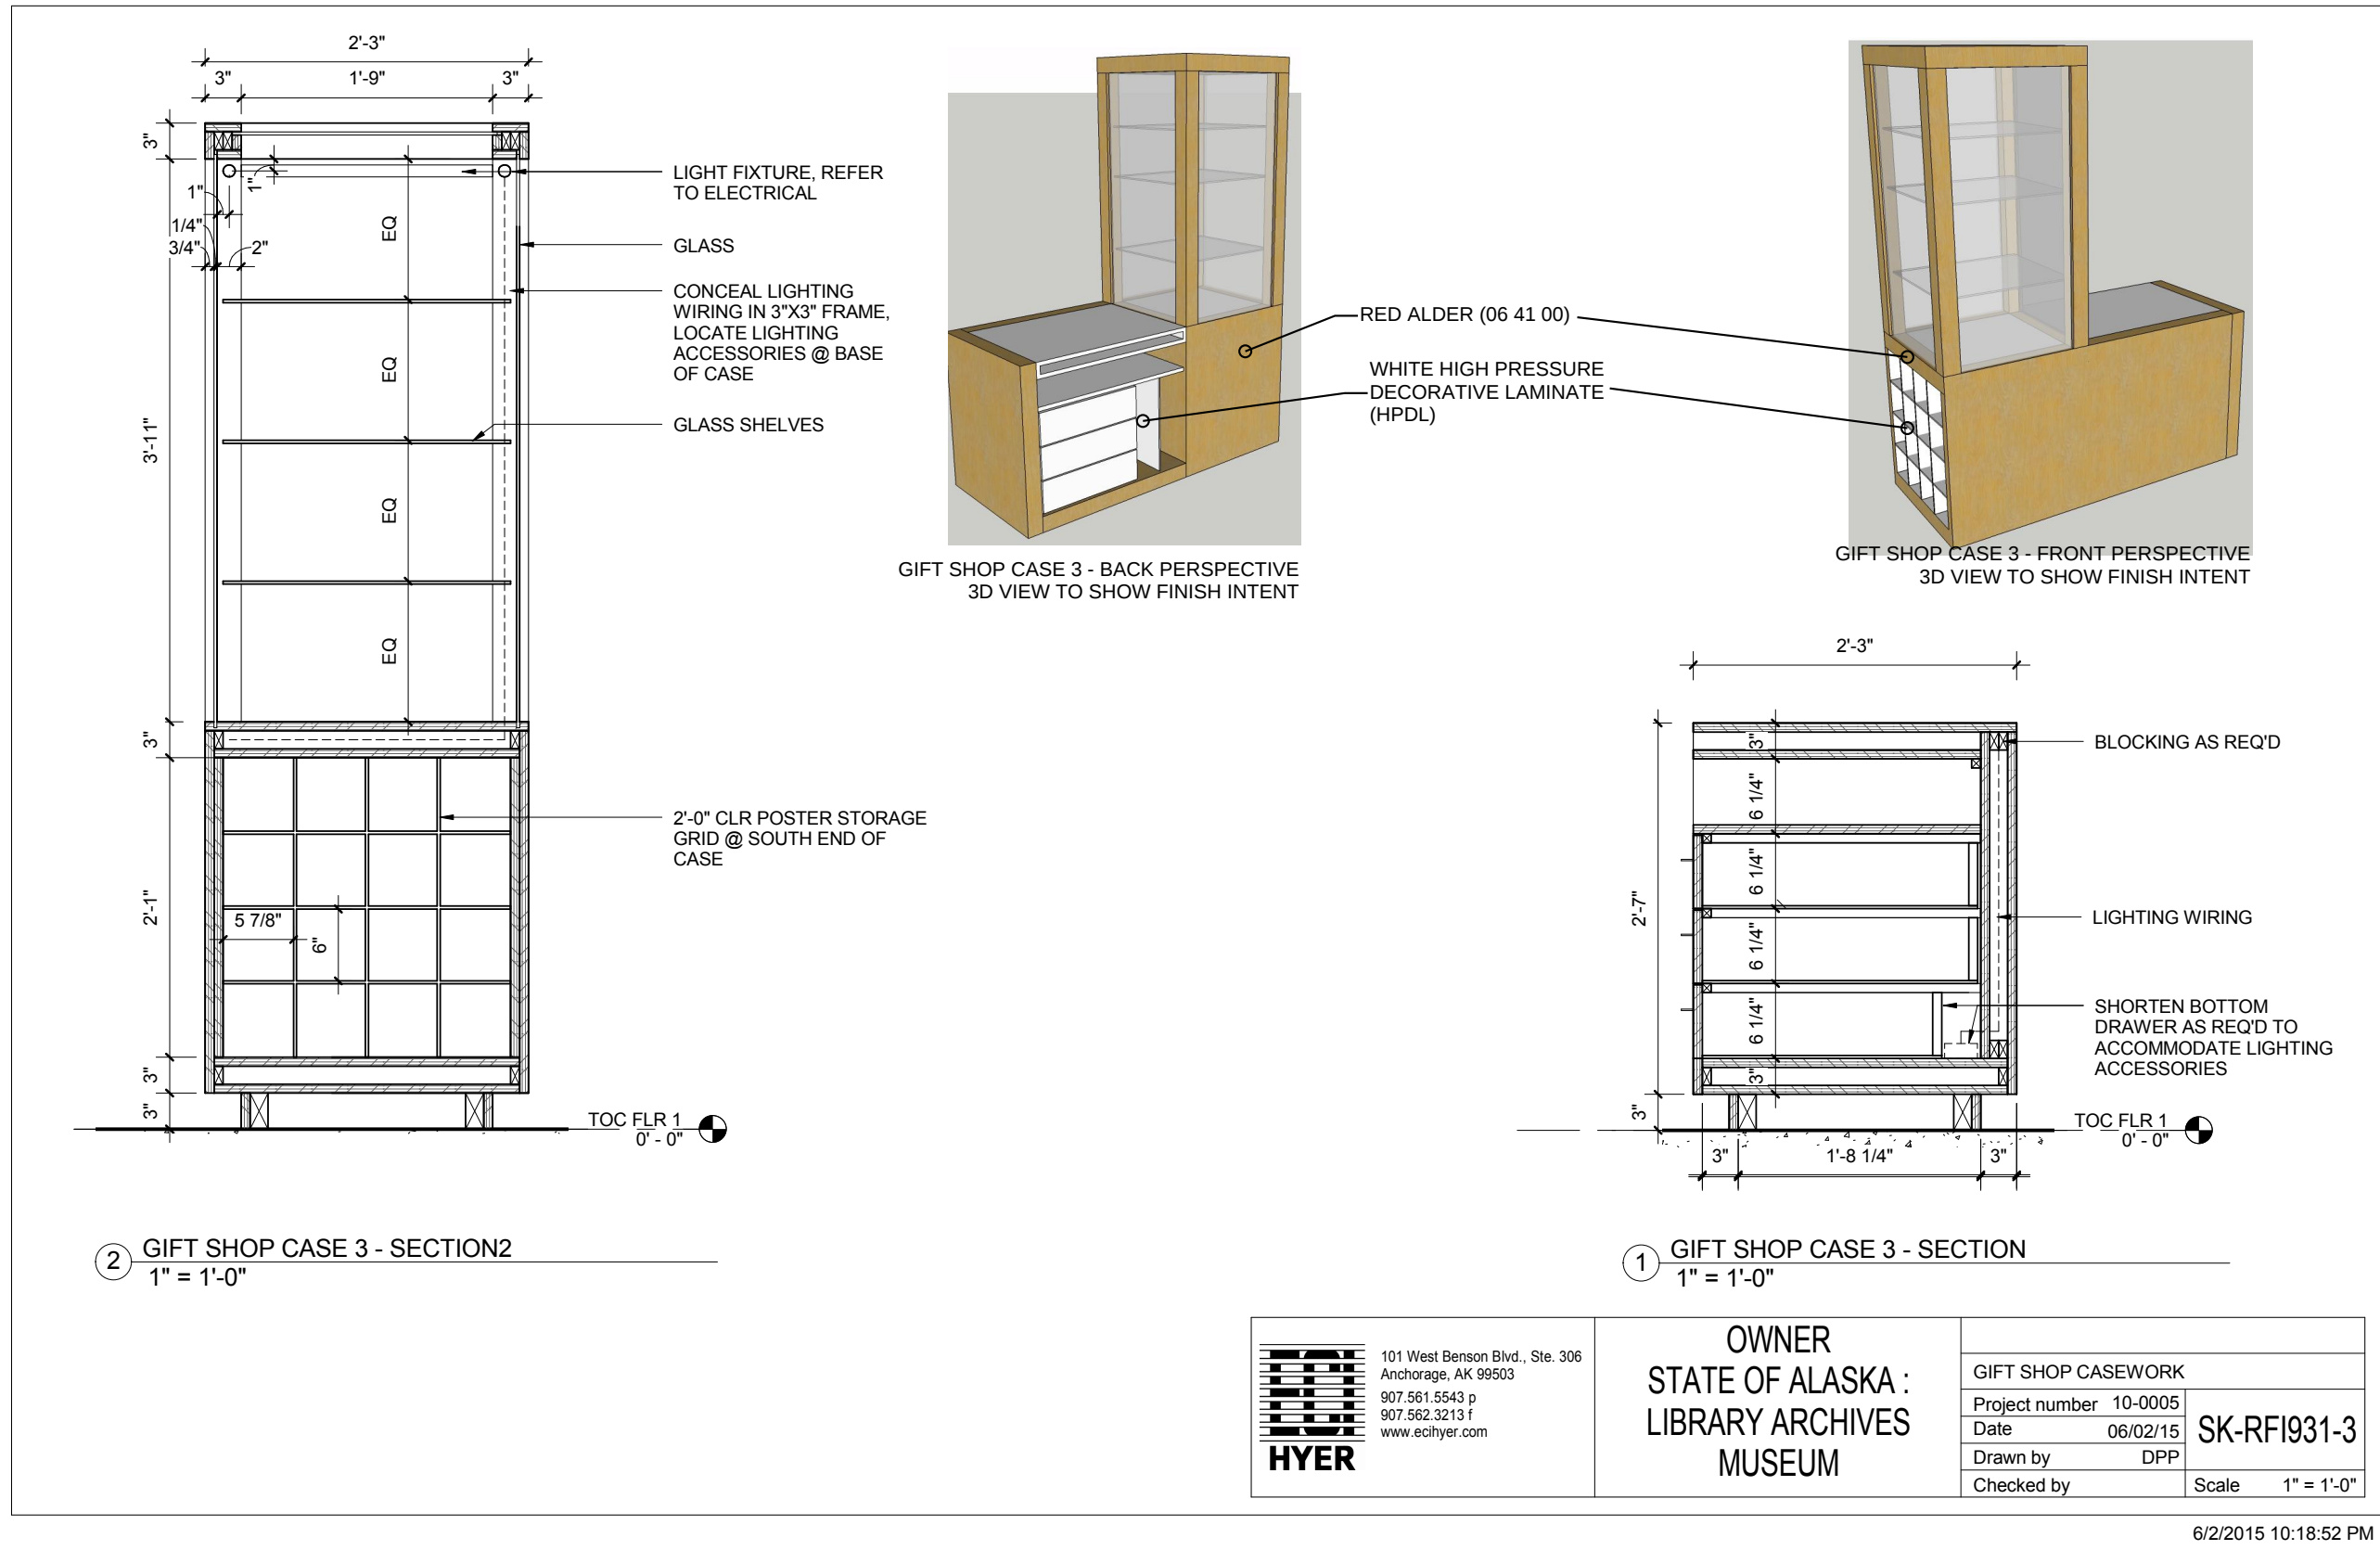


RFI #0931


6/3/15 - SEE
ATTACHED SKETCH
SK-RF1931-3 AND 2
FOR ADDITIONAL
FINISH
CLARIFICATIONS
AND SECTION
VIEWS.

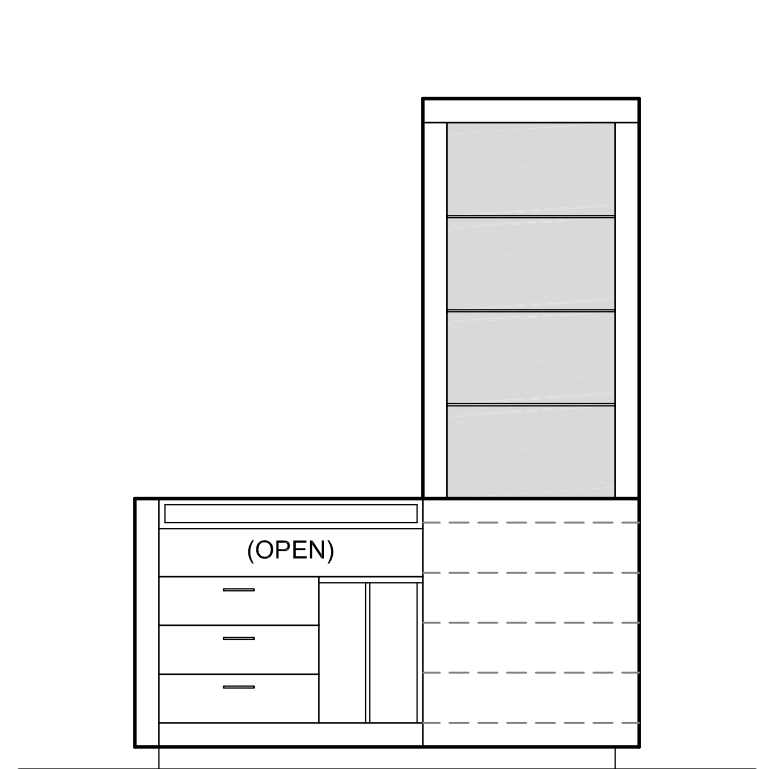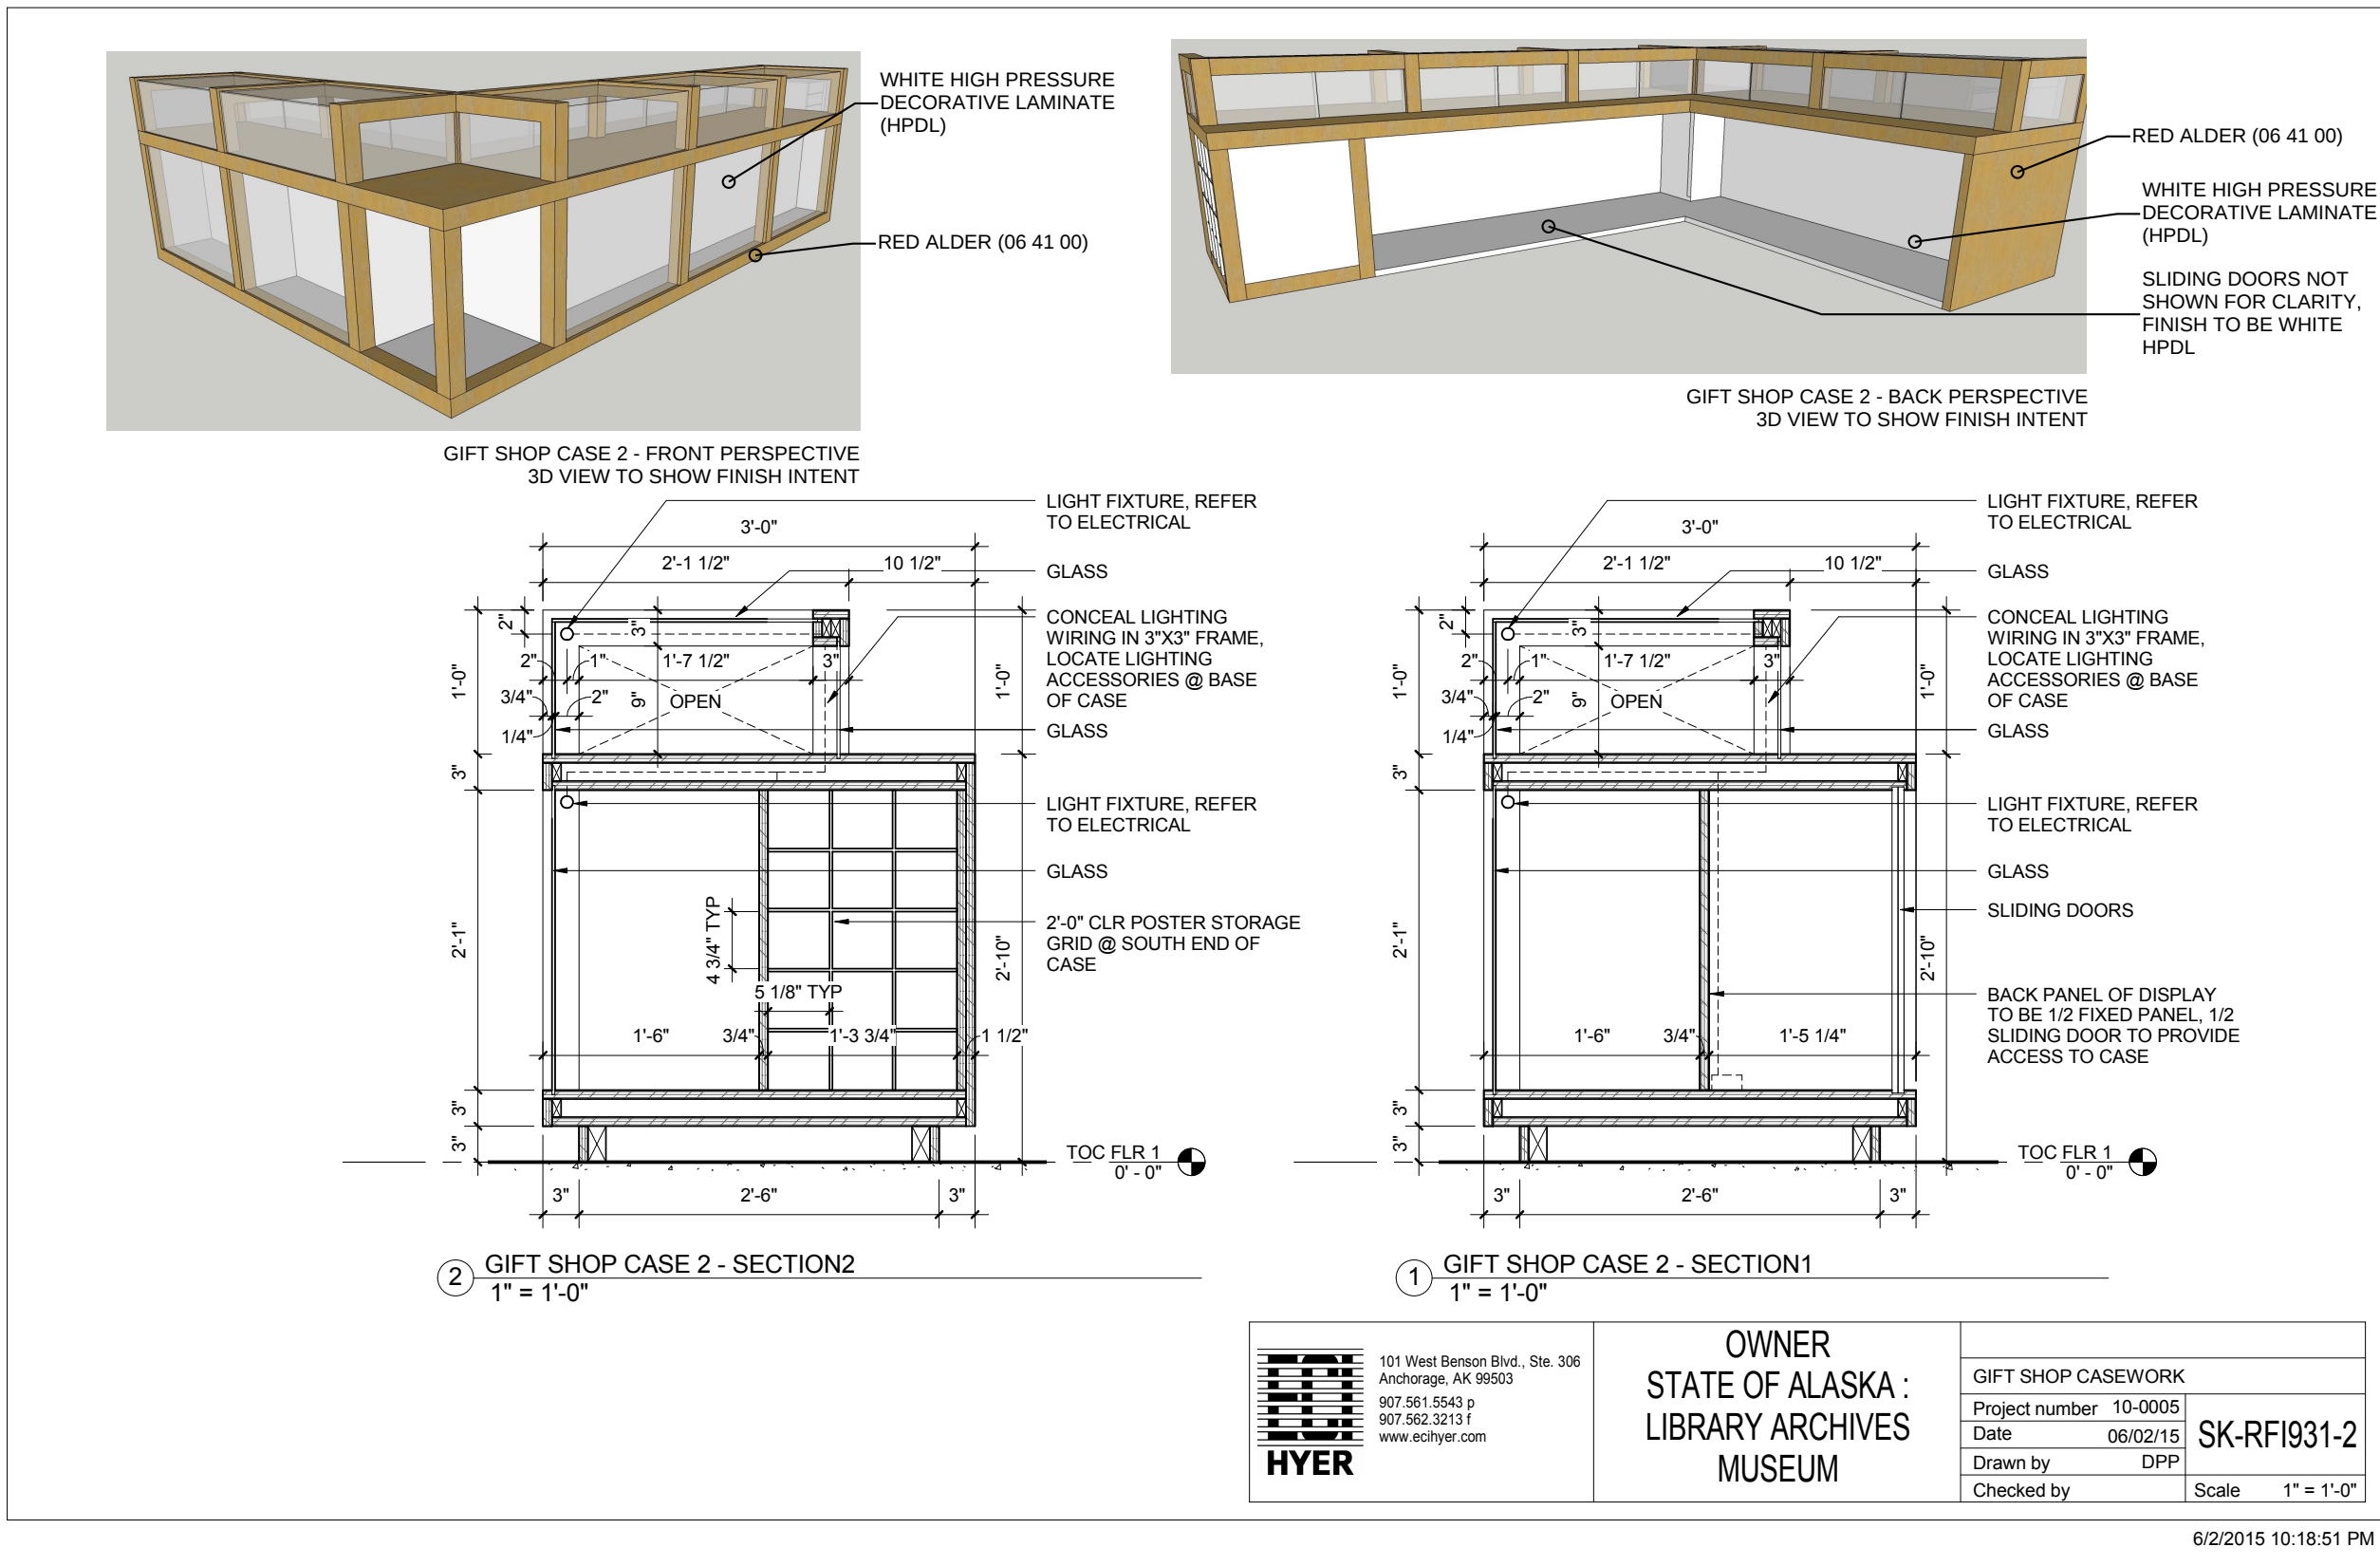


8 EAST ELEVATION - DISPLAY CASES & STORAGE
1/2" = 1'-0"

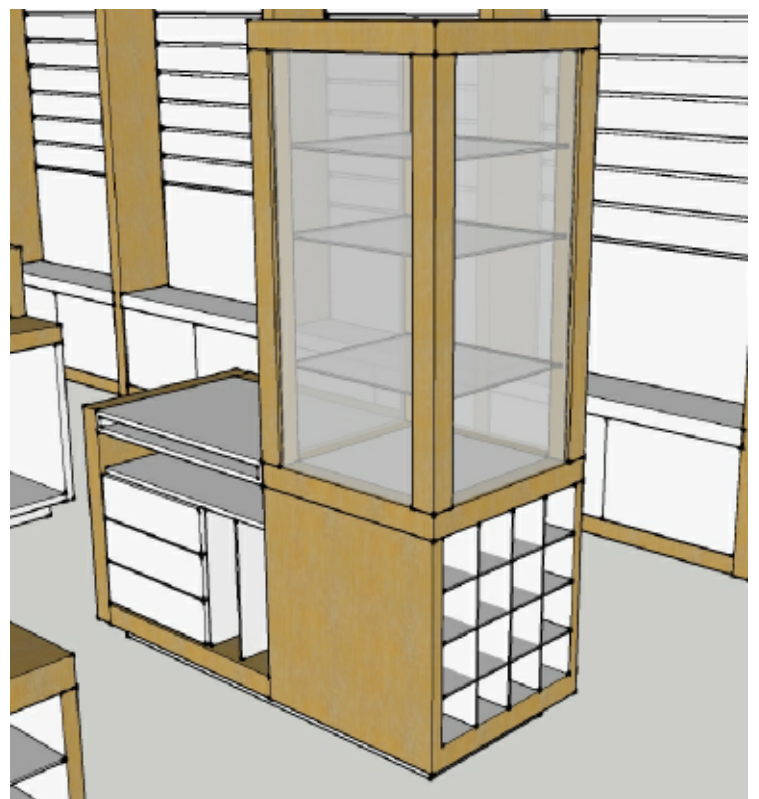


7B TOWER CASE - PERSPECTIVE
N.T.S.

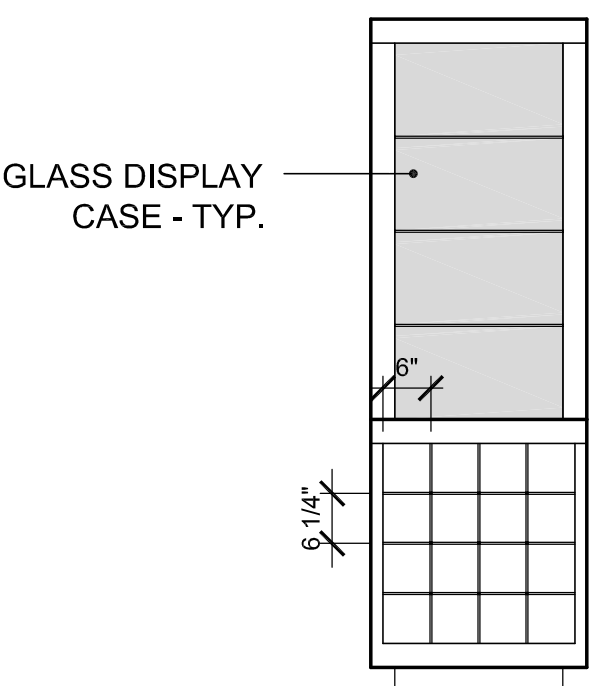


7 EAST ELEVATION - DISPLAY CASES & STORAGE
1/2" = 1'-0"

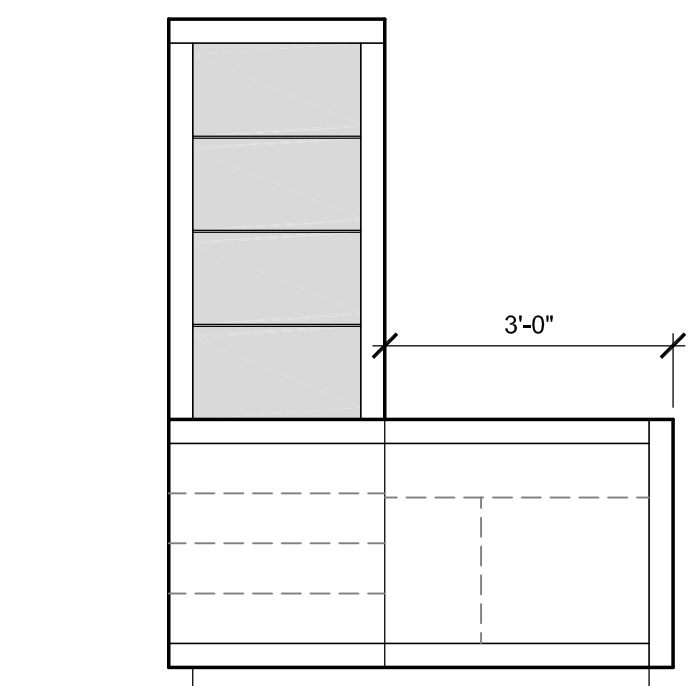


6 EAST ELEVATION - DISPLAY CASES & STORAGE
1/2" = 1'-0"

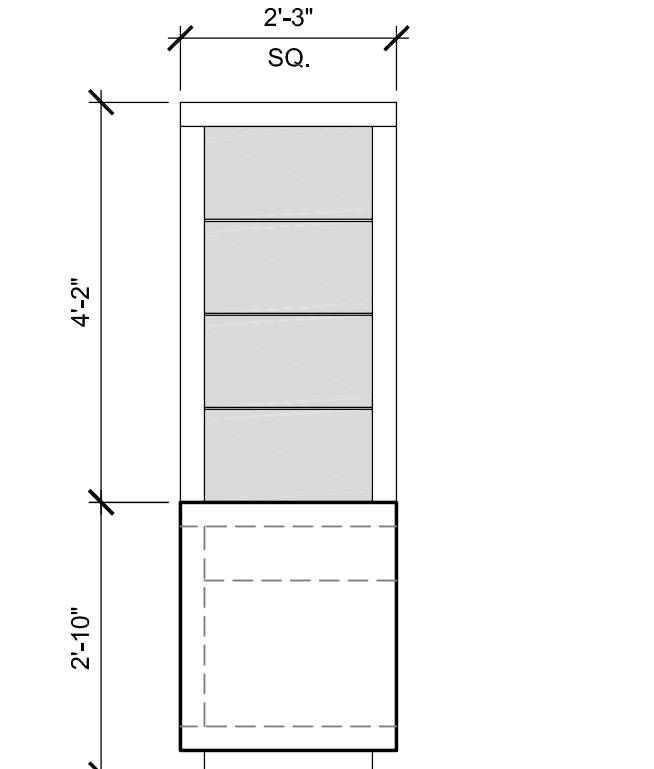


5 NORTH ELEVATION - DISPLAY CASES & STORAGE
1/2" = 1'-0"

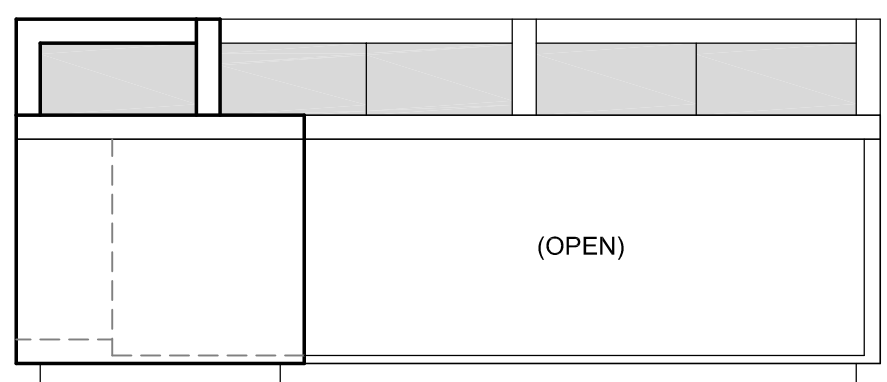


4 SOUTH ELEVATION - DISPLAY CASES & STORAGE
1/2" = 1'-0"

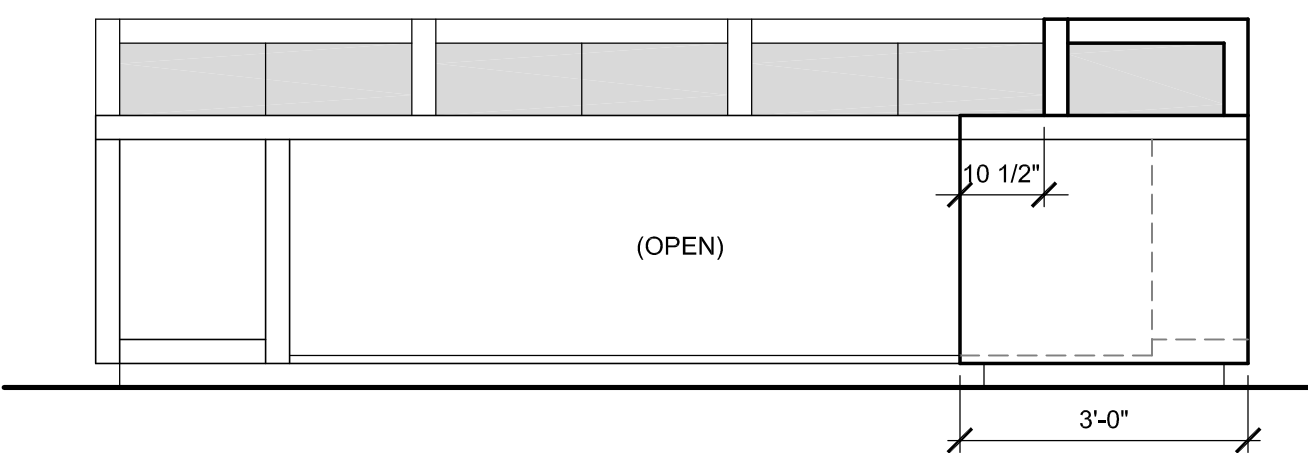

3 EAST ELEVATION - DISPLAY CASES & STORAGE
1/2" = 1'-0"

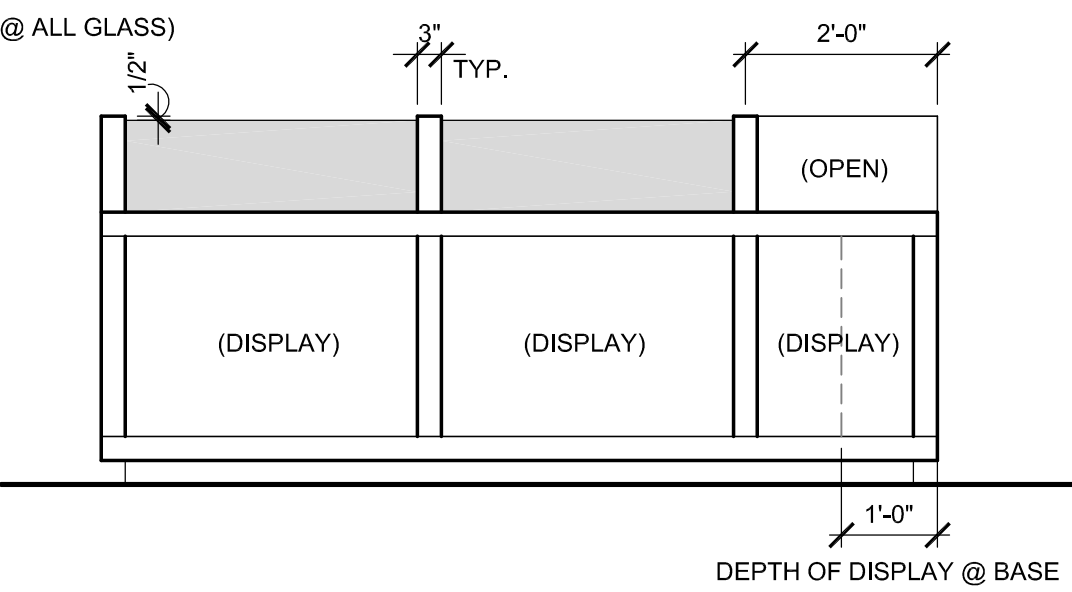


2 NORTH ELEVATION - DISPLAY CASES & STORAGE
1/2" = 1'-0"

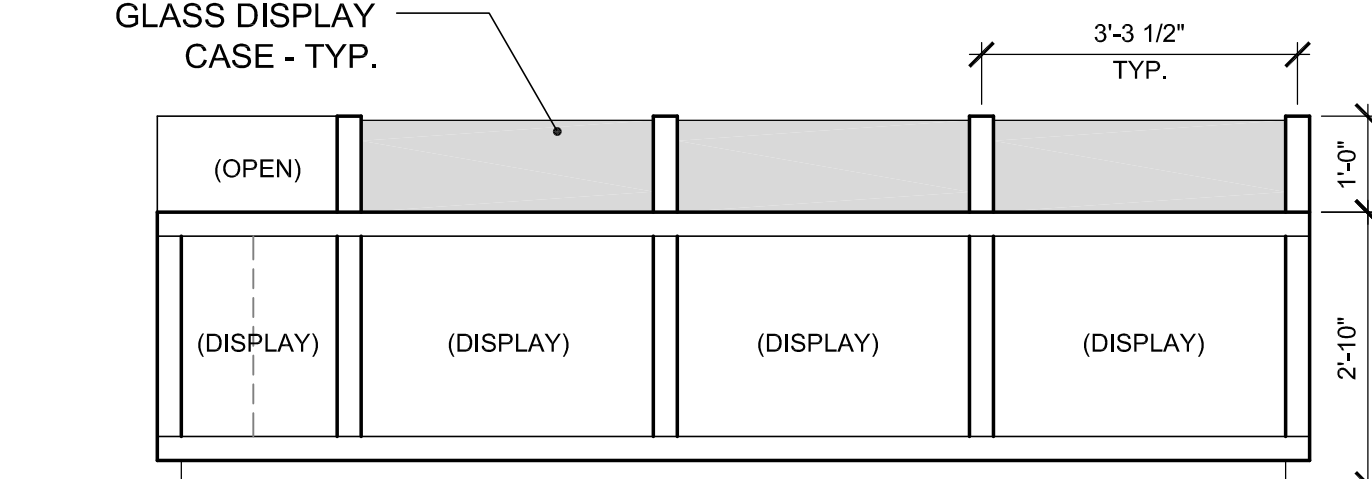

1 WEST ELEVATION - DISPLAY CASES & STORAGE
1/2" = 1'-0"

REVISIONS:
06.22.12 SUPPLEMENTAL

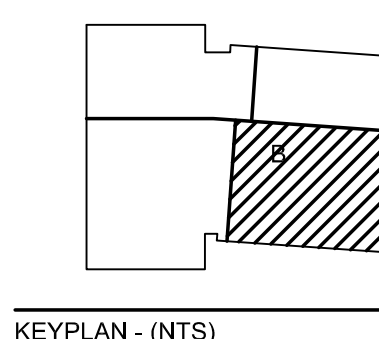

CONSTRUCTION DOCUMENT

06.22.2012

INTERIOR ELEVATION

ECI/HYER :: THA ARCHITECTURE
DEPARTMENT OF EDUCATION & EARLY DEVELOPMENT




8/28/15- ceiling is to have 1" gap between face of trim and wd trim. Add GWB as needed to flush out with column beyond and face of wd trim. GWB above trim painted P-1.




8/24/15- add soffits to east and south wall in gift shop to support this detail.

CONSTRUCTION
DOCUMENTSCASEWORK
DETAILS

A559.5

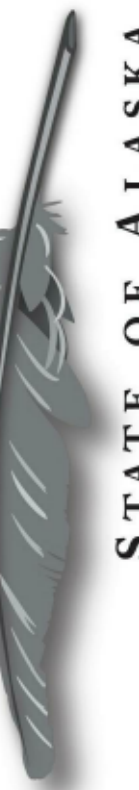

REVISIONS:
A 07.03.12 SUPPLEMENTAL

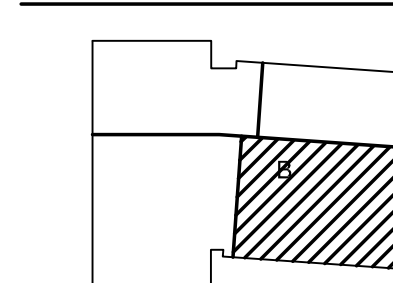

KEYPLAN - (NTS)


CONSTRUCTION
DOCUMENT

07.03.2012


CASEWORK
DETAILS

RFI#0831


4/2/15 - At museum side
(left side) replace solid
wood panel with GL-11
per RFI.

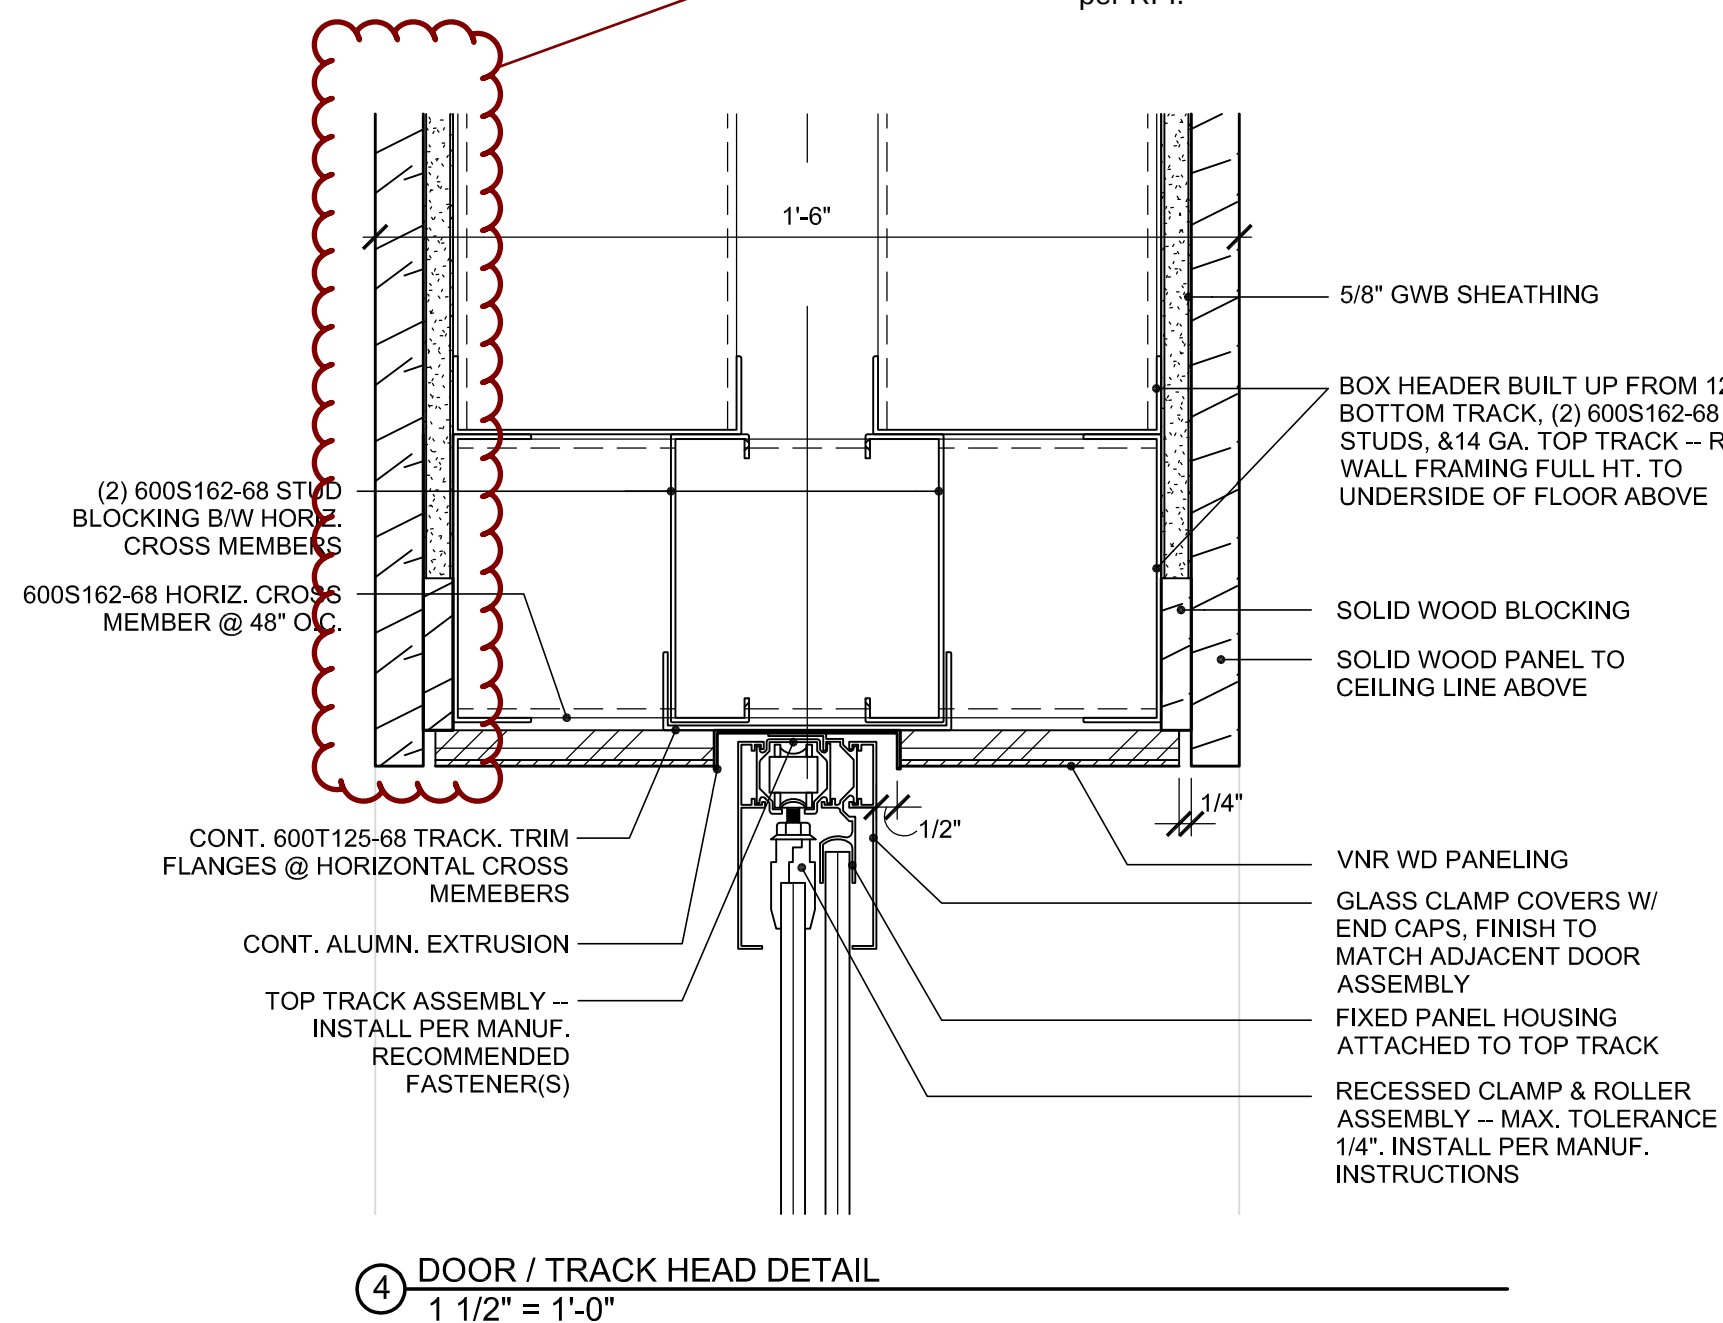


④ DOOR / TRACK HEAD DETAIL
1 1/2" = 1'-0"

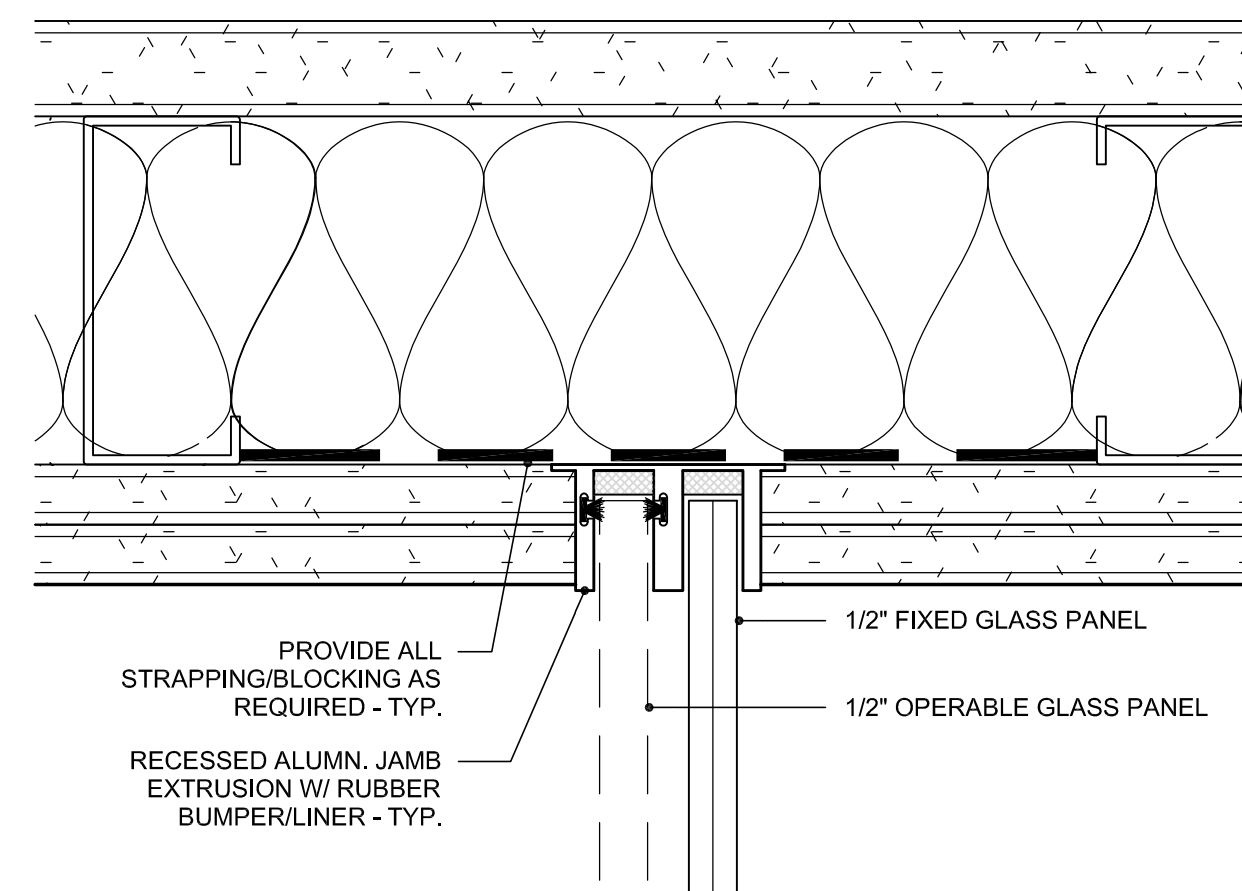

③ JAMB RECEIVER DETAIL - TYP.
1 1/2" = 1'-0"

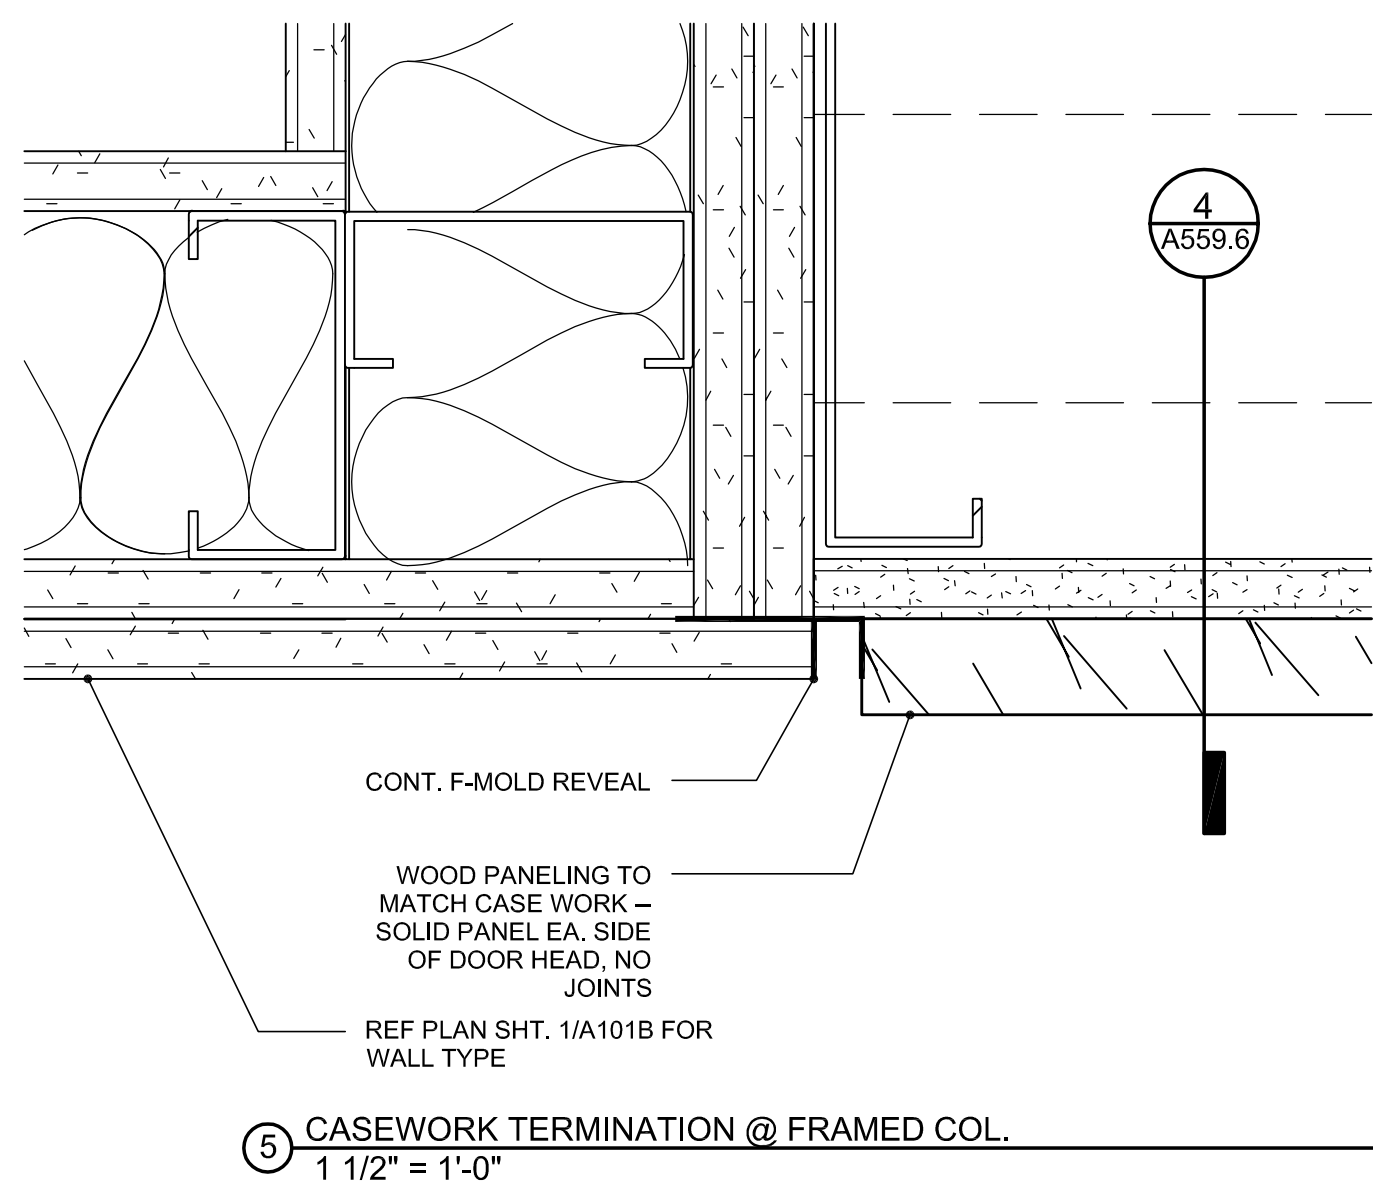


⑤ CASEWORK TERMINATION @ FRAMED COL.
1 1/2" = 1'-0"

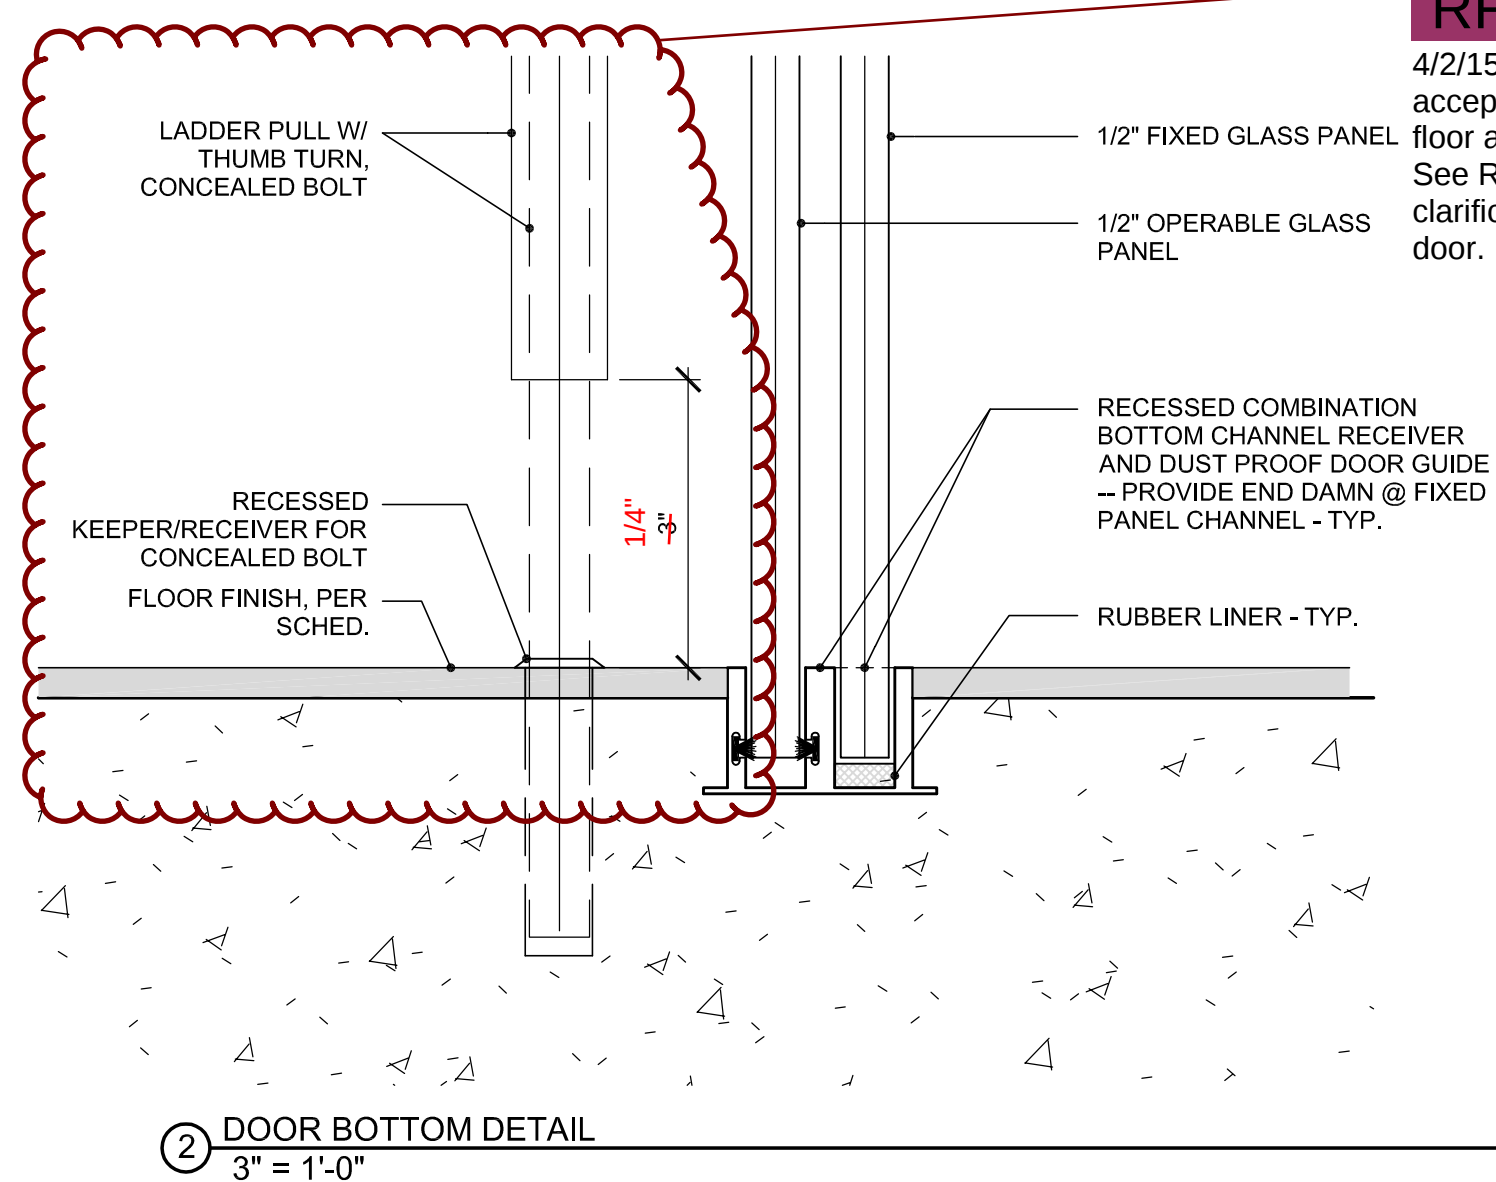

② DOOR BOTTOM DETAIL
3" = 1'-0"

RFI#0831

4/2/15 - A 1/4" gap is
acceptable between finish
floor and bottom of handle.
See RFI for further
clarification to sliding glass
door.

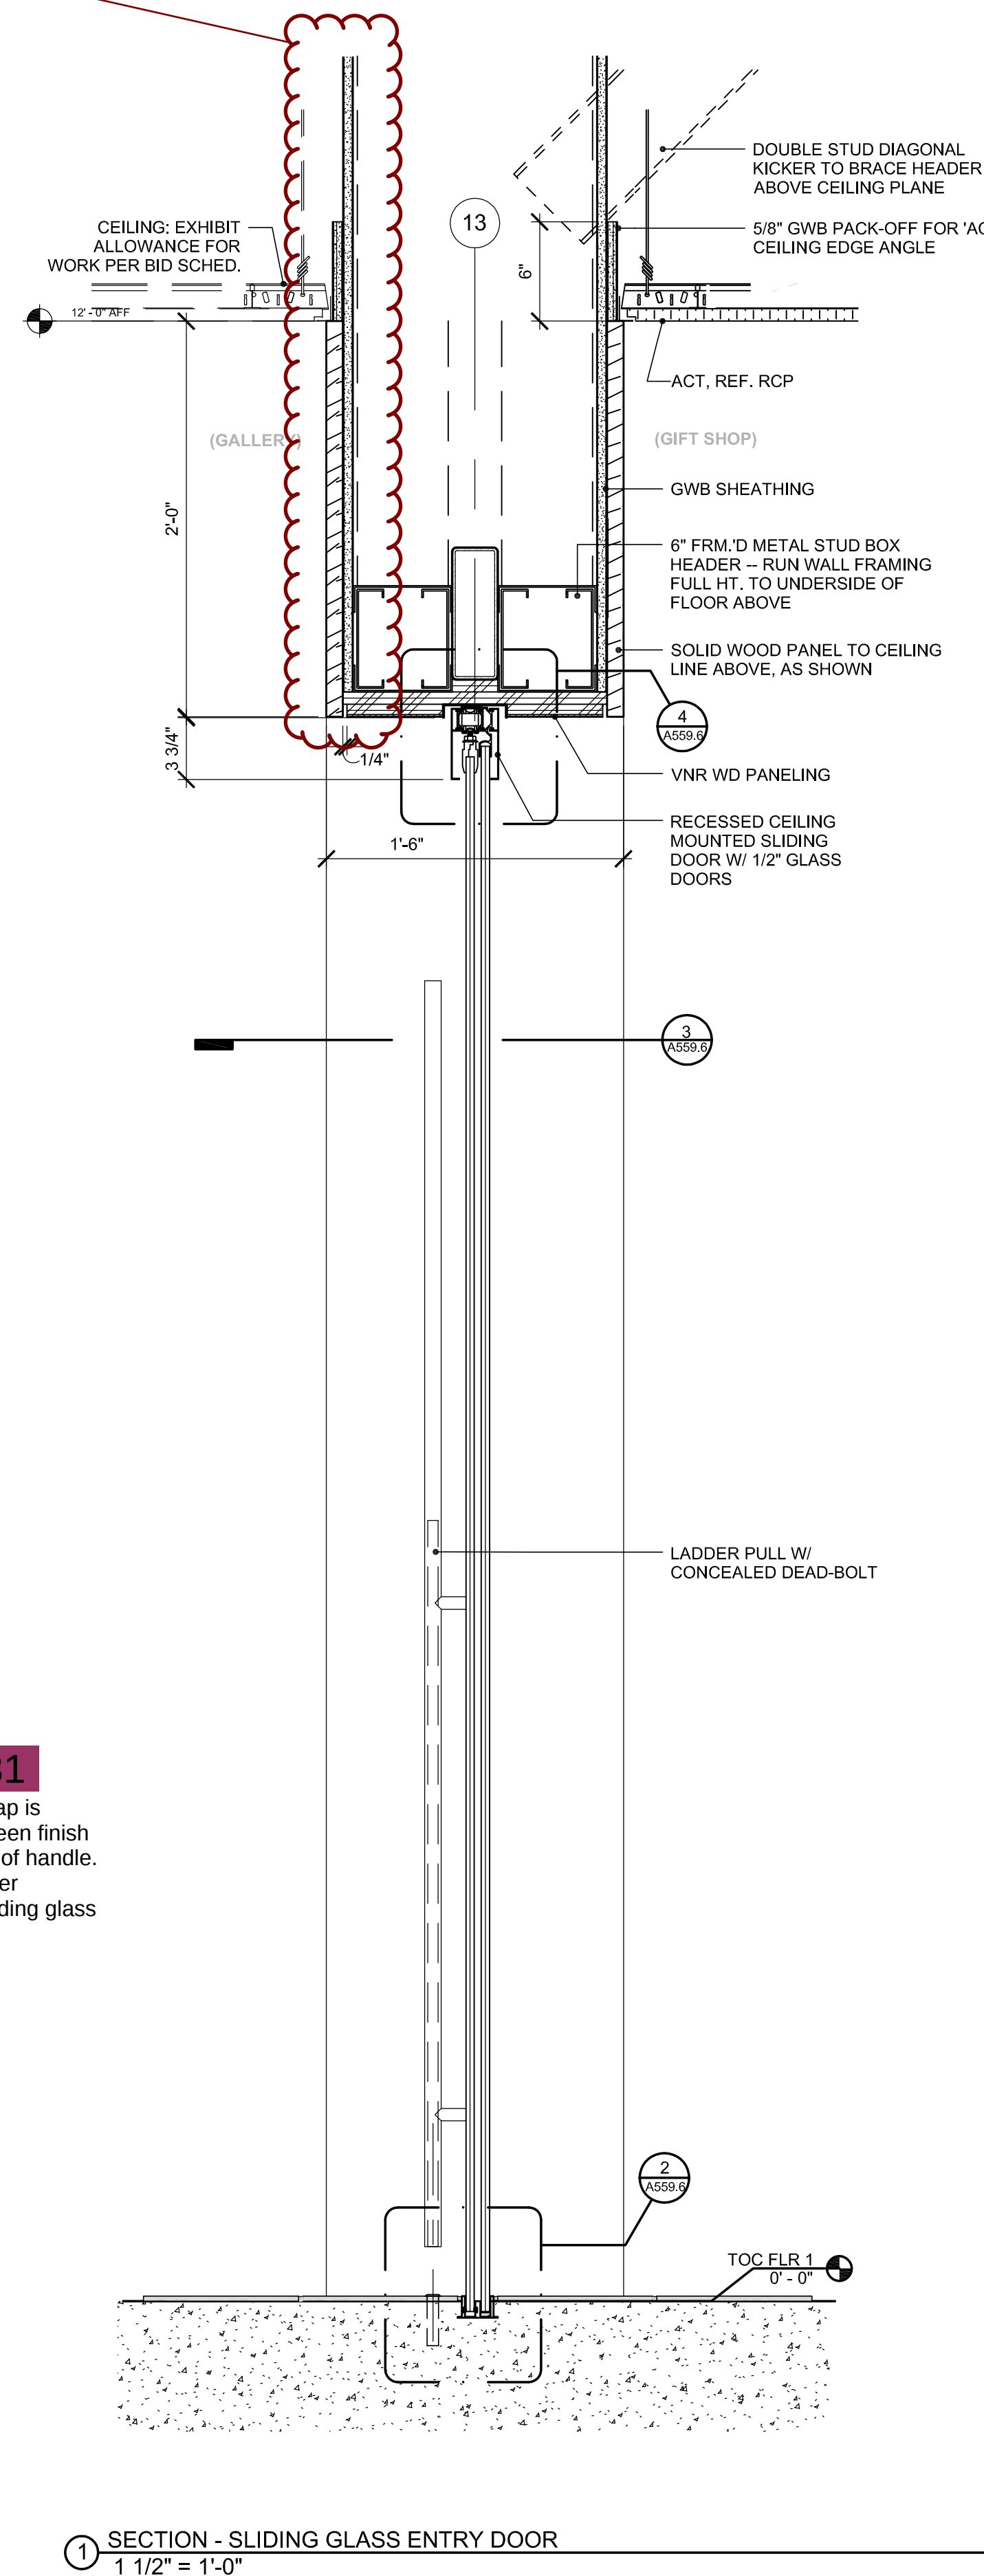

① SECTION - SLIDING GLASS ENTRY DOOR
1 1/2" = 1'-0"



SUBMITTAL TRANSMITTAL FORM

6/17/2015

TO: State of Alaska DOT&PF
DOT&PF Annex Building
2200 East 42nd Avenue
Anchorage, AK 99508

ATTN: Ms. Jennifer Pepin

Statewide Library Archives Museum DOT&PF #68816

PCL Construction Services Job #5750009

Submittal #: 06 41 00-6.1

Specification: 06 41 00 Architectural Wood Casework

Paragraph: 1.04B Reviewed By: PCL Const Srvs (Z. Lunden)

Description: Gift Shop Casework Shop Drawings

Variation Requested: No

Subcontractor: Saxton Bradley


PCL Remarks:

 CONSTRUCTION LEADERS		A/E REVIEW	
Statewide Library Archives Museum State of Alaska DOTPF Job #68816 PCL Construction Services Job #5750009		DEPARTMENT OF TRANSPORTATION AND PUBLIC FACILITIES STATEWIDE PUBLIC FACILITIES SUBMITTAL REVIEW	
Submittal #:	<u>06 41 00-6.1</u>	Date:	<u>6/17/2015</u>
Specification:	<u>06 41 00</u>	Para:	<u>1.04B</u>
Reviewed By:	<u>PCL Const Srvs (Z. Lunden)</u>		
Conclusion from PCL Review:	<u>Approved As Noted</u>		
In accordance with the contract documents:	<u>Yes</u>		
Complete Submittal for this Division:	<u>No</u>		
Variation Requested:	<u>No</u>		
THE GENERAL CONTRACTOR'S REVIEW OF THIS SUBMITTAL IN NO WAY RELIEVES THE SUBCONTRACTOR / VENDOR FROM THEIR OBLIGATION TO COMPLY WITH THE PROJECT DOCUMENTS.			
I CERTIFY THAT CONTRACT REVIEW OF THE SUBMITTAL HAS SATISFIED THE CONTRACTOR'S RESPONSIBILITIES UNDER THE CONTRACT DOCUMENTS. I HAVE VERIFIED ALL QUANTITIES, DIMENSIONS, SPECIFIED PERFORMANCE CRITERIA, INSTALLATION REQUIREMENTS, MATERIALS, CATALOG NUMBERS AND SIMILAR DATA WITH RESPECT THERETO, REVIEWED OR COORDINATED EACH SHOP DRAWING OR SAMPLE WITH OTHER SHOP DRAWINGS AND SAMPLES AND WITH THE REQUIREMENTS OF THE WORK AND THE CONTRACT DOCUMENTS.			
		☐ NO EXCEPTION TAKEN ☒ MAKE CORRECTIONS NOTED ☐ REVISE AND RESUBMIT ☐ REJECTED	
		Review of submittals indicates conformance with the design concept of the project and compliance with the information given in the Contract Documents and shall not relieve the CONTRACTOR of the responsibility for compliance with the requirement of the Contract Documents; or for errors, dimensions, and quantities unless specific exception is requested and approved on the submittal.	
		DEPARTMENT's review shall not extend to the means, methods, techniques, sequences or procedures of construction or to safety precautions or programs incident thereto. The review and approval of a separate item as such will not indicate approval of the assembly in which the item functions.	
		SIGNED: <u>David Popiel</u> DATE: <u>7/21/15</u>	
		Notes - See attached submittal for comments - Note request for RFI regarding transparent book enclosure	


PCL CONSTRUCTION SERVICES, INC.

1400 W. Benson Blvd; Ste. 510, Anchorage, Alaska 99503
Telephone: (907) 243-7252 ☎ Fax: (907) 272-1905

General Note:
1) Wood trim to match surrounding wood

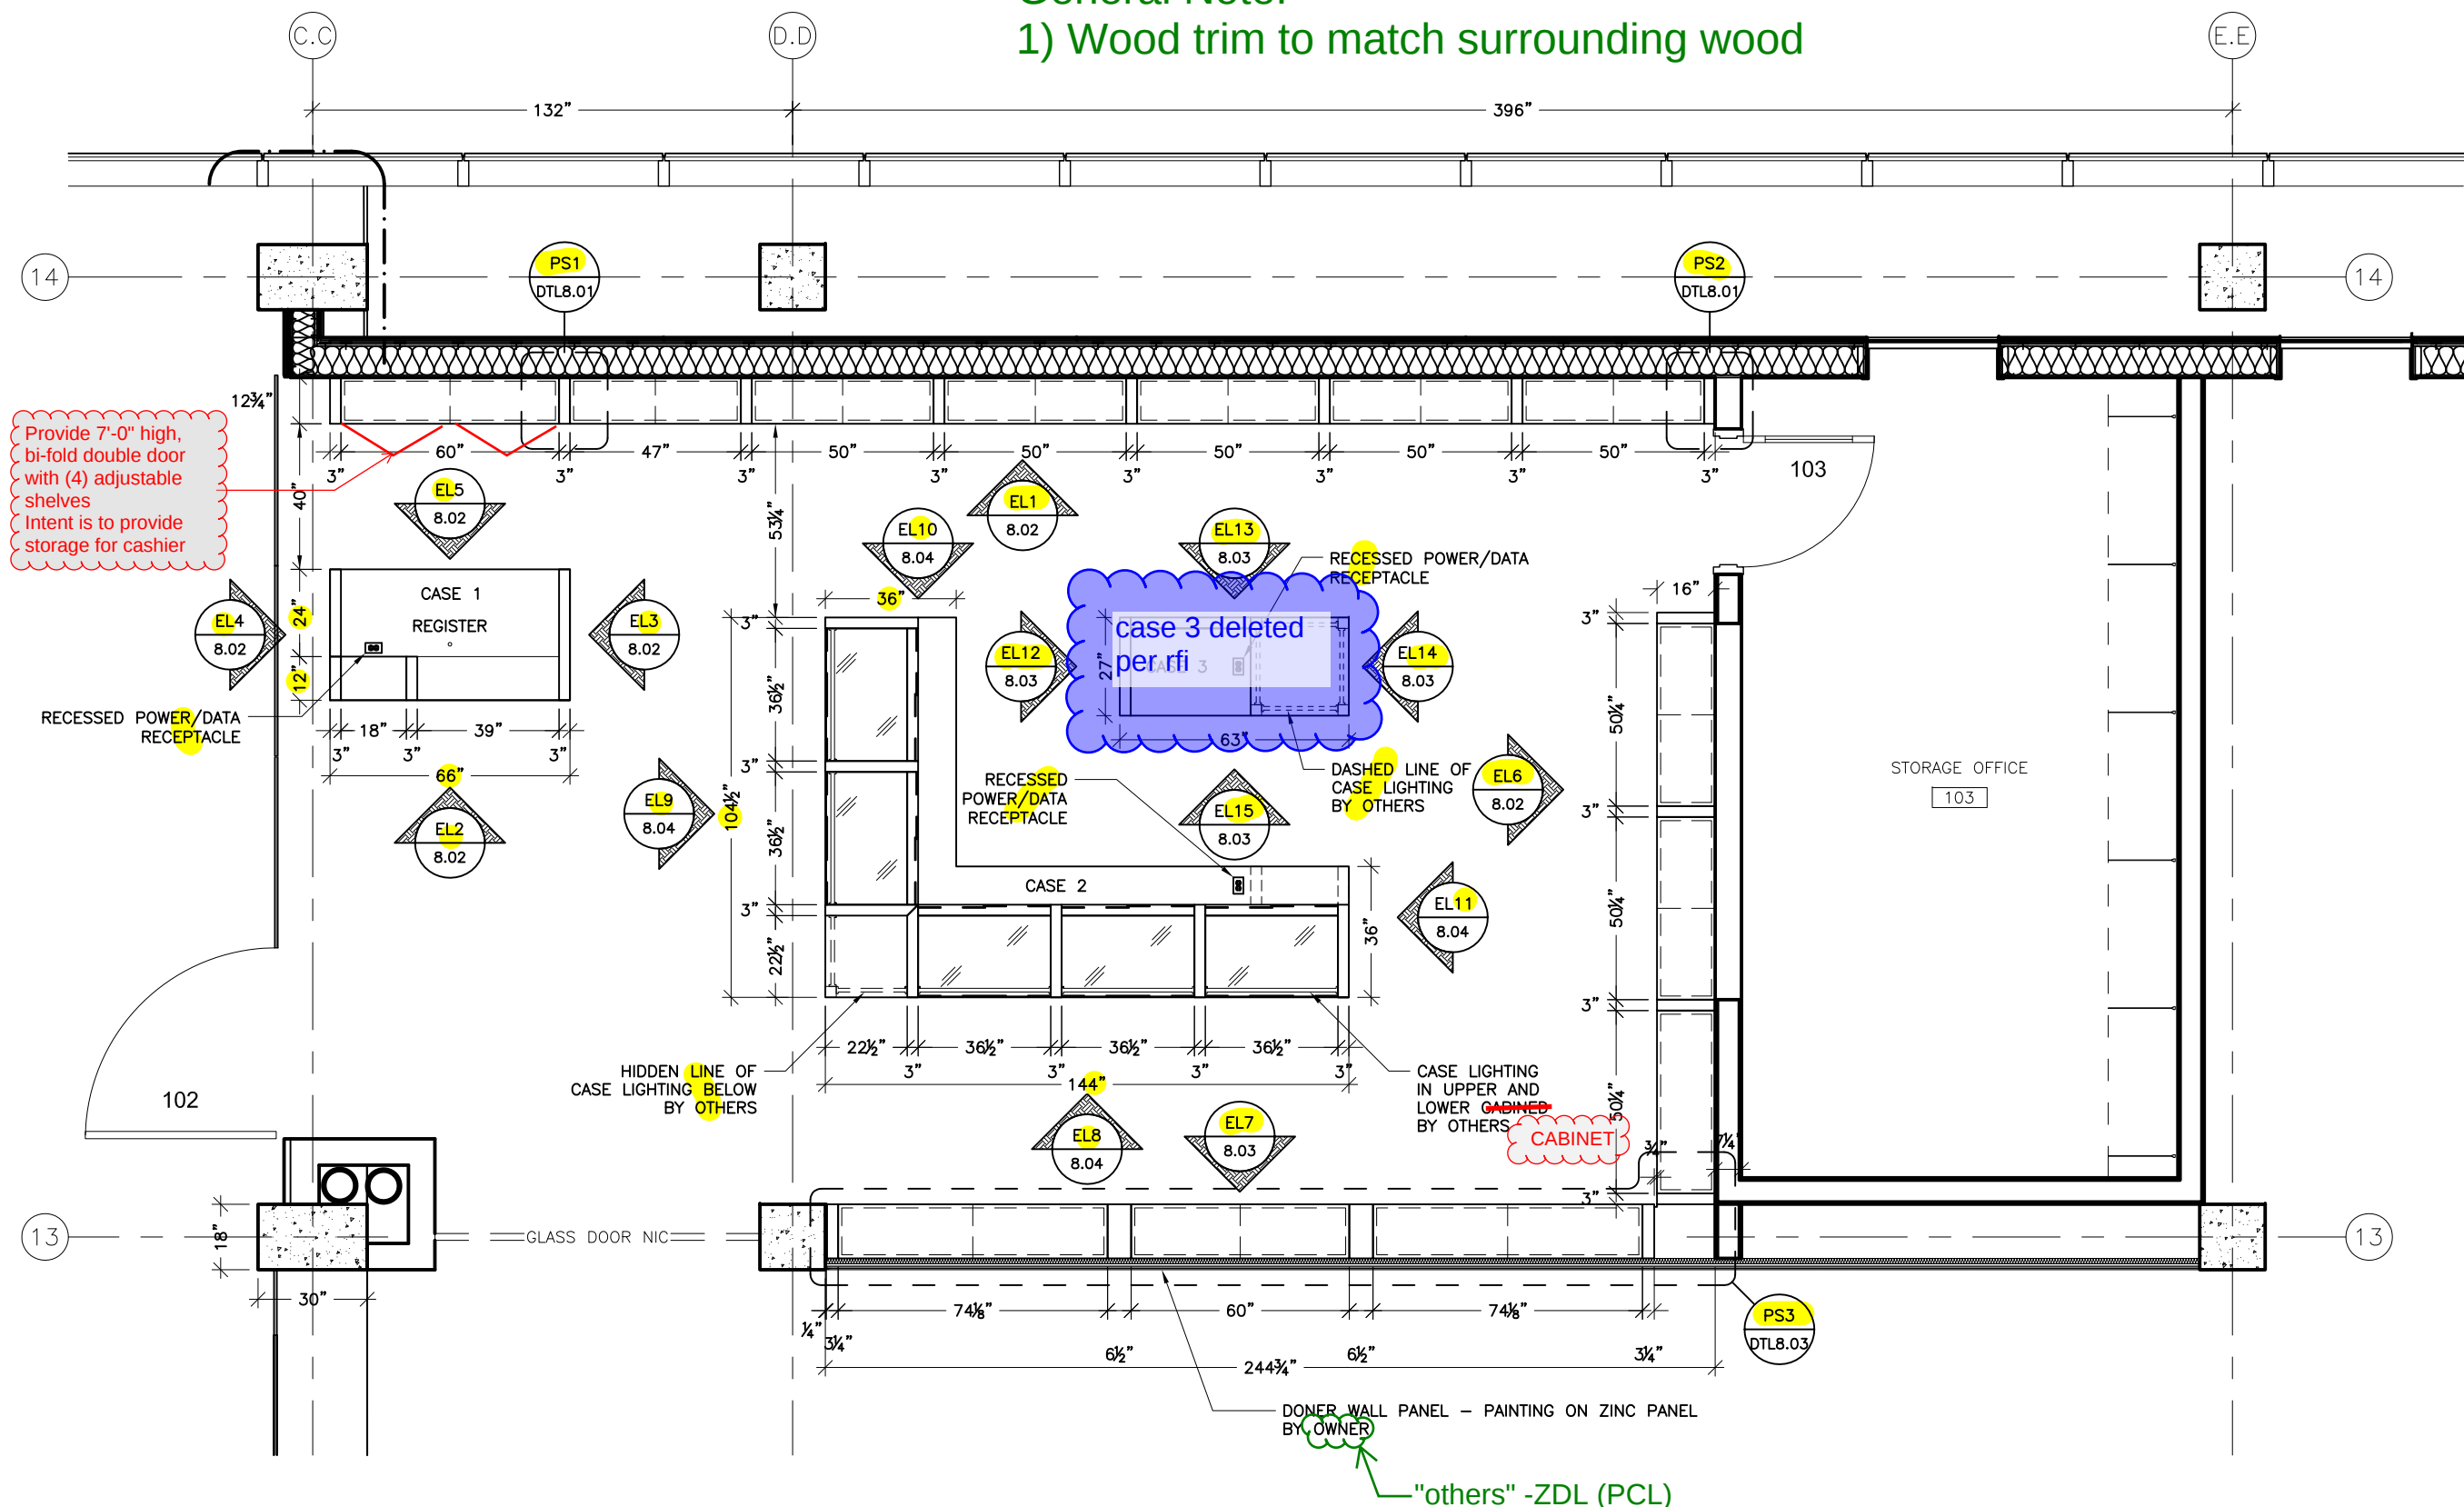

SCALE	
as noted	
DATE	DRAFTER
01/12/15	KSS
REVISIONS	
02/17/15 KSS	
06/12/15 KSS	
Rev3	
Rev4:	
Rev5:	
Rev6:	
FILE NAME	
Delta 2	
JOB #	
3592	
SHEET	
8.01	

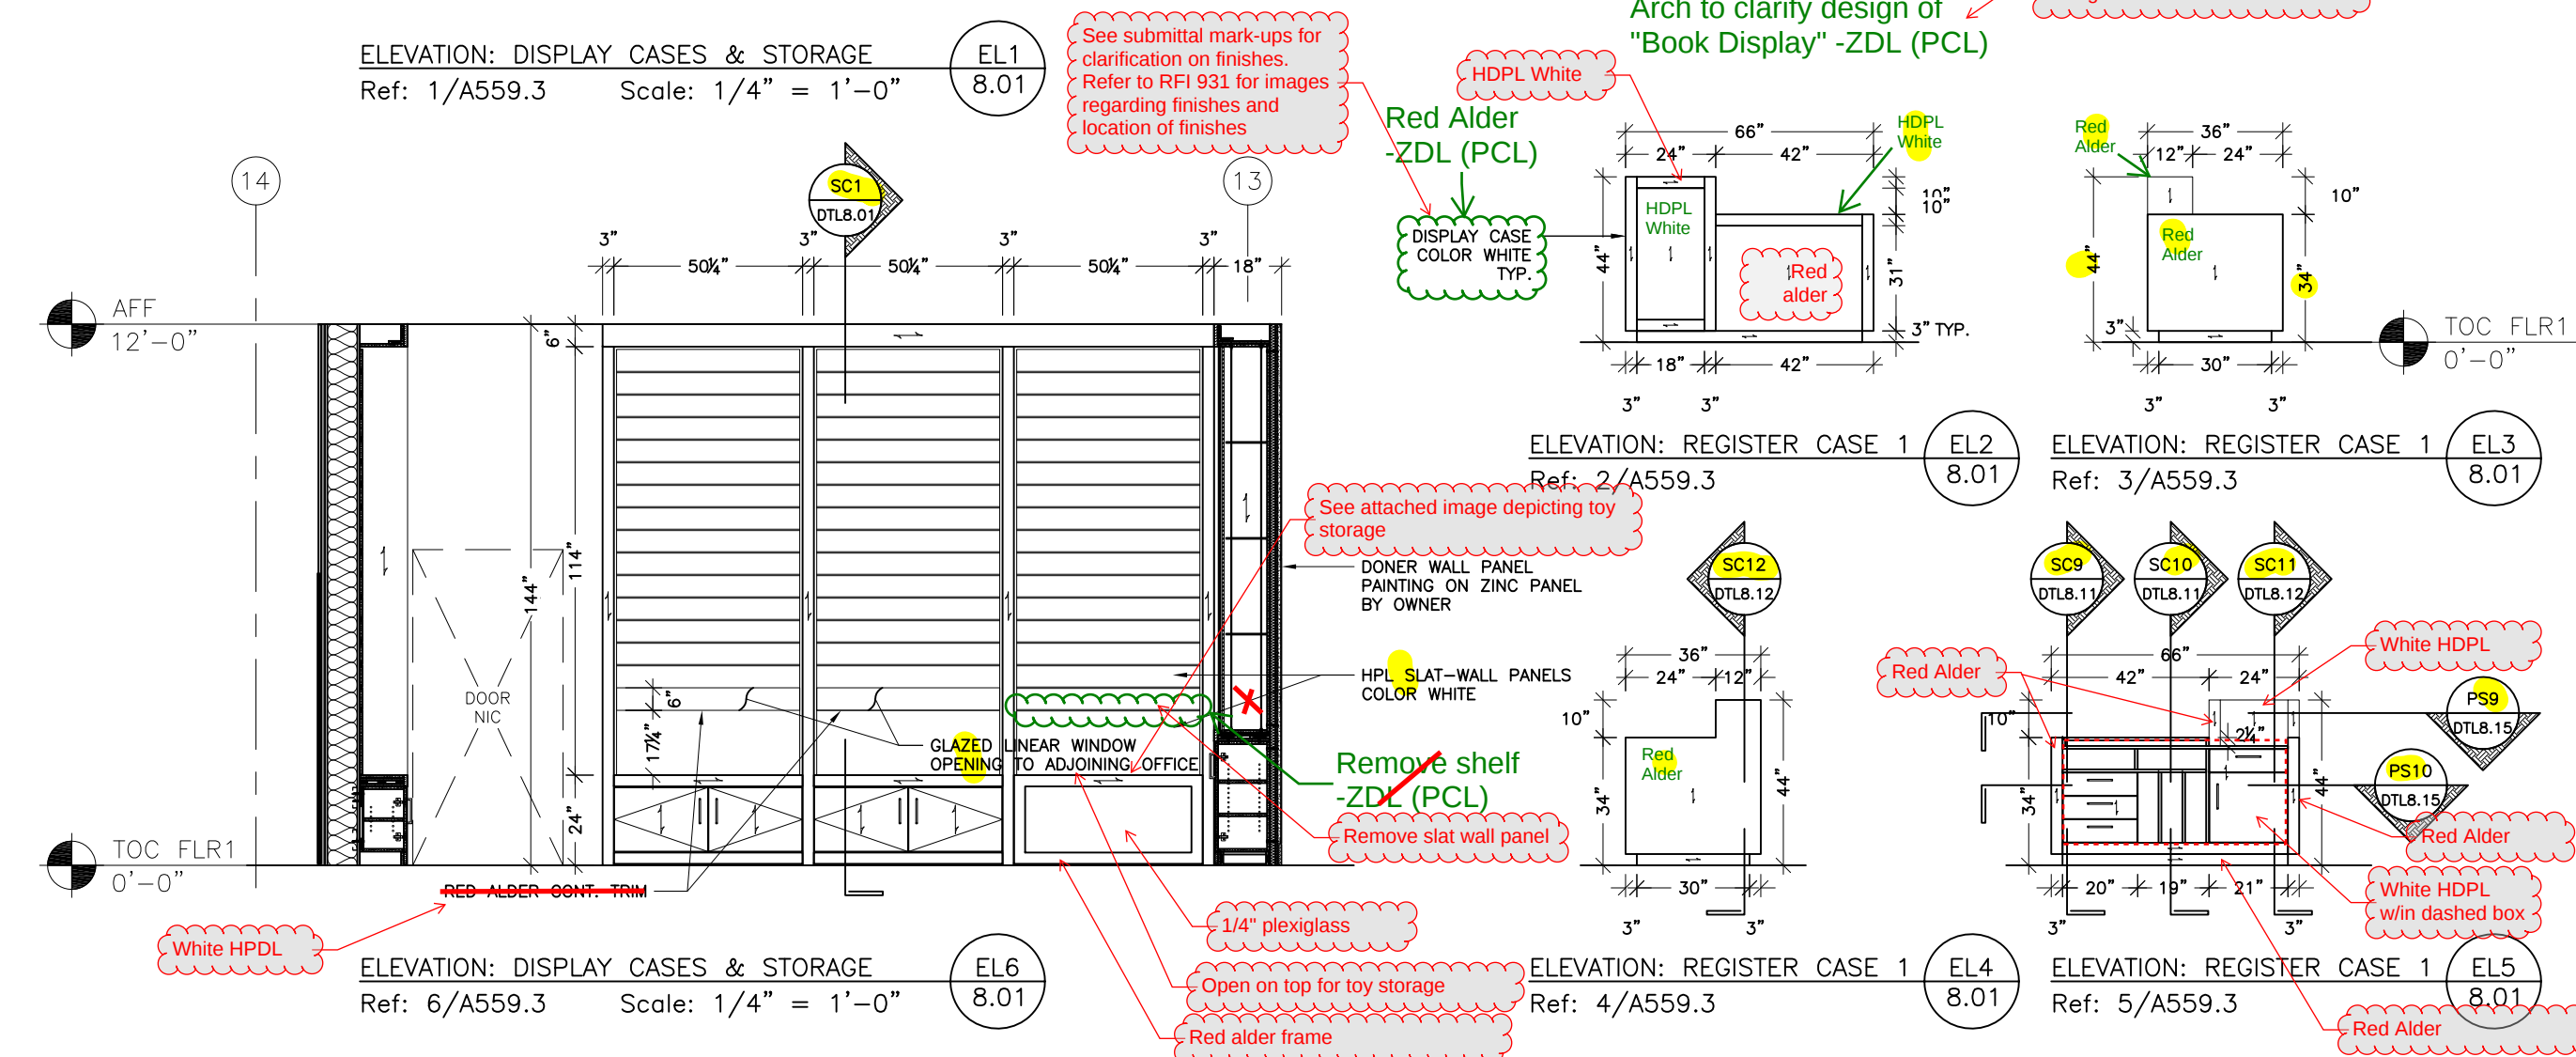

Juneau SLAM
395 Whittier Street
Juneau, Alaska 99801-1718

GIFT CLUB

SCALE
as noted

DATE	DRAFTER
01/12/15	KSS

REVISIONS
02/17/15 KSS
06/12/15 KSS

Rev3
Rev4:
Rev5:
Rev6:


FILE NAME
Delta 2

JOB #
3592

SHEET

002



8.02

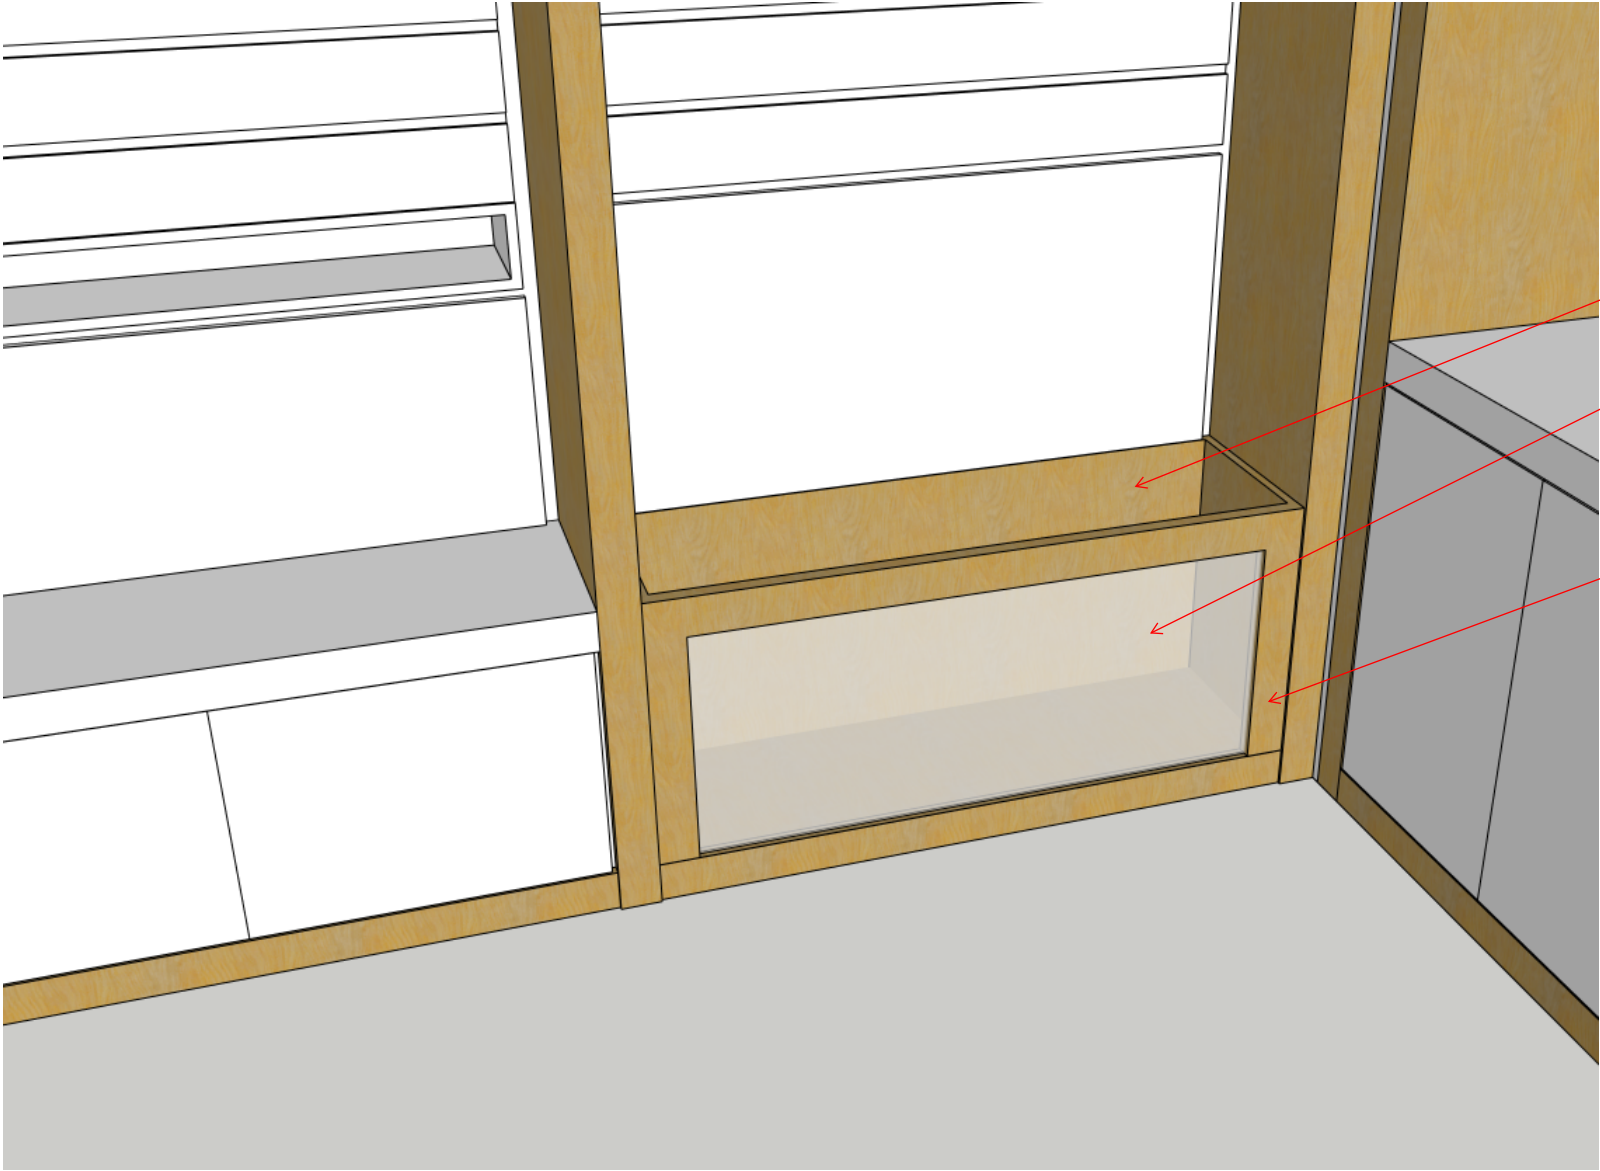

Toy storage open at top

1/4" plexiglass


3" wide Red Alder frame

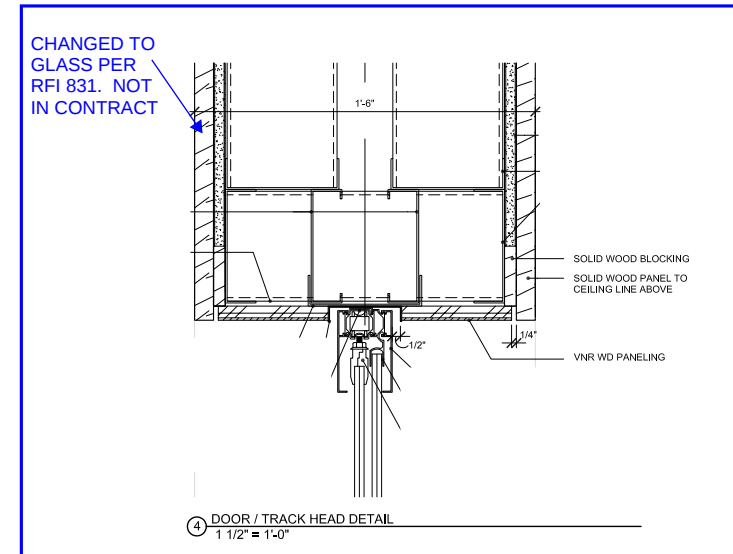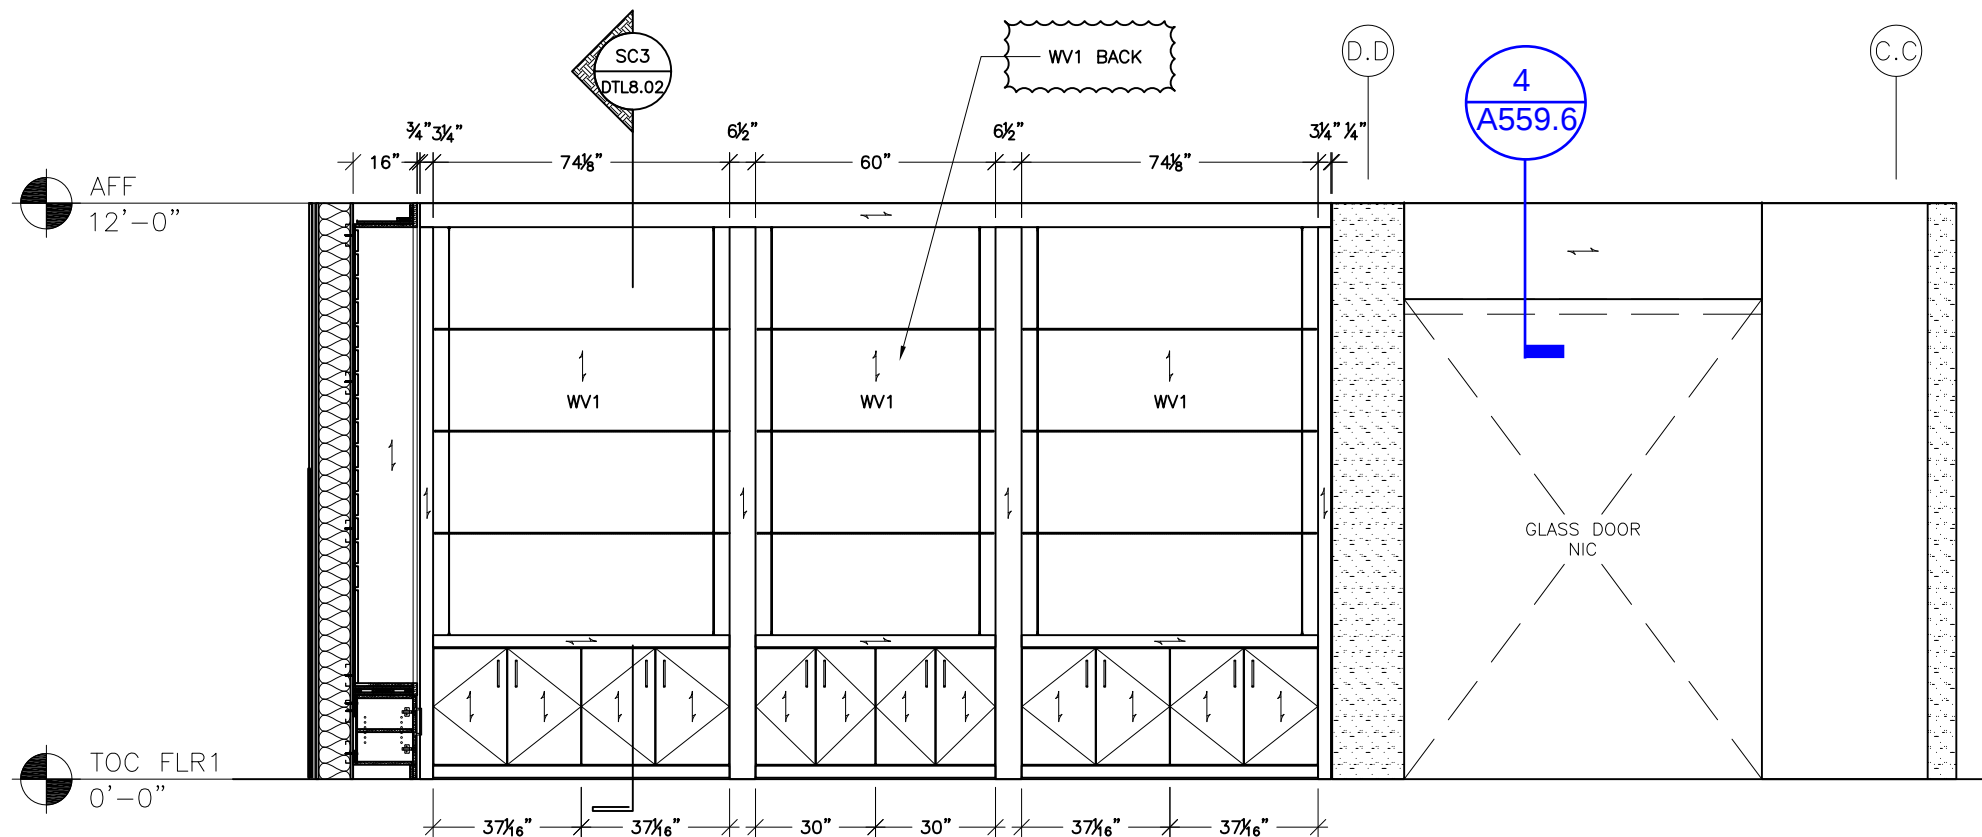

SECTION 4 ON SHEET A559.6

ELEVATION: DISPLAY CASES & STORAGE
Ref: 7/A559.3 Scale: 1/4" = 1'-0"

EL7
8.01

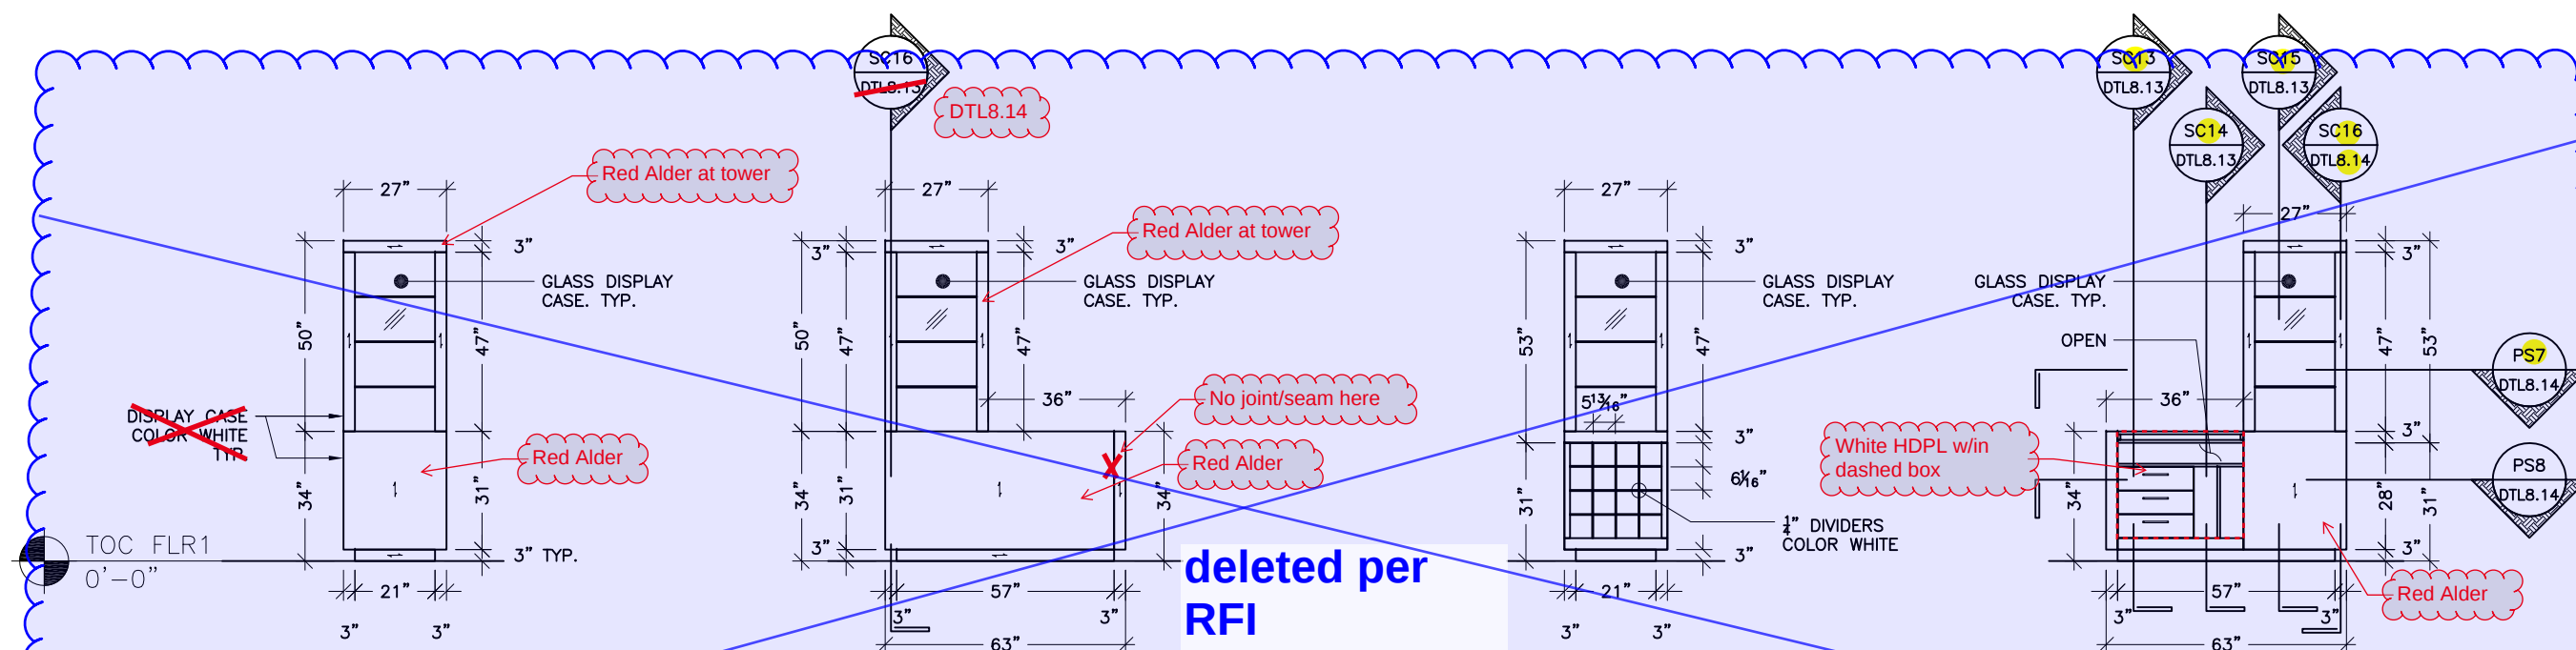

ELEVATION: GIFT SHOP CASE 3
Ref: 5/A559.4

EL12
8.01

ELEVATION: GIFT SHOP CASE 3
Ref: 6/A559.4

EL13
8.01

ELEVATION: GIFT SHOP CASE 3
Ref: 7/A559.4

EL14
8.01

ELEVATION: GIFT SHOP CASE 3
Ref: 8/A559.4

EL15
8.01

Juneau SLAM
395 Whittier Street
Juneau, Alaska 99801-1718


GIFT SHOP

SCALE	
as noted	
DATE	DRAFTER
01/12/15	KSS
REVISIONS	
02/17/15	KSS
06/12/15	KSS
Rev3	
Rev4:	
Rev5:	
Rev6:	
FILE NAME	
Delta 2	
JOB #	
3592	
SHEET	


8.03

801 SW 16th Street
Renton, WA 98057
phone: 800.643.3512
fax: 425.282.1944




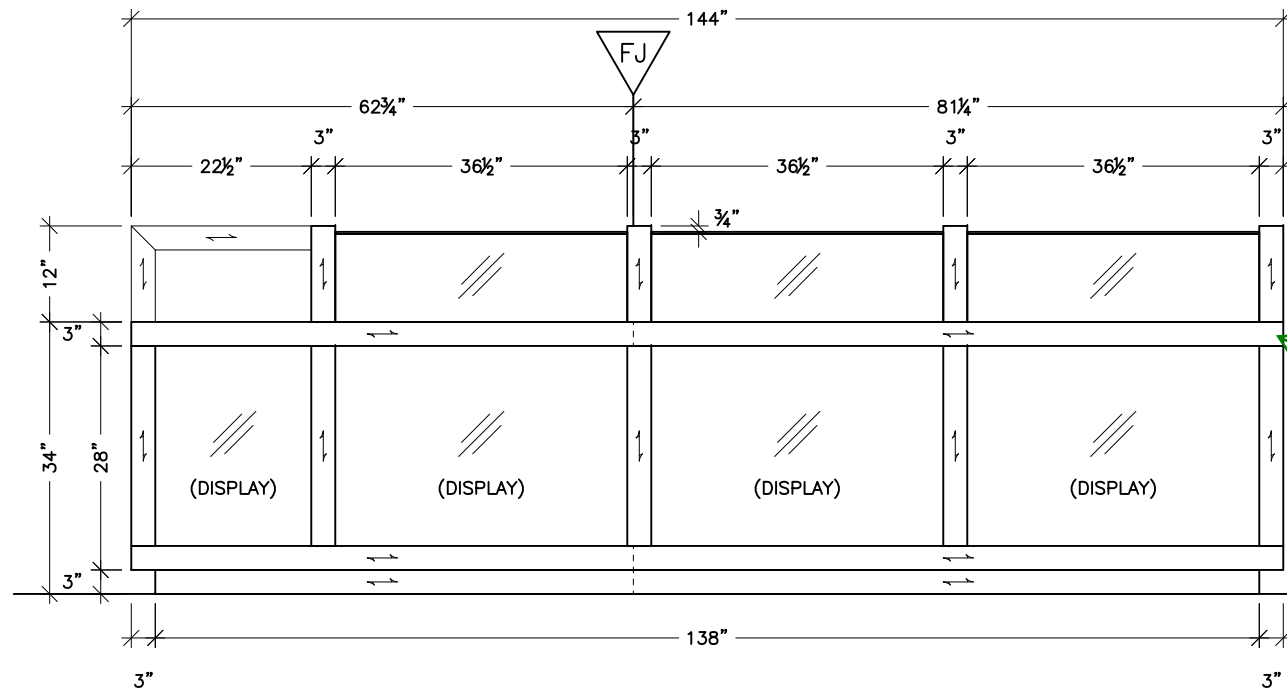


ELEVATION: GIFT SHOP DISPLAY CASE 2 **EL8**
Ref: 1/A559.4 8.01

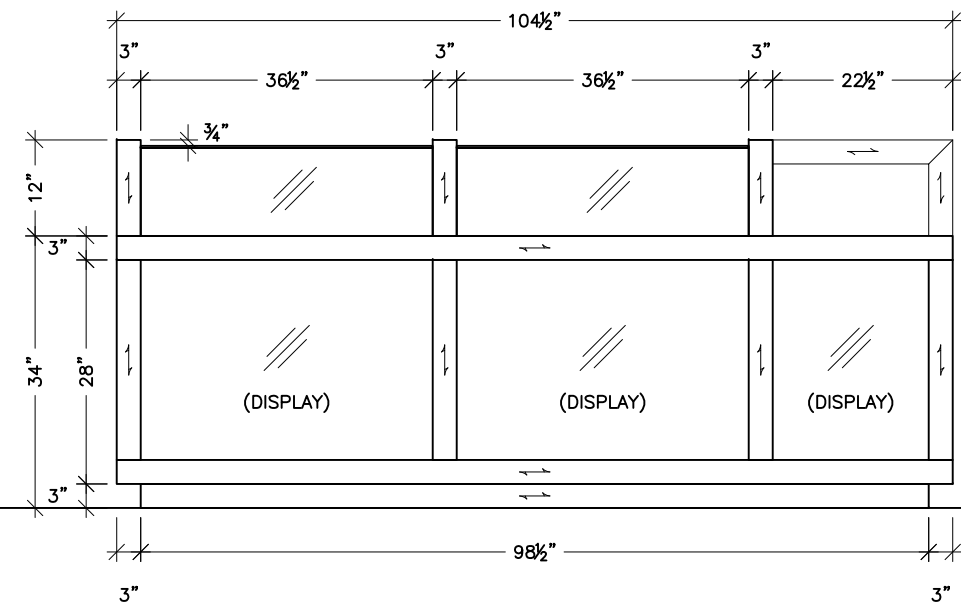

ELEVATION: GIFT SHOP DISPLAY CASE 2 **EL9**
Ref: 2/A559.4 8.01

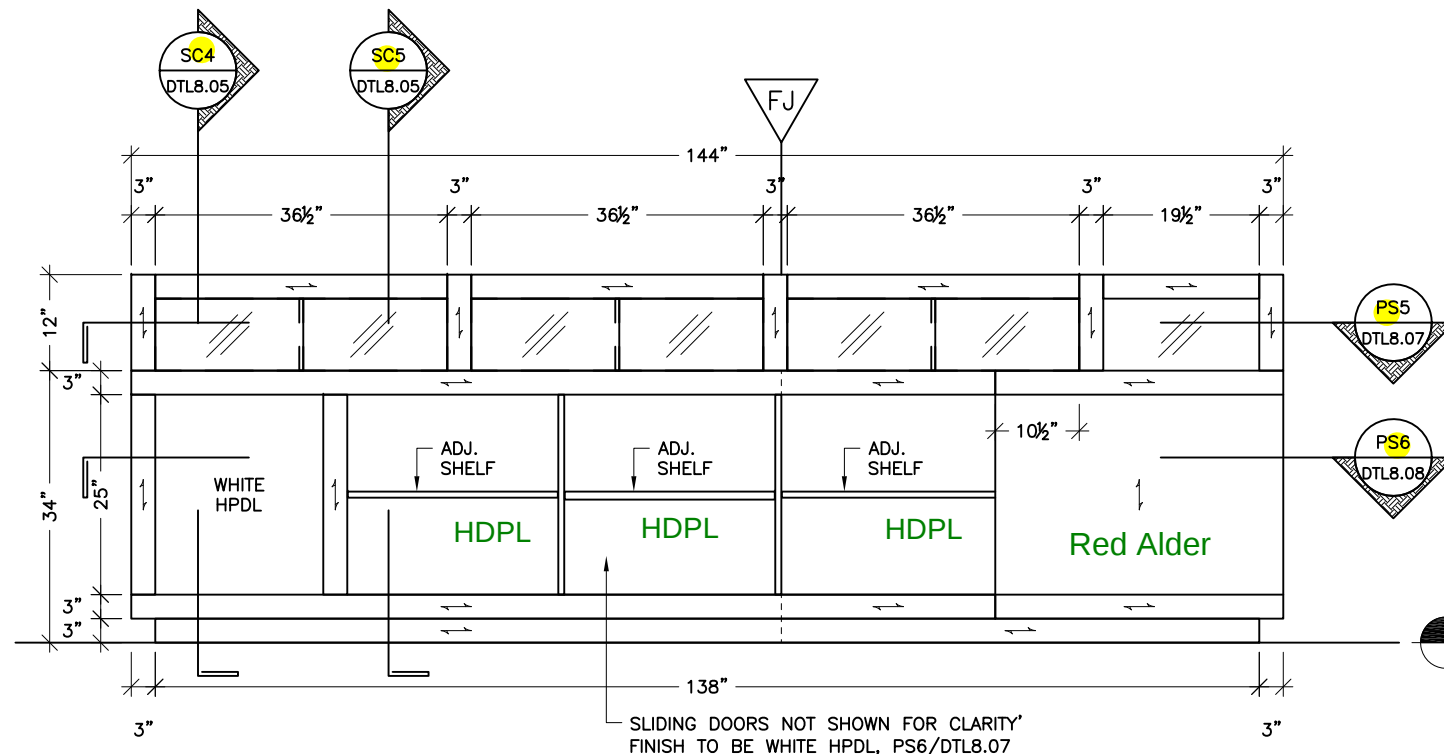

ELEVATION: GIFT SHOP DISPLAY CASE 2 **EL10**
Ref: 3/A559.4 8.01

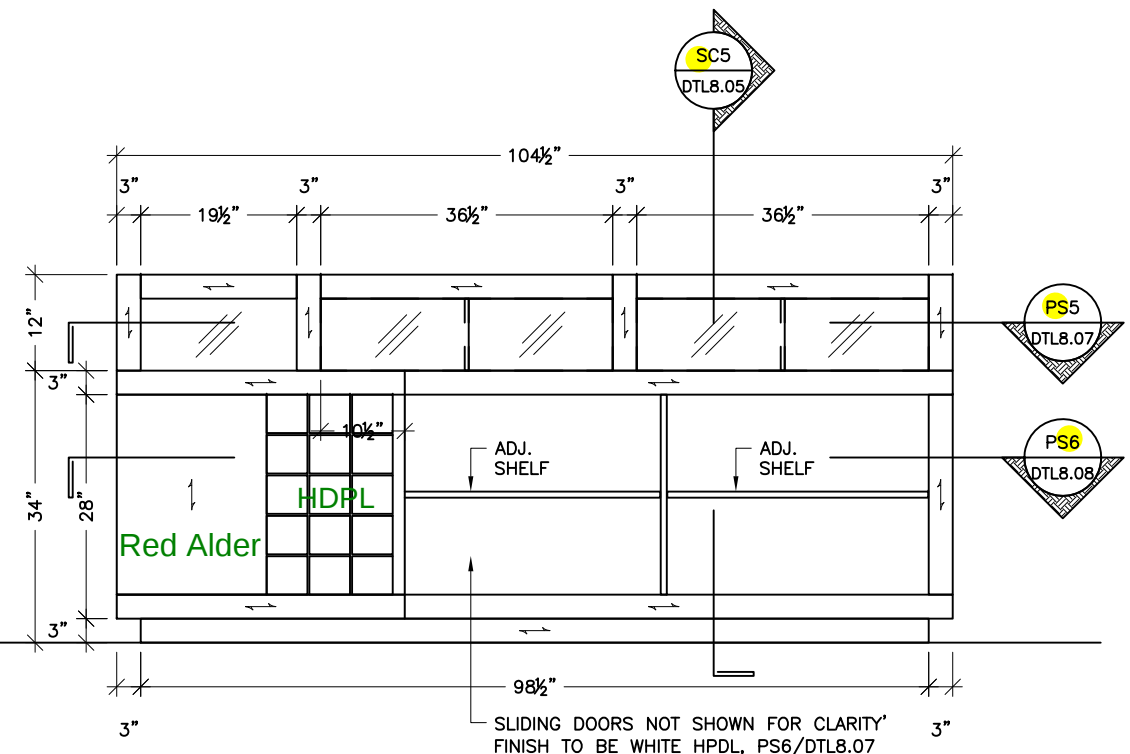

ELEVATION: GIFT SHOP DISPLAY CASE 2 **EL11**
Ref: 4/A559.4 8.01

801 SW 16th Street
Renton, WA 98057
phone: 800.643.3512
fax: 425.282.1944




Juneau SLAM
395 Whittier Street
Juneau, Alaska 99801-1718

GIFT SHOP


SCALE	
as noted	
DATE	DRAFTER
01/12/15	KSS
REVISIONS	
02/17/15	KSS
06/12/15	KSS
Rev3	
Rev4:	
Rev5:	
Rev6:	
FILE NAME	
Delta 2	
JOB #	
3592	
SHEET	

8.04

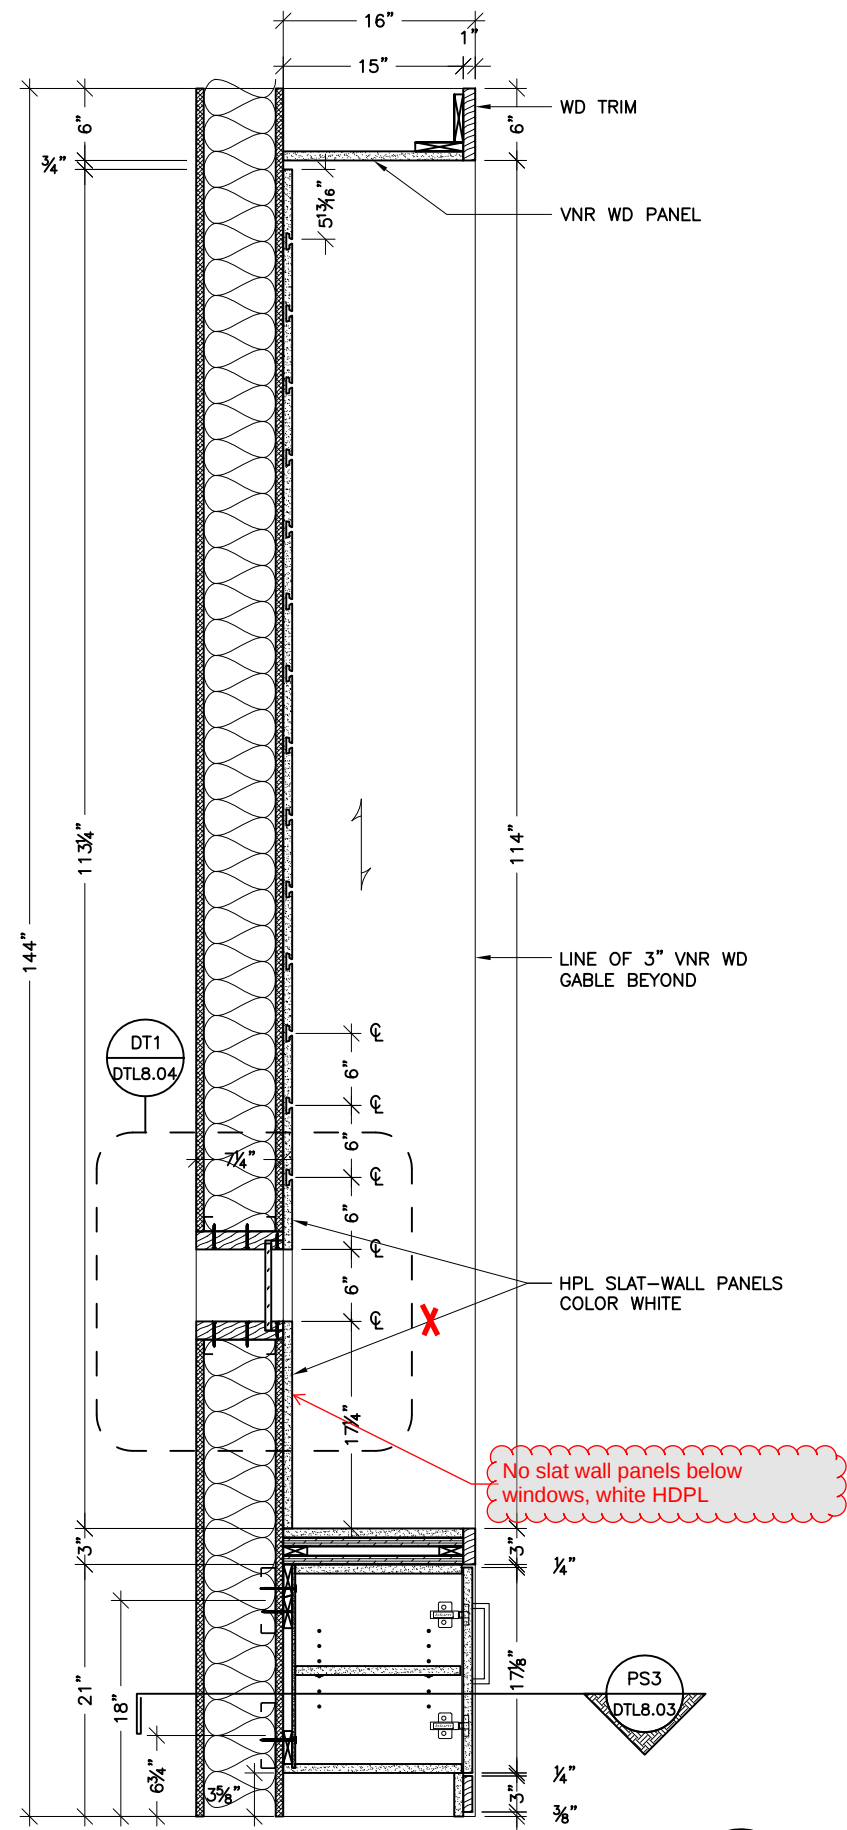


SECTION: DISPLAY CASES & STORAGE
Ref: 2/SK-RFI897-1 Scale: 3/4" = 1'-0"

SC1
8.02

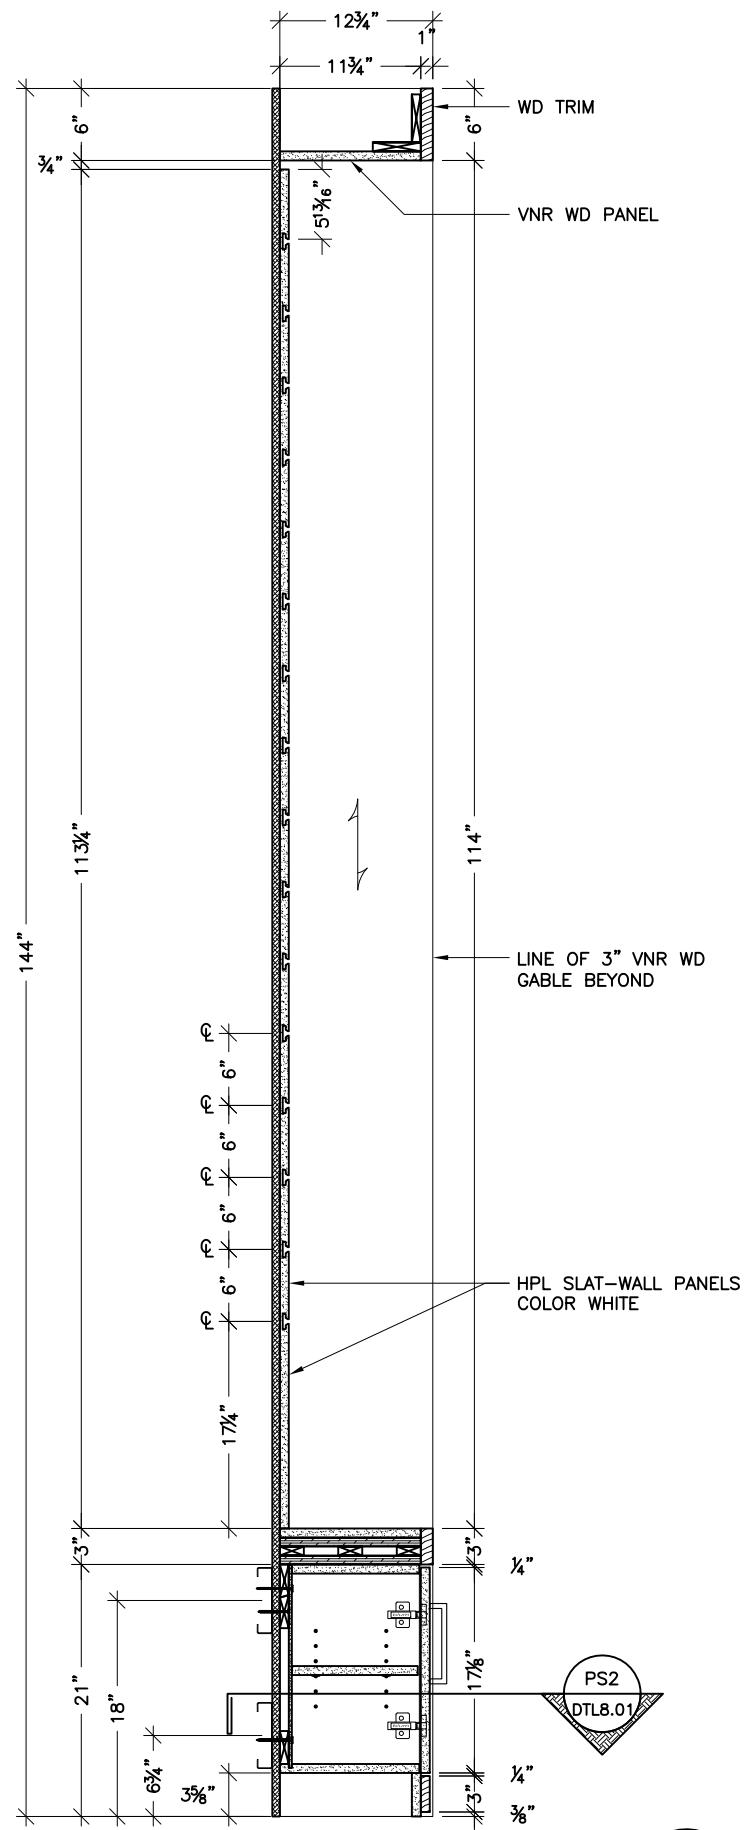

SECTION: DISPLAY CASES & STORAGE
Ref: 2/A559.5 Scale: 3/4" = 1'-0"

SC2
8.02

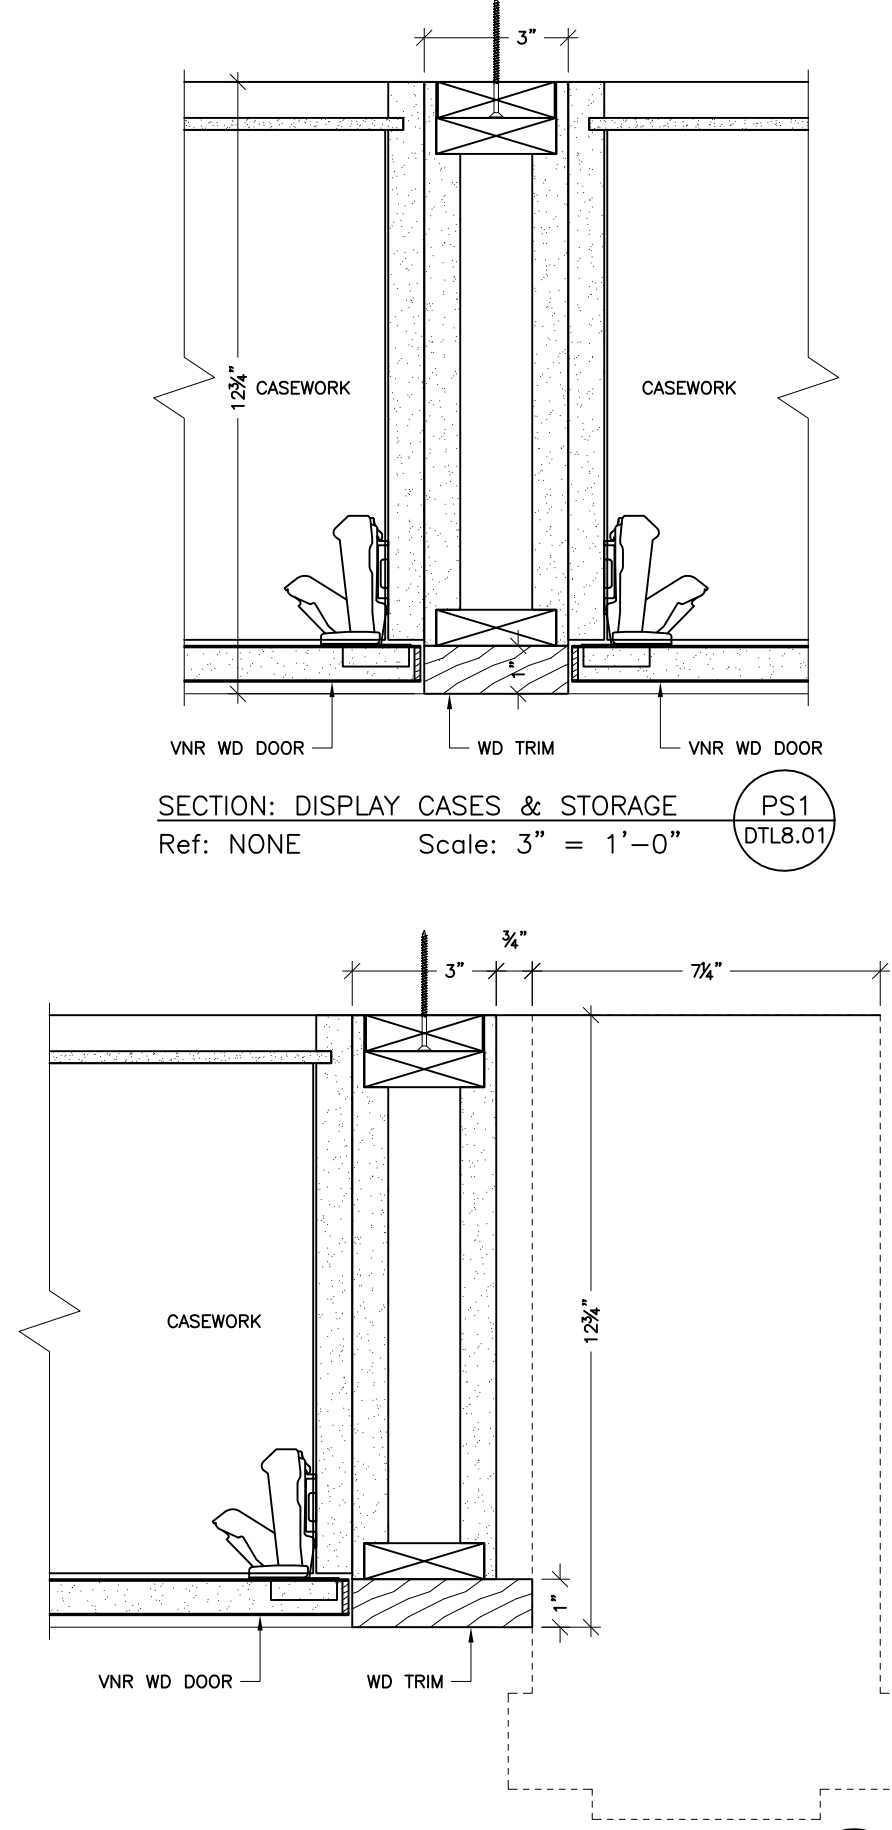

SECTION: DISPLAY CASES & STORAGE
Ref: 6/A559.5 Scale: 3" = 1'-0"

PS2
DTL8.01

801 SW 16th Street
Renton, WA 98057
phone: 800.643.3512
fax: 425.282.1944





Juneau SLAM
395 Whittier Street
Juneau, Alaska 99801-1718

NOTES
GIFT SHOP

SCALE	
as noted	
DATE	DRAFTER
01/12/15	KSS
REVISIONS	
02/17/15	KSS
06/12/15	KSS
Rev3	
Rev4:	
Rev5:	
Rev6:	
FILE NAME	
Delta 2	
JOB #	
3592	
SHEET	

DTL8.01

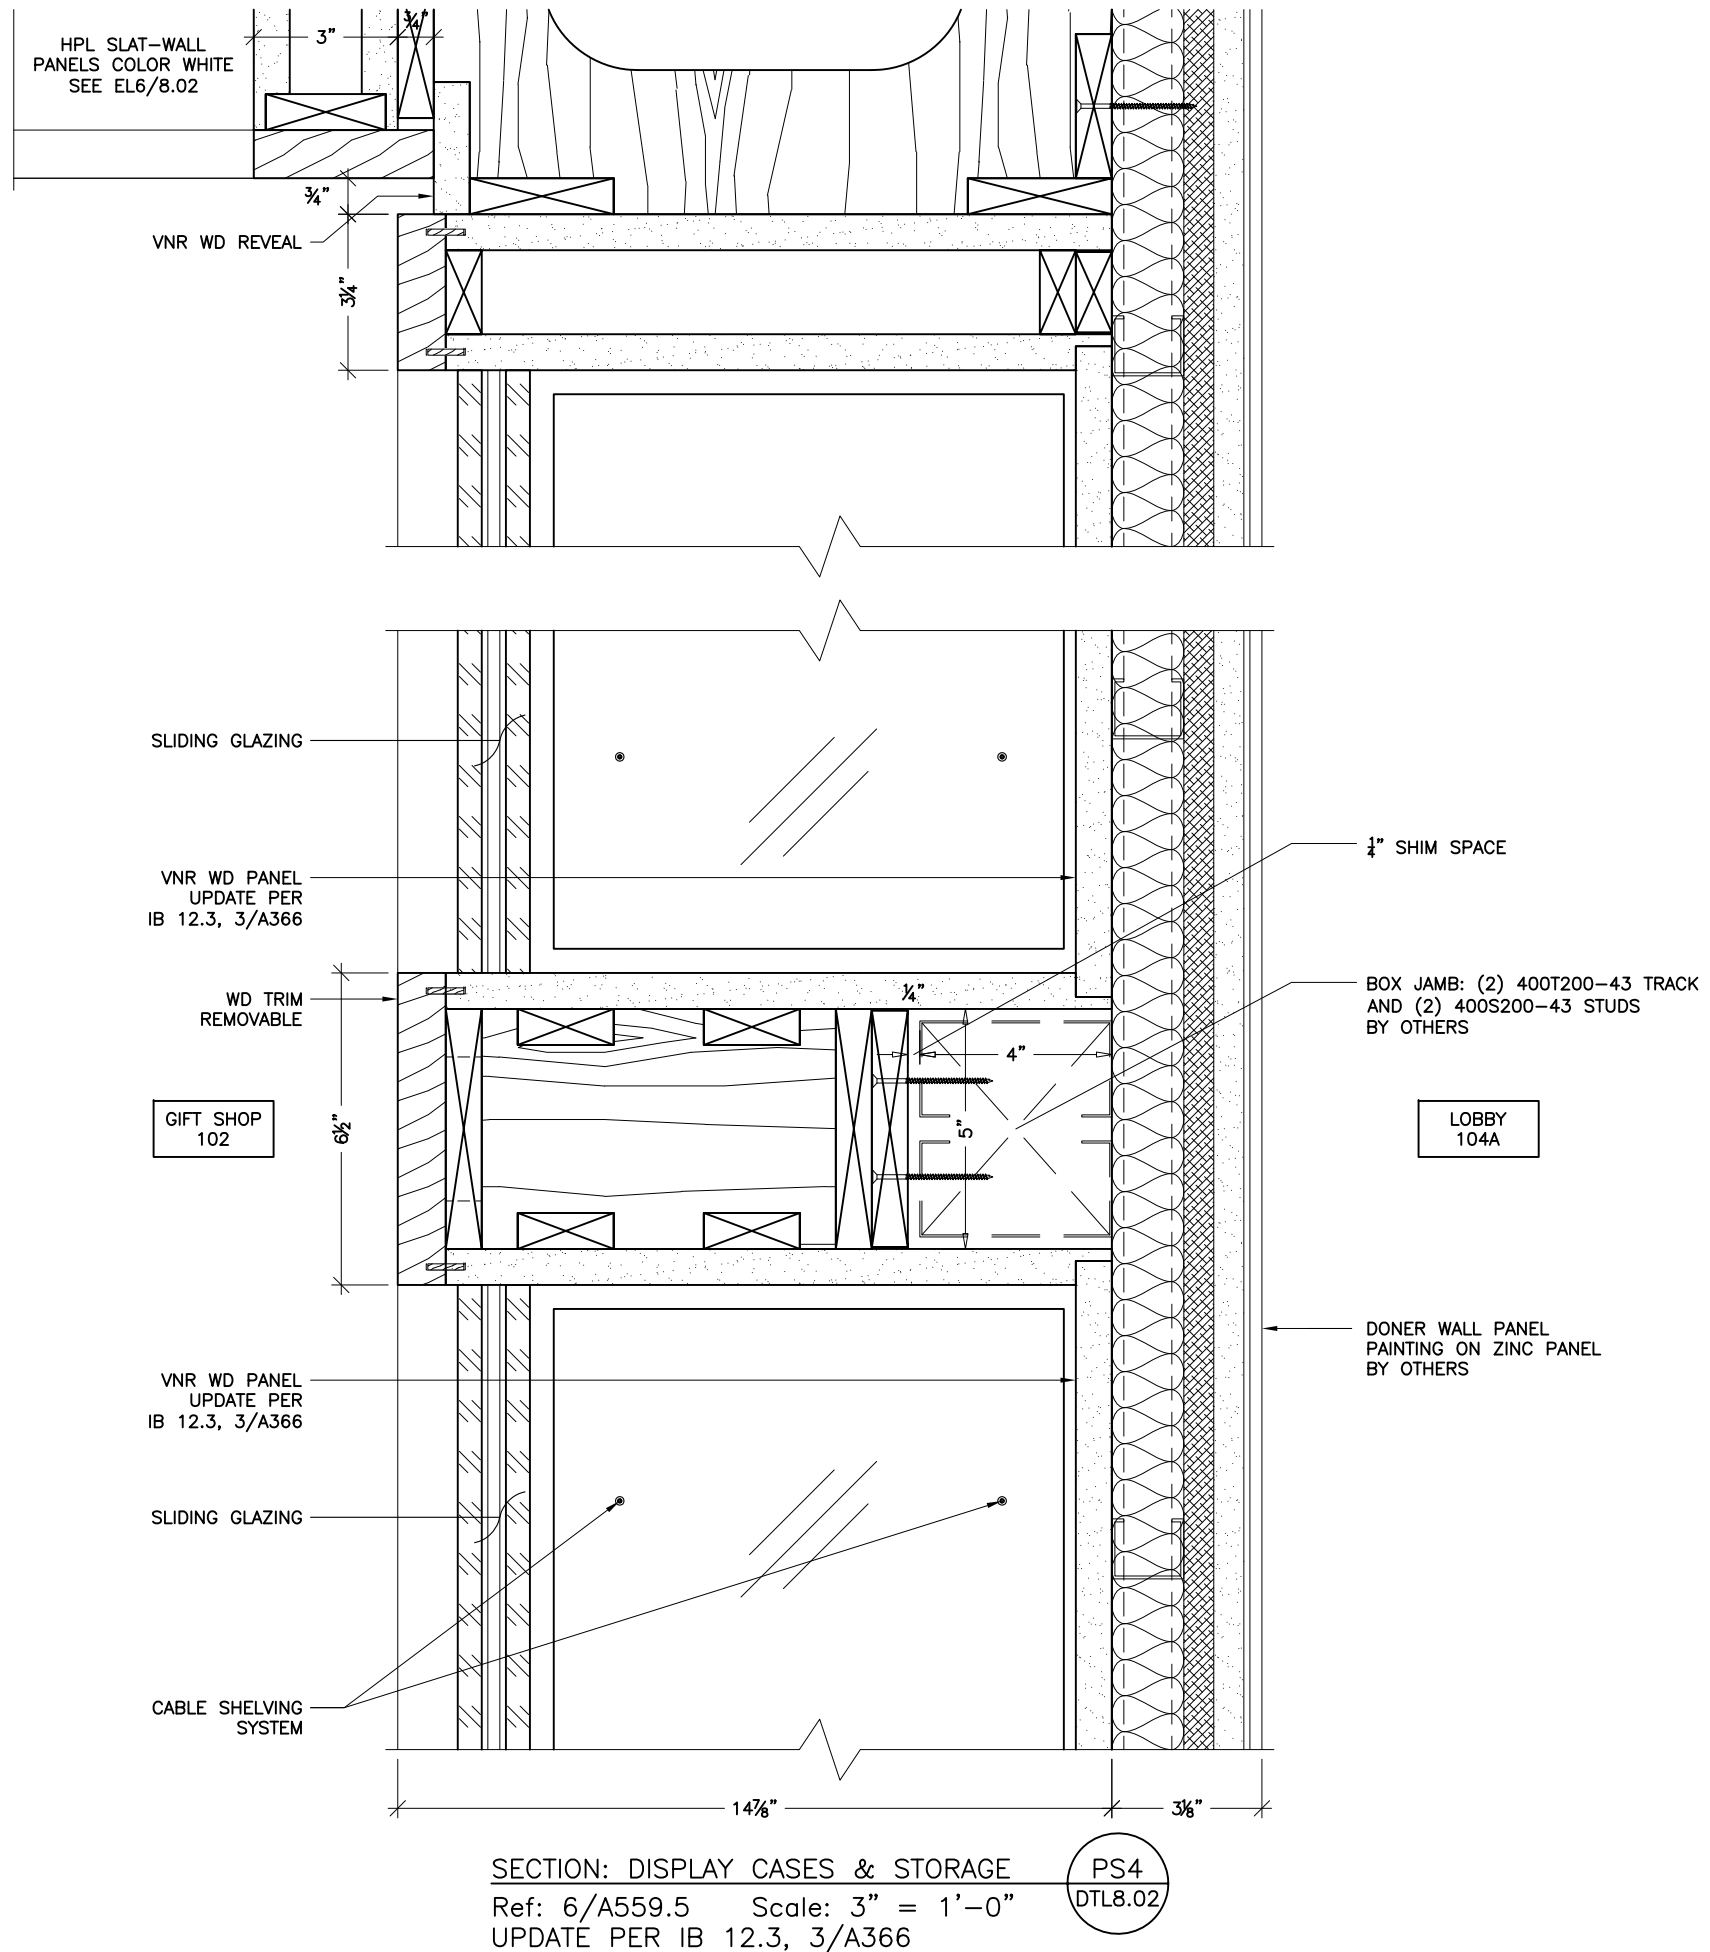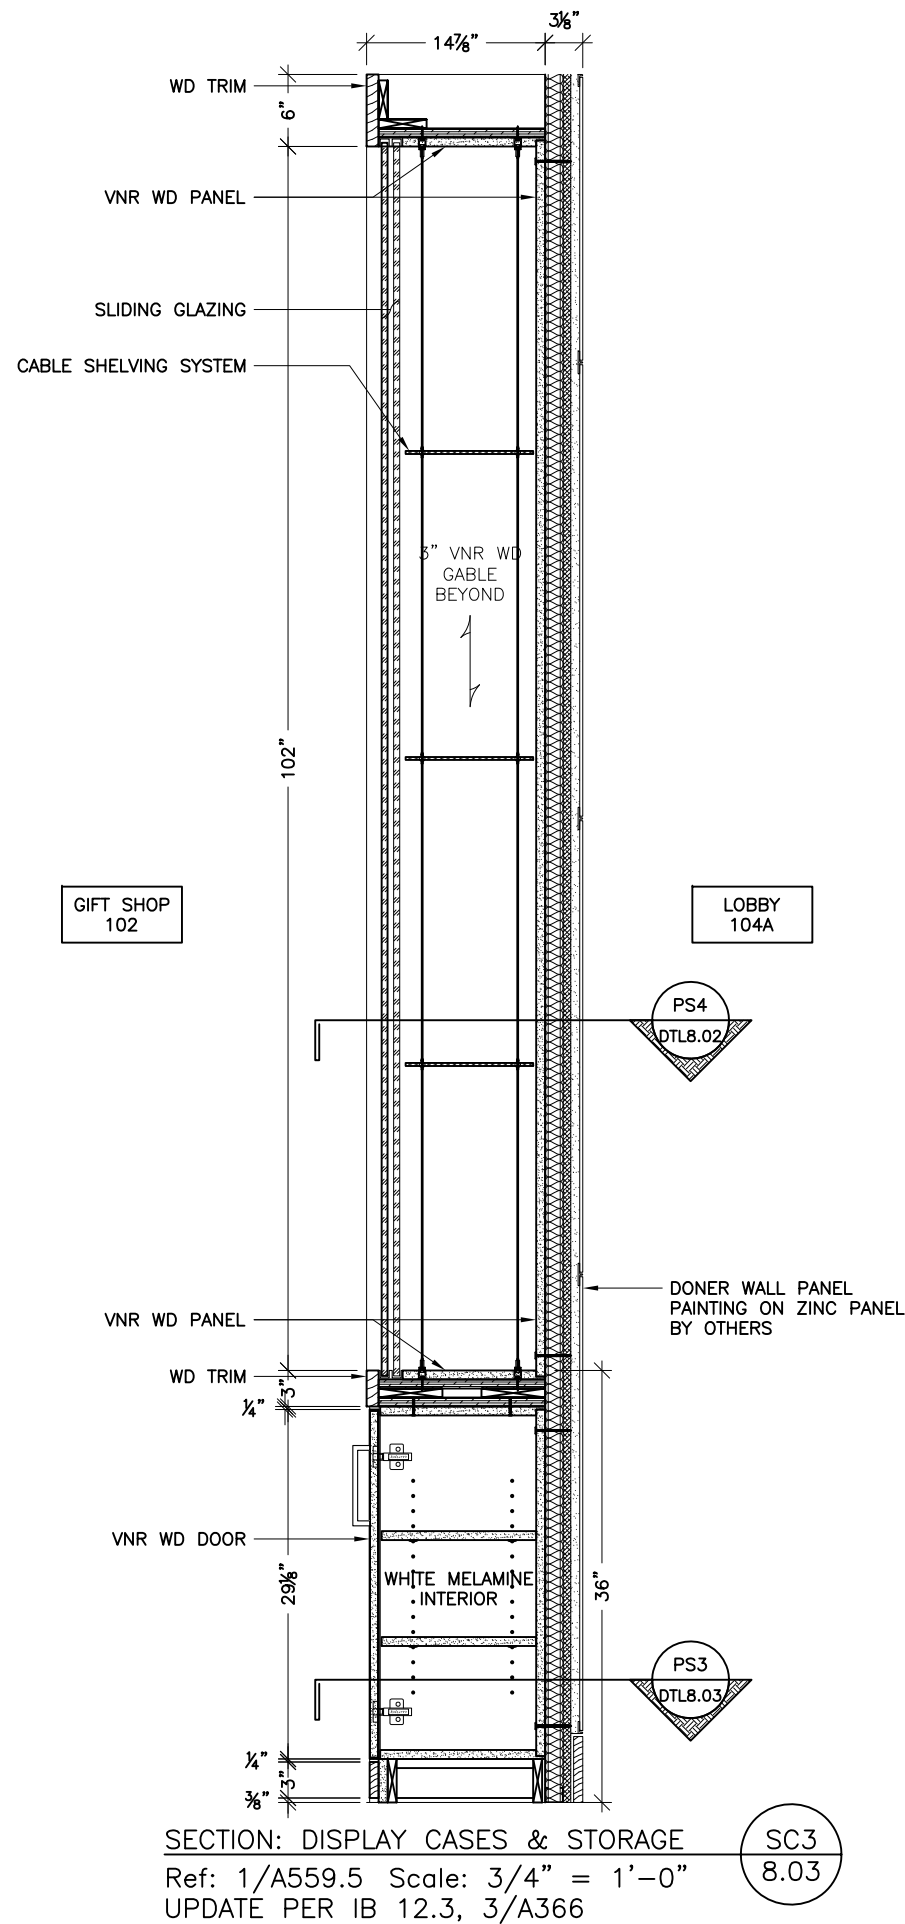


801 SW 16th Street
Renton, WA 98057
phone: 800.643.3512
fax: 425.282.1944



Juneau SLAM
395 Whittier Street
Juneau, Alaska 99801-1718

SCALE	
as noted	
DATE	DRAFTER
01/12/15	KSS
REVISIONS	
02/17/15	KSS
06/12/15	KSS
Rev3	
Rev4:	
Rev5:	
Rev6:	
FILE NAME	
Delta 2	
JOB #	
3592	
SHEET	

DTL8.02

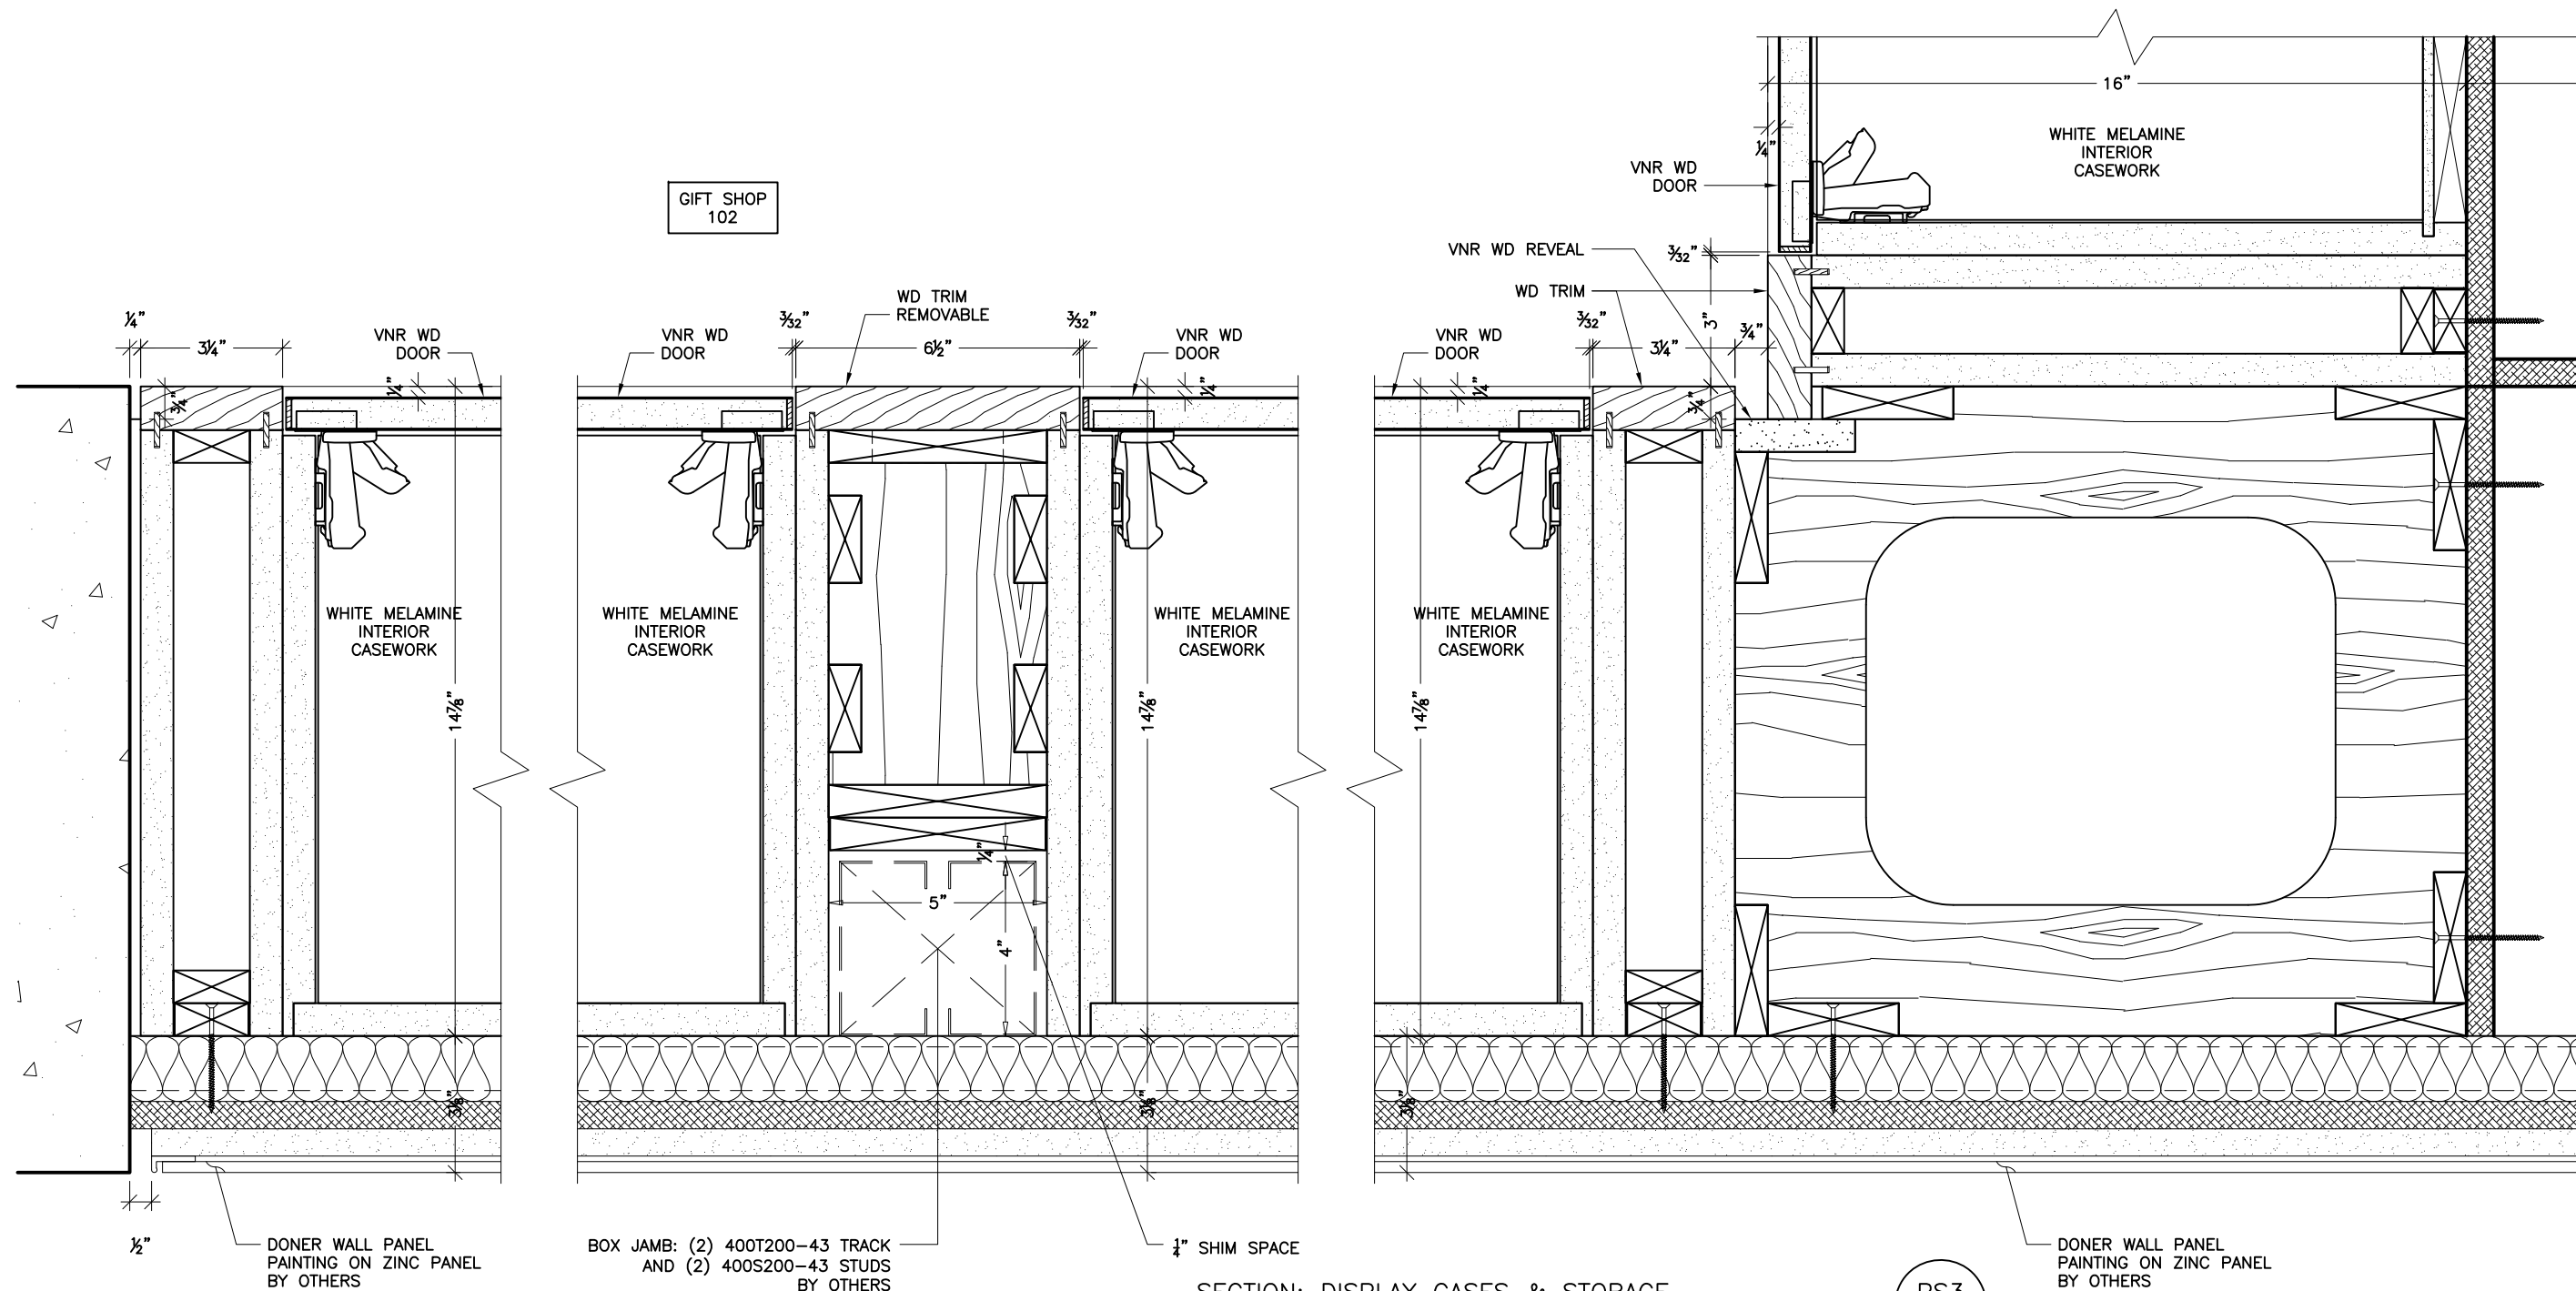

SECTION: DISPLAY CASES & STORAGE

Ref: 1/A559.2, 6&7/A559.5 Scale: 3" = 1'-0"

PS3
DTL8.01




801 SW 16th Street
Renton, WA 98057
phone: 800.643.3512
fax: 425.282.1944

Juneau SLAM
395 Whittier Street
Juneau, Alaska 99801-1718

GIFT SHOP

SCALE as noted	
DATE 01/12/15	DRAFTER KSS
REVISIONS 02/17/15 KSS 06/12/15 KSS Rev3 Rev4: Rev5: Rev6:	
FILE NAME Delta 2	
JOB # 3592	
SHEET	

DTL8.03

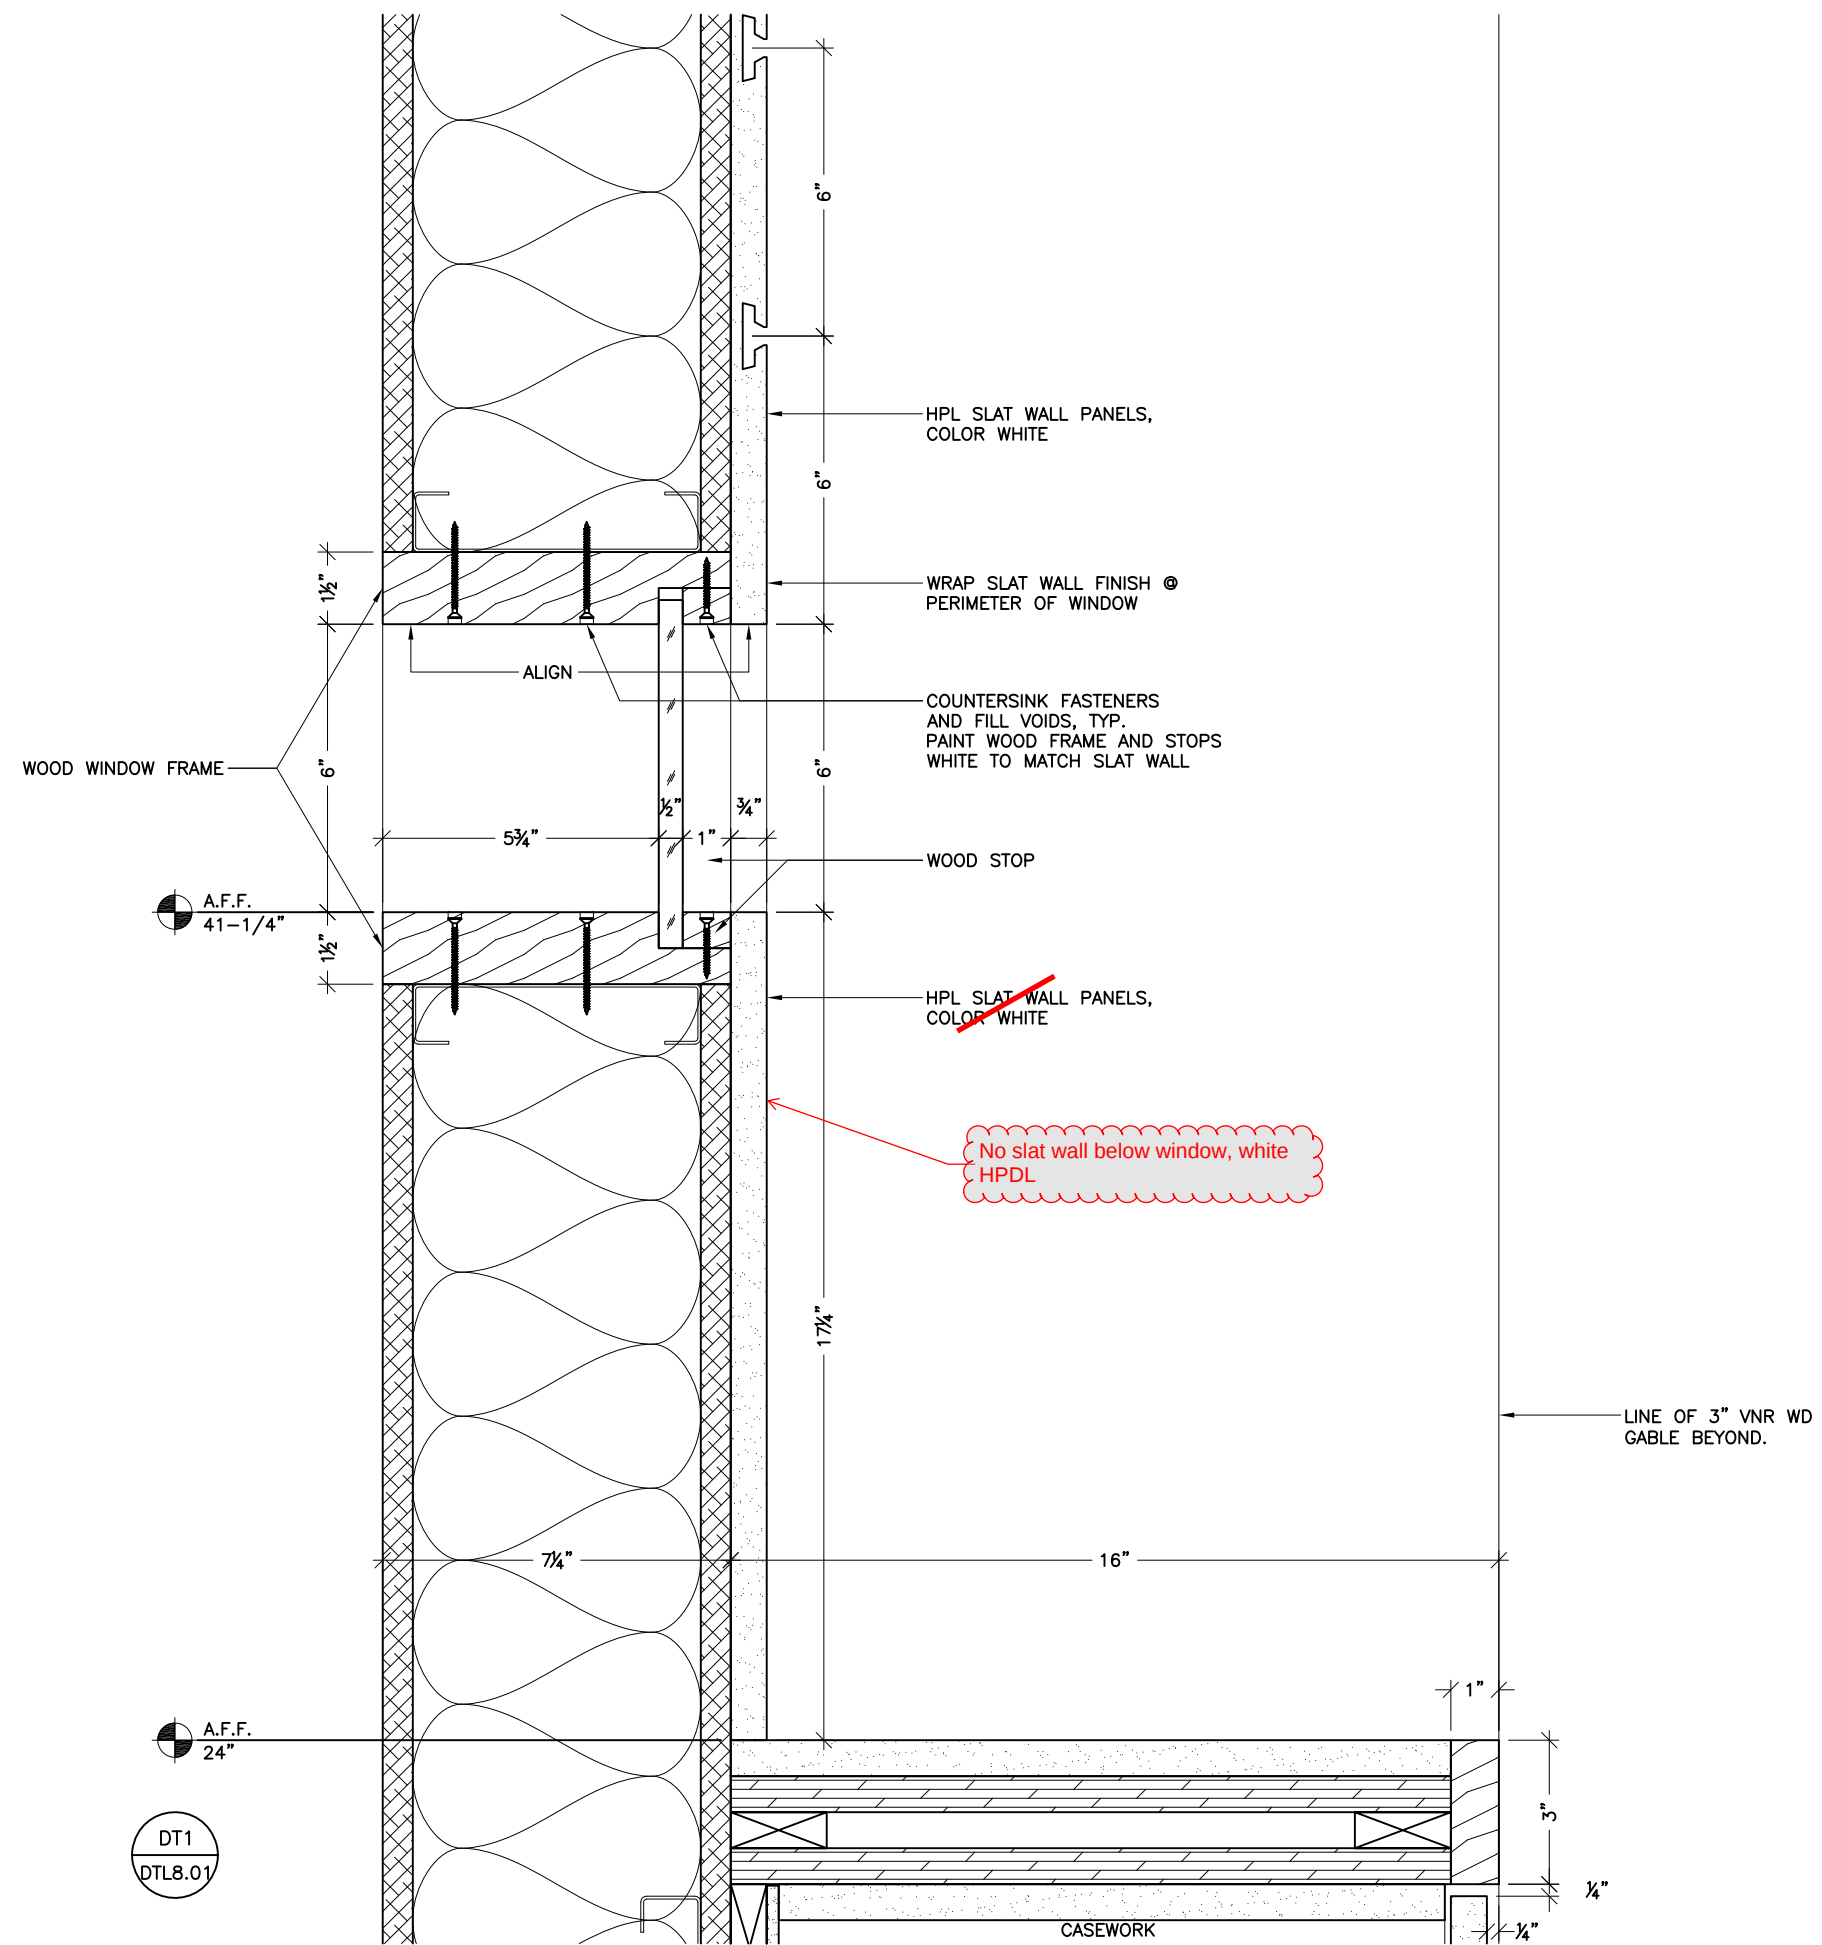

**801 SW 16th Street
Renton, WA 98057
phone: 800.643.3512
fax: 425.282.1944**



Juneau SLAM
395 Whittier Street
Juneau, Alaska 99801-1718

GIF | SHOP

SCALE
s noted

DATE	DRAFTER
01/12/15	KSS

REVISIONS



02/17/15	KSS
06/12/15	KSS
Rev3	
Rev4:	
Rev5:	
Rev6:	

FILE NAME
Delta 2

JOB #
3592

SHEET


DTL8.04

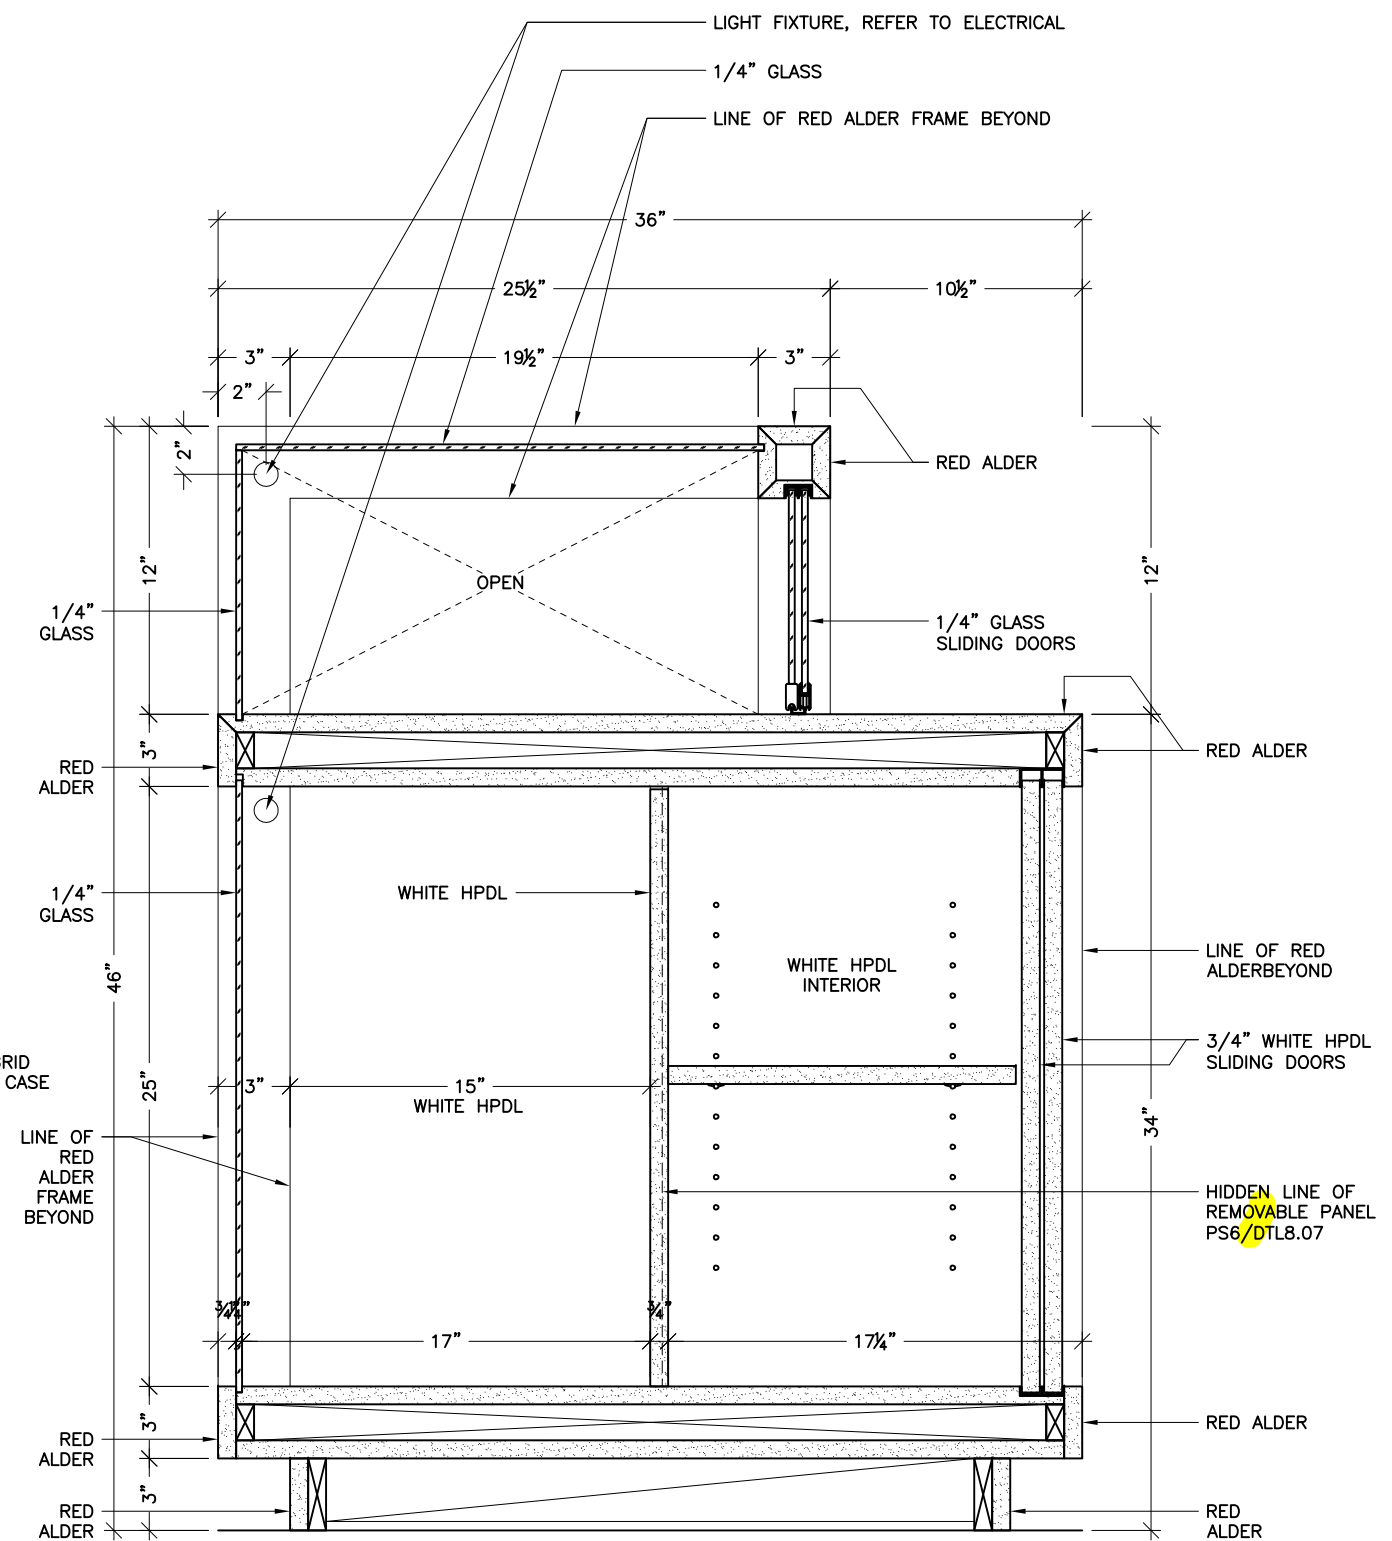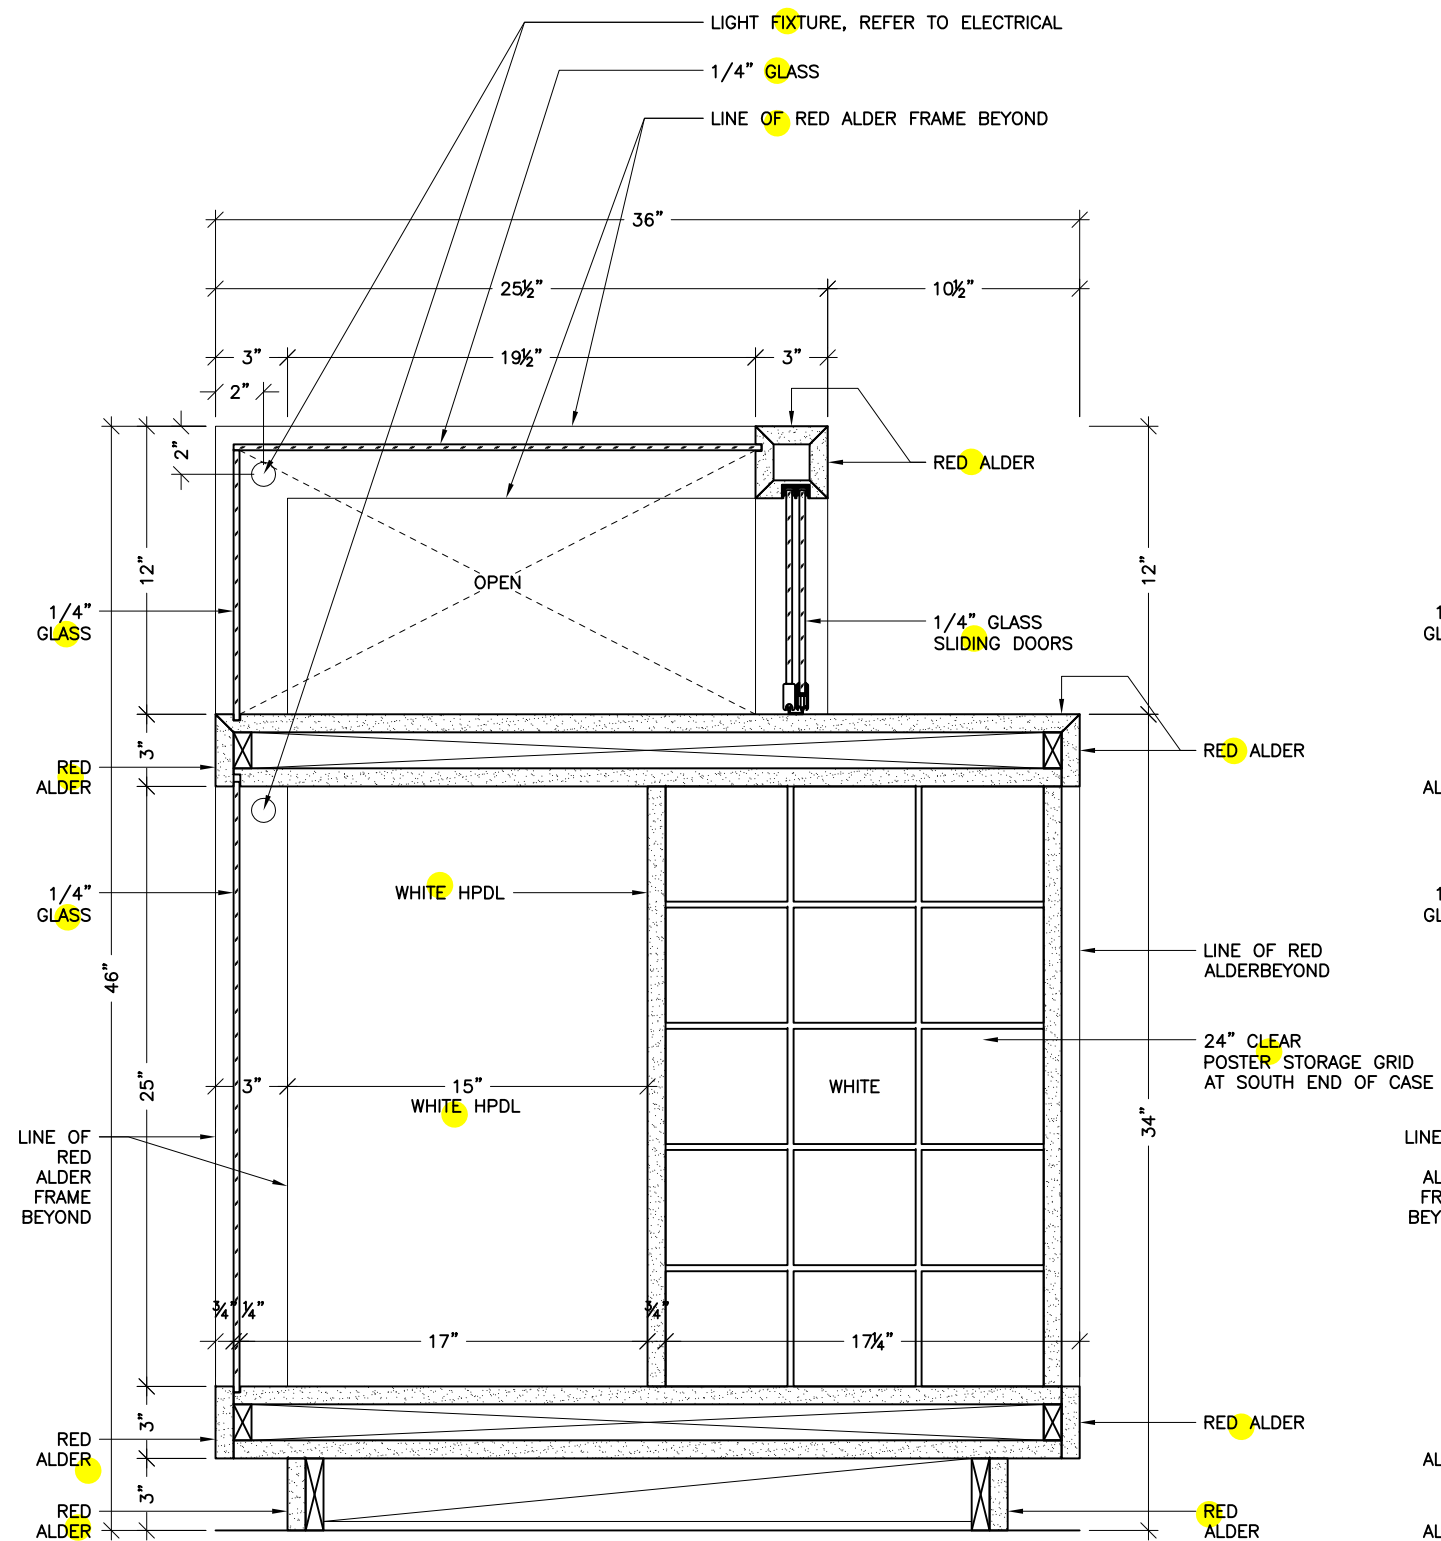

Juneau SLAM
395 Whittier Street
Juneau, Alaska 99801-1718

GIF | SHOP

SCALE	
as noted	
DATE	DRAFTER
01/17/15	KSS
REVISIONS	
02/17/15 KSS	
06/12/15 KSS	
Rev3	
Rev4:	
Rev5:	
Rev6:	
FILE NAME	
Delta 2	
JOB #	
3592	
SHEET	

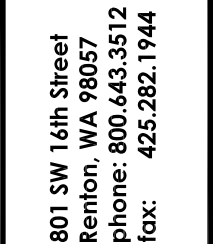

Juneau SLAM
395 Whittier Street
Juneau, Alaska 99801-1718

GIFT SHOP

SCALE

as noted

DATE	DRAFTER
01/12/15	KSS

REVISIONS

02/17/15	KSS
06/12/15	KSS
Rev3	
Rev4:	
Rev5:	
Rev6:	

FILE NAME

Delta 2

JOB #

3592


SHEET

DTL8.06

SECTION: GIFT SHOP DISPLAY CASE 2
Ref: 1/SK-RFI1931-2

SC6
8.04

FJ = FIELD JOINT

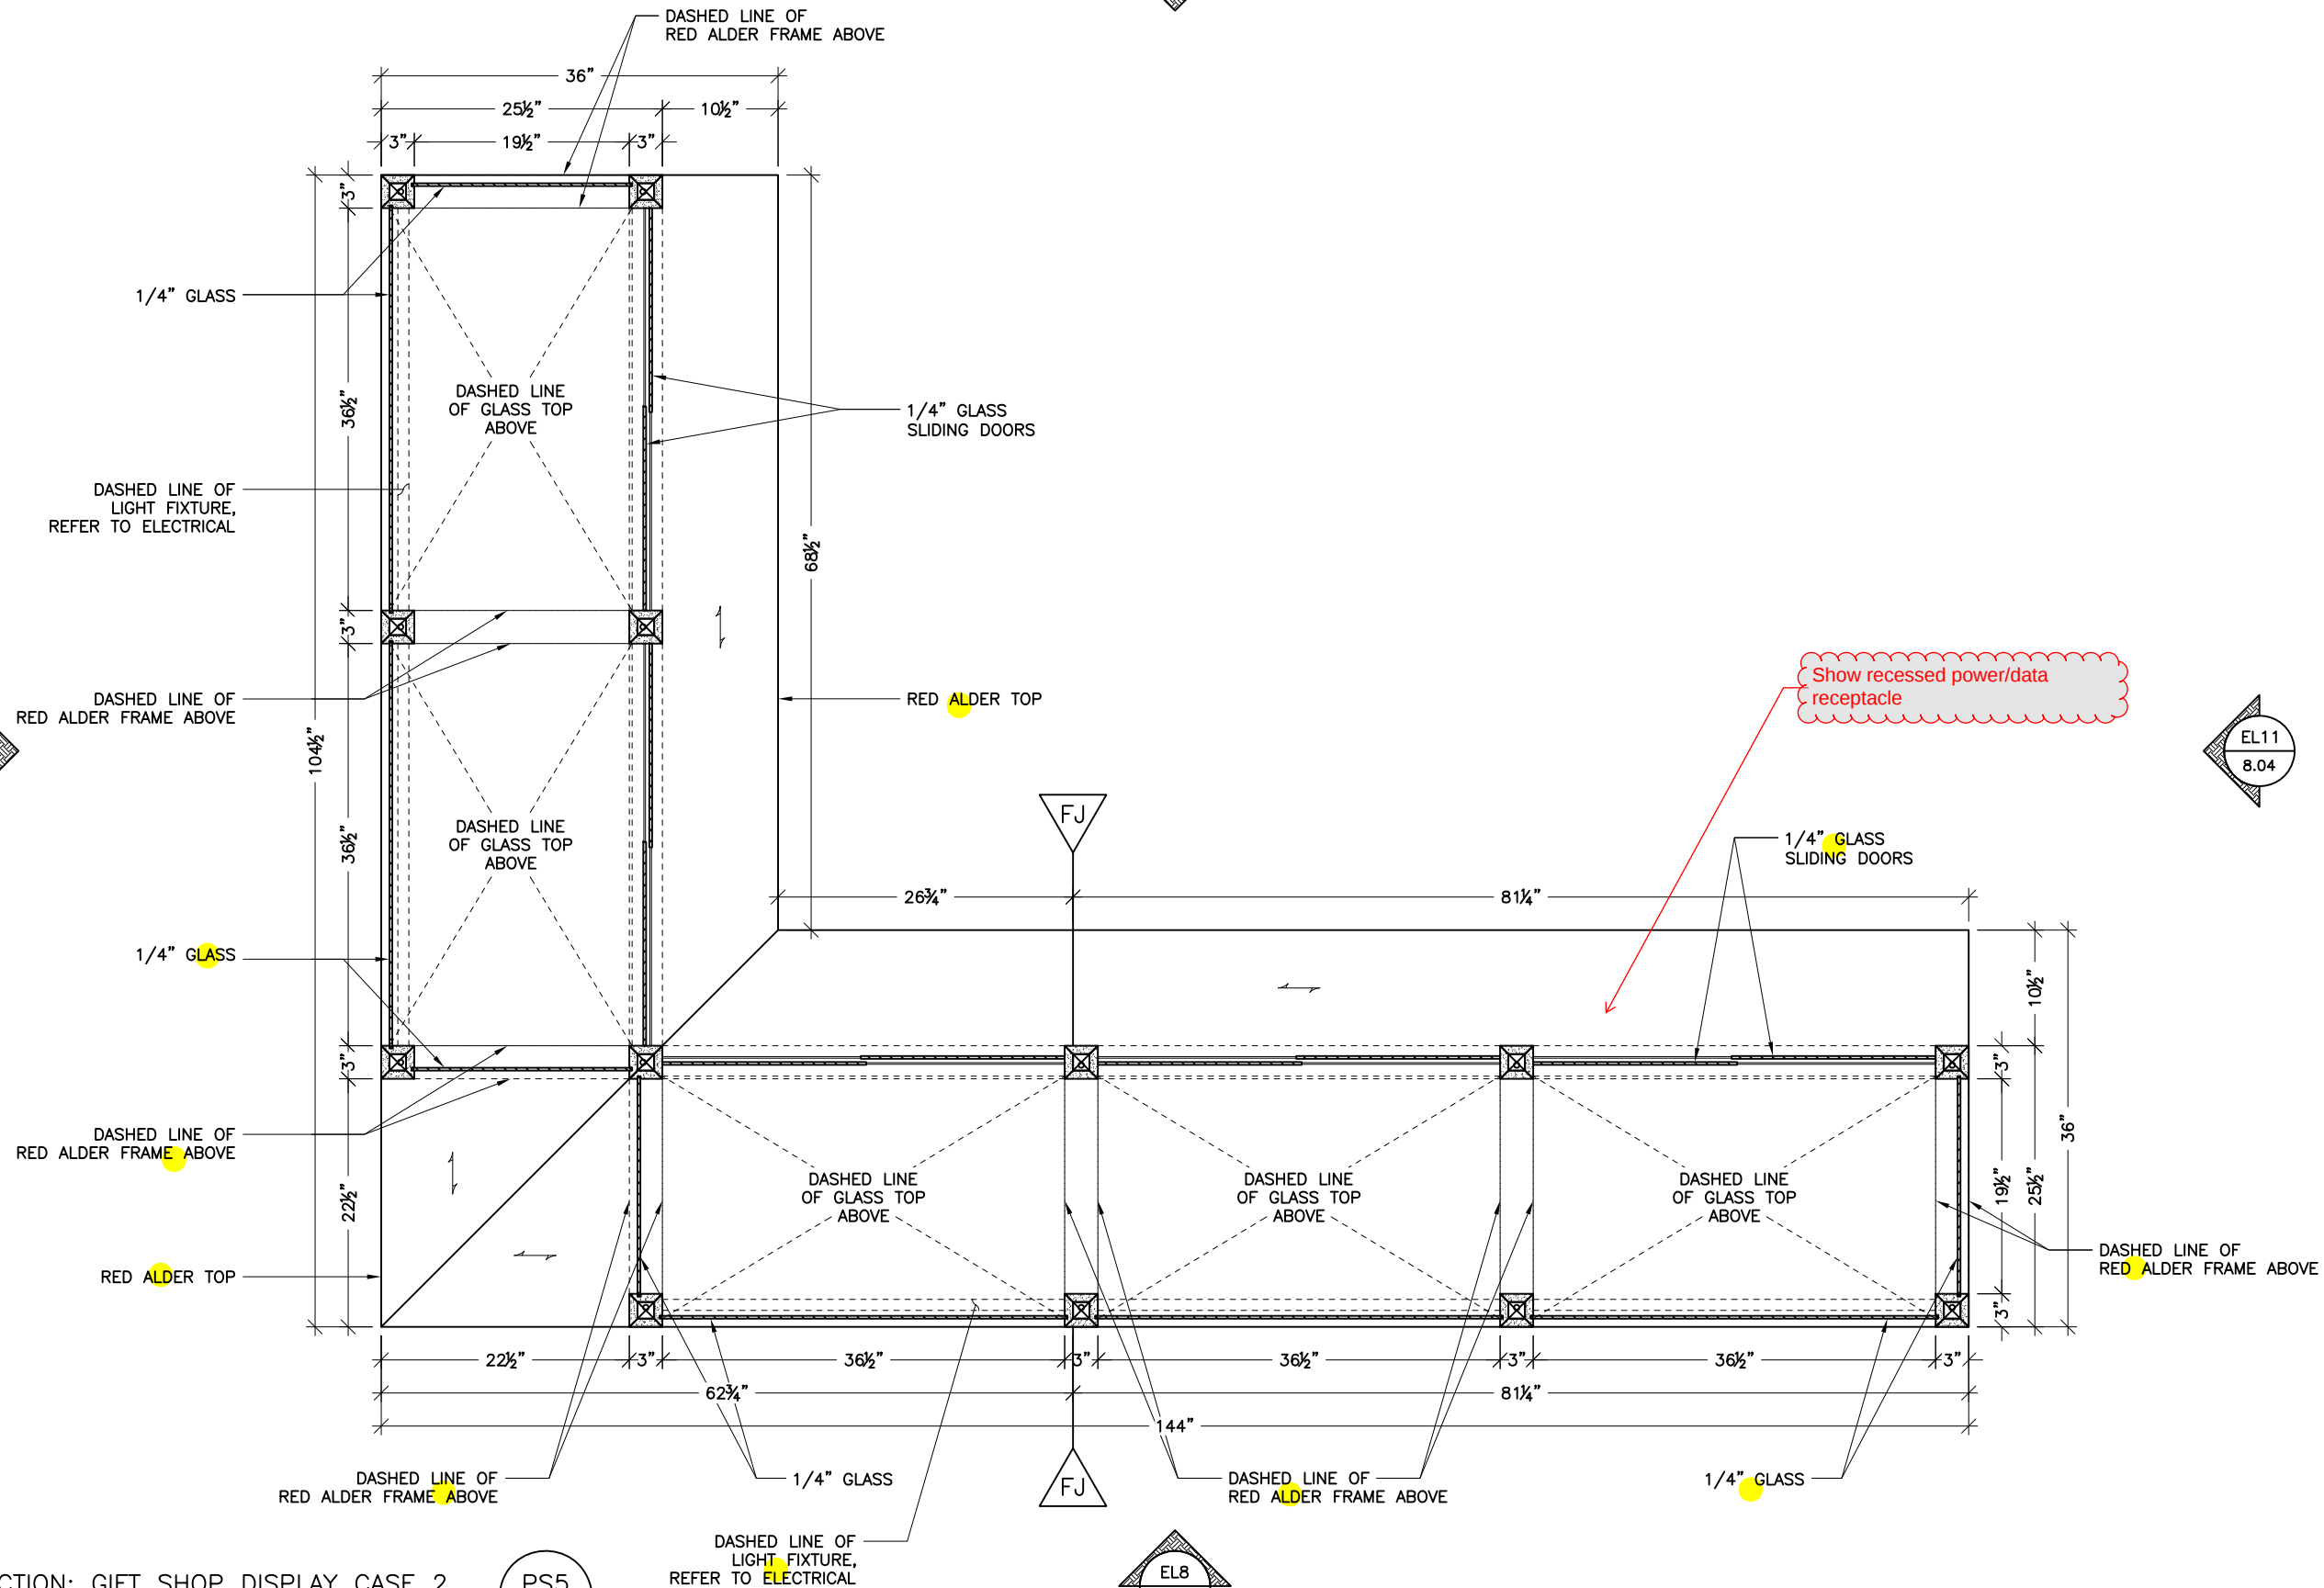

SECTION: GIFT SHOP DISPLAY CASE 2
Ref: 3/4"=1'

PS5
8.04

801 SW 16th Street
Renton, WA 98057
phone: 800.643.3512
fax: 425.282.1944



Juneau SLAM
395 Whittier Street
Juneau, Alaska 99801-1718

GIFT SHOP


SCALE	
as noted	
DATE	DRAFTER
01/12/15	KSS
REVISIONS	
02/17/15 KSS	
06/12/15 KSS	
Rev3	
Rev4:	
Rev5:	
Rev6:	
FILE NAME	
Delta 2	
JOB #	
3592	
SHEET	

DTL8.07

FJ = FIELD JOINT

EL10
8.04

SC8
DTL8.10

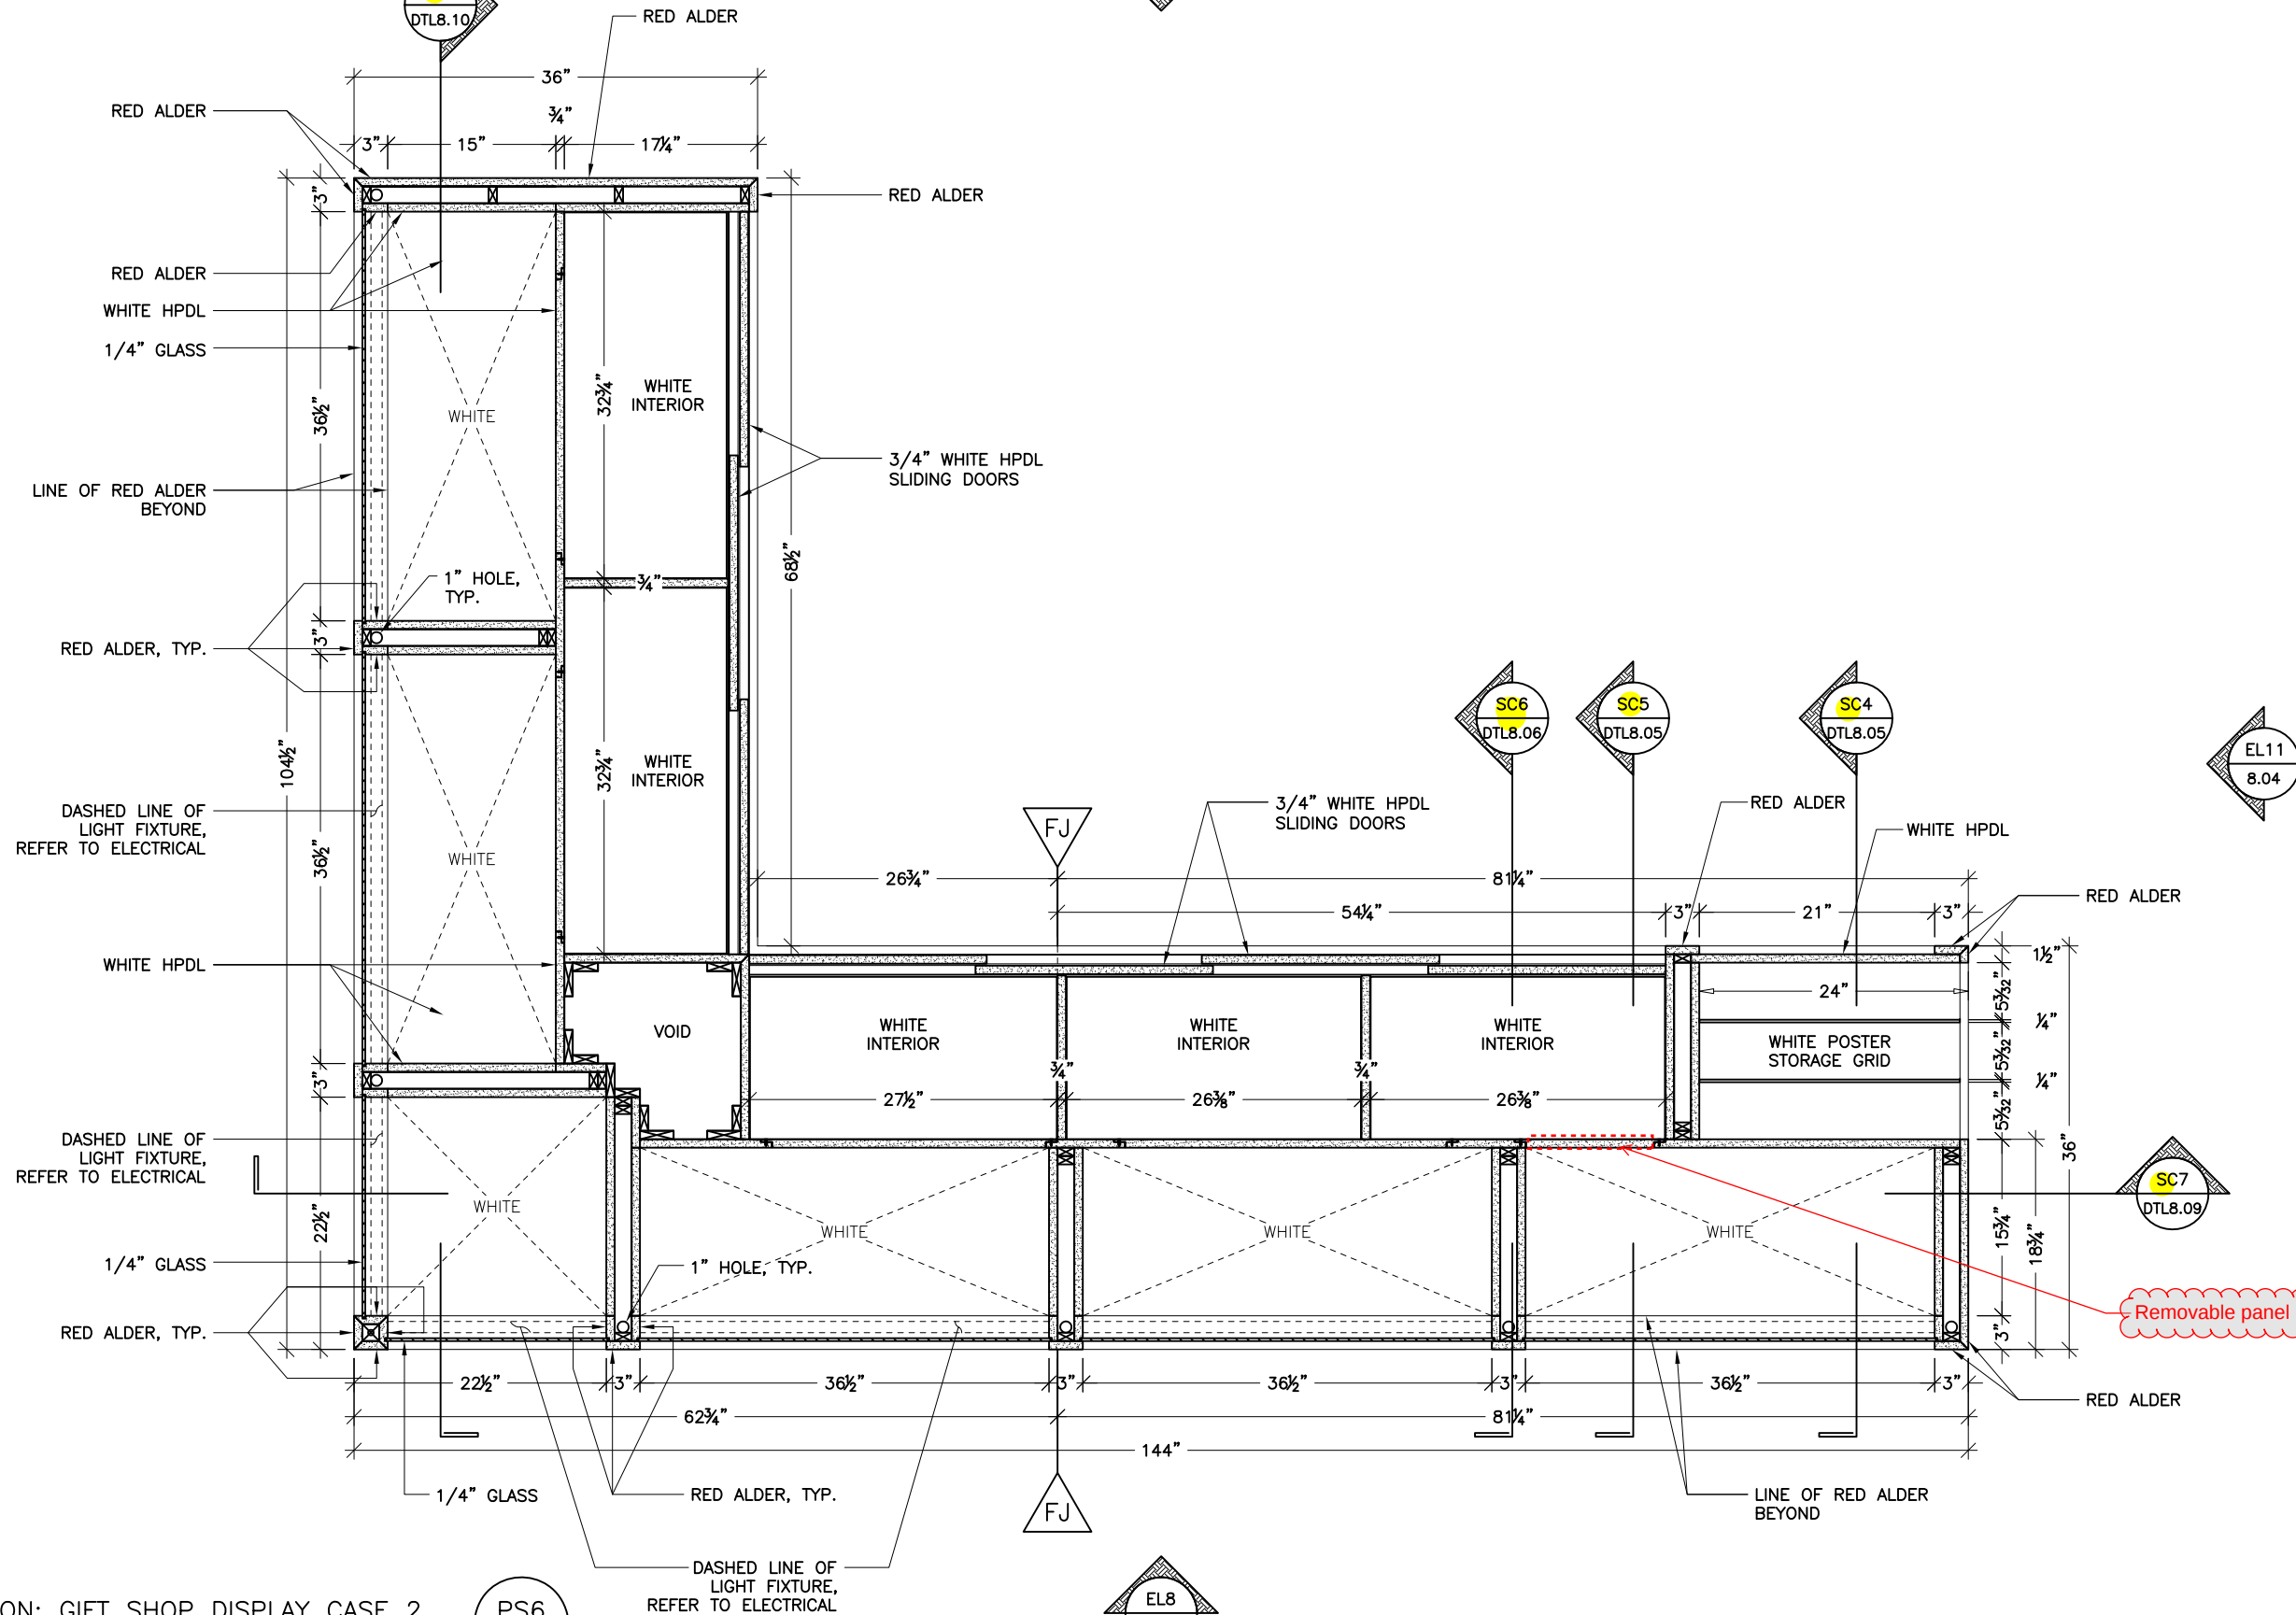

SECTION: GIFT SHOP DISPLAY CASE 2
Ref: 3/4"=1'

PS6
8.04

EL8
8.04

801 SW 16th Street
Renton, WA 98057
phone: 800.643.3512
fax: 425.282.1944





Juneau SLAM
395 Whittier Street
Juneau, Alaska 99801-1718

GIFT SHOP

SCALE	
as noted	
DATE	DRAFTER
01/12/15	KSS
REVISIONS	
02/17/15 KSS	
06/12/15 KSS	
Rev3	
Rev4:	
Rev5:	
Rev6:	
FILE NAME	
Delta 2	
JOB #	
3592	
SHEET	

DTL8.08

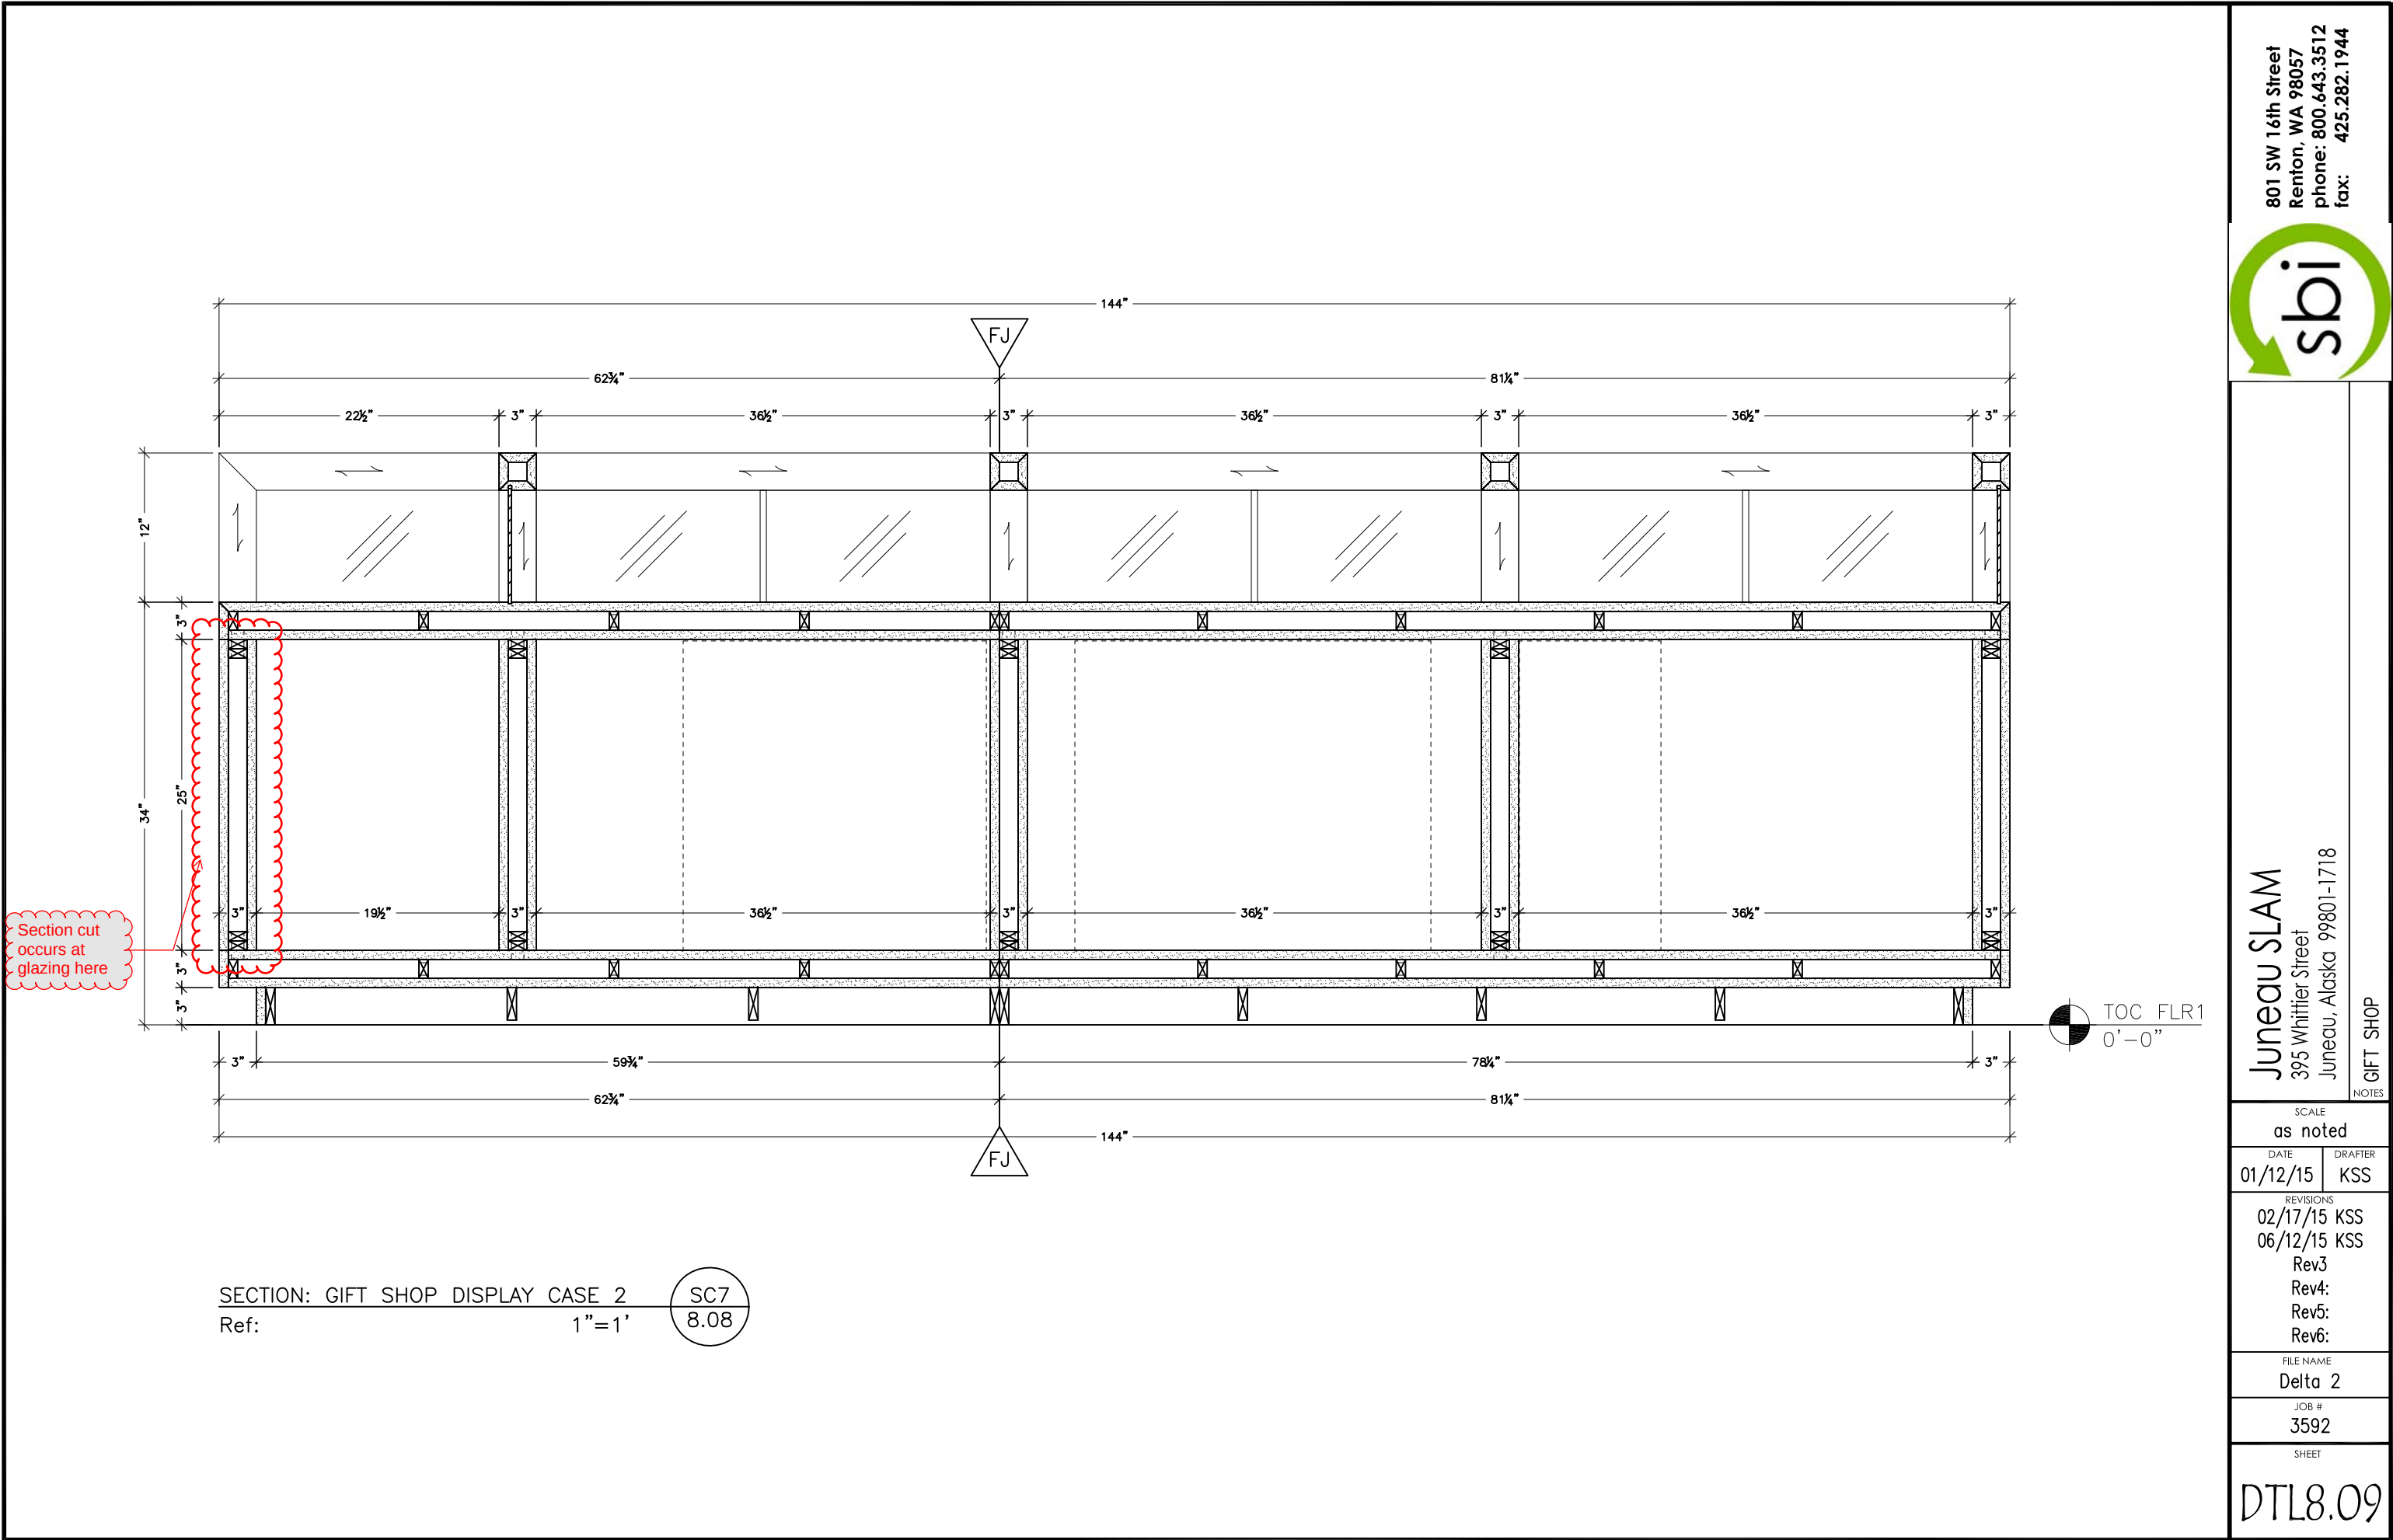

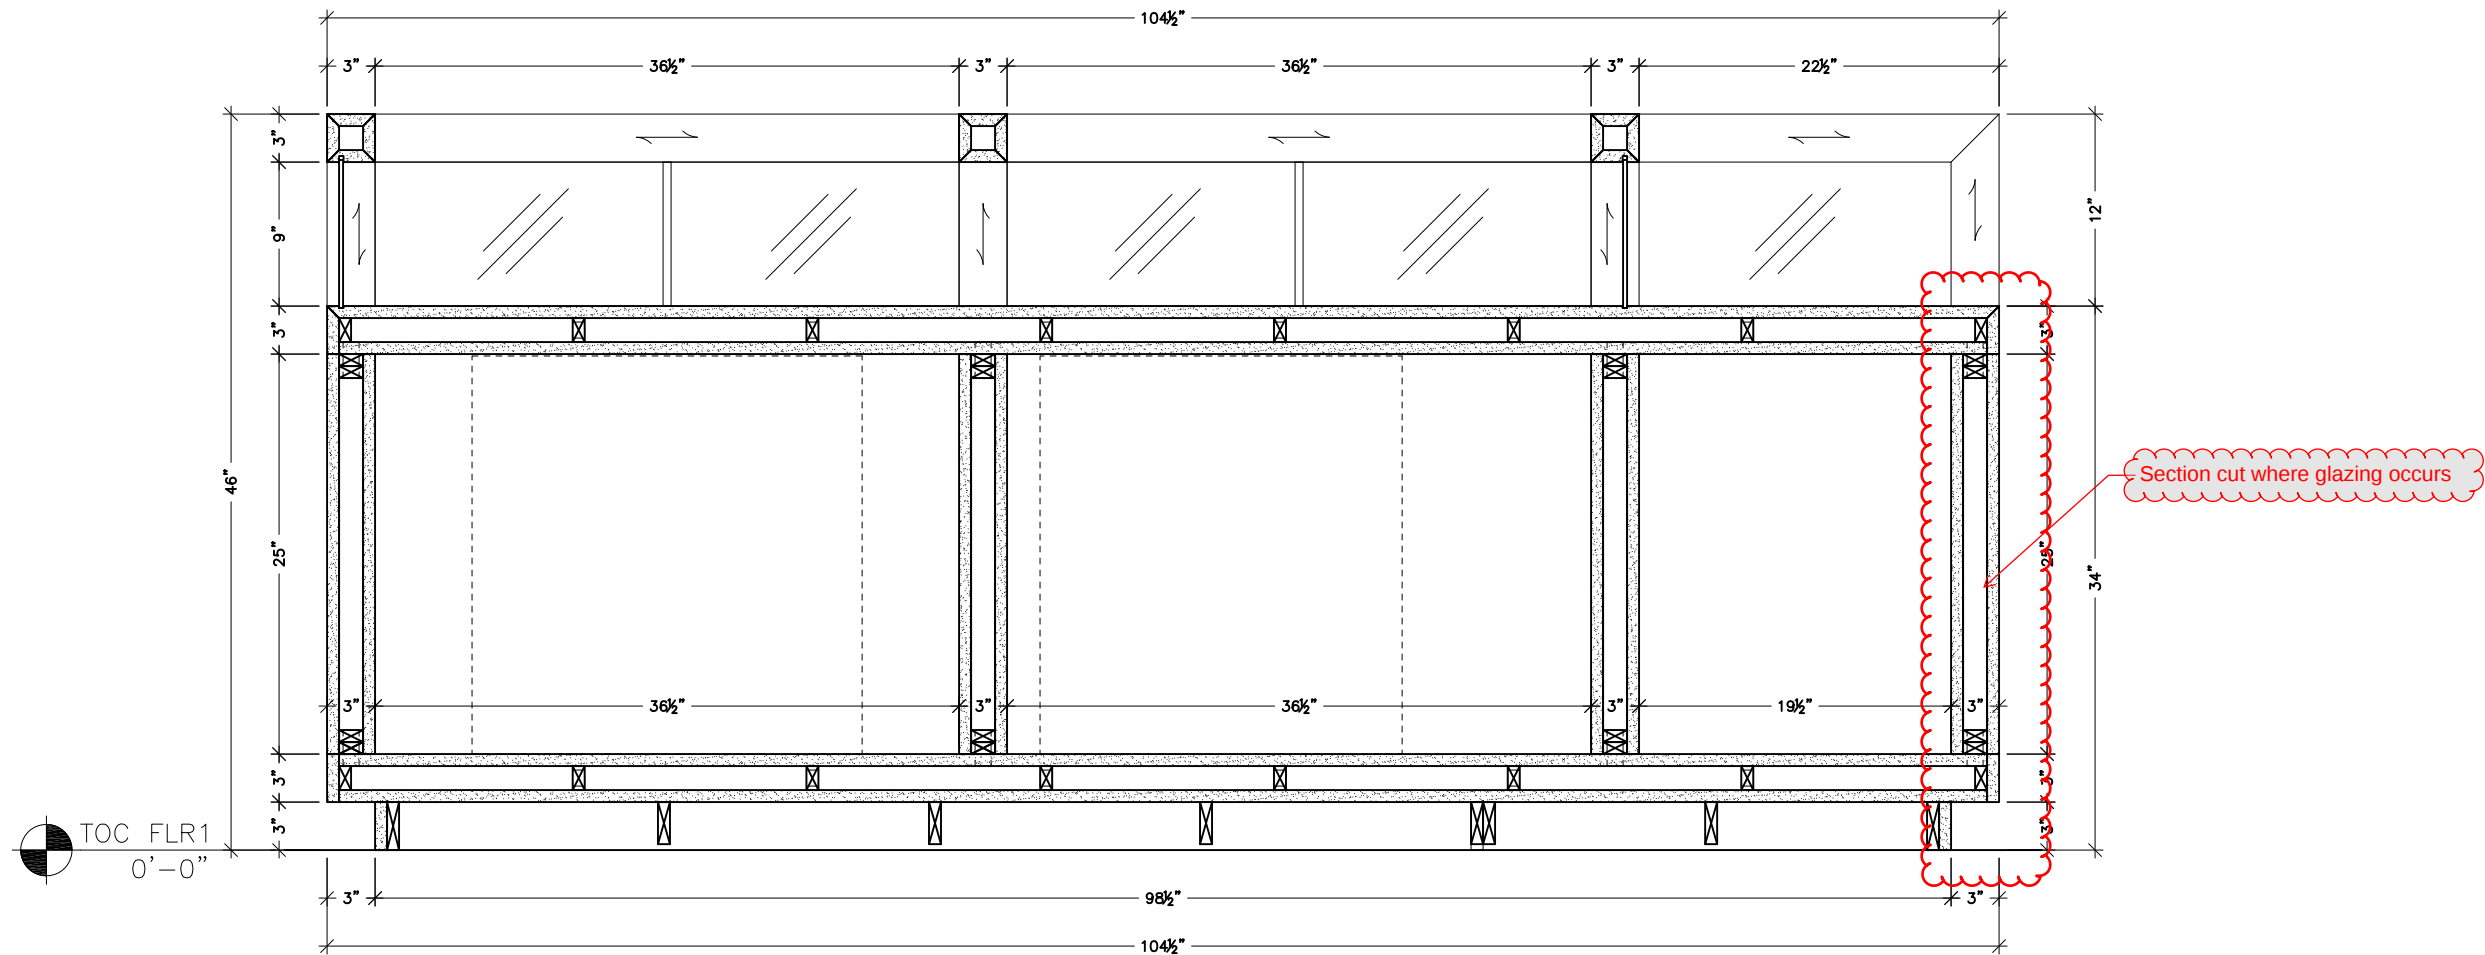

SECTION: GIFT SHOP DISPLAY CASE 2
Ref: 1"=1'

SC8
8.08



801 SW 16th Street
Renton, WA 98057
phone: 800.643.3512
fax: 425.282.1944

Juneau SLAM
395 Whittier Street
Juneau, Alaska 99801-1718

GIFT SHOP

SCALE
as noted


DATE	DRAFTER
01/12/15	KSS

REVISIONS

02/17/15	KSS
06/12/15	KSS
Rev3	
Rev4:	
Rev5:	
Rev6:	


FILE NAME
Delta 2
JOB #
3592
SHEET

DTL8.10

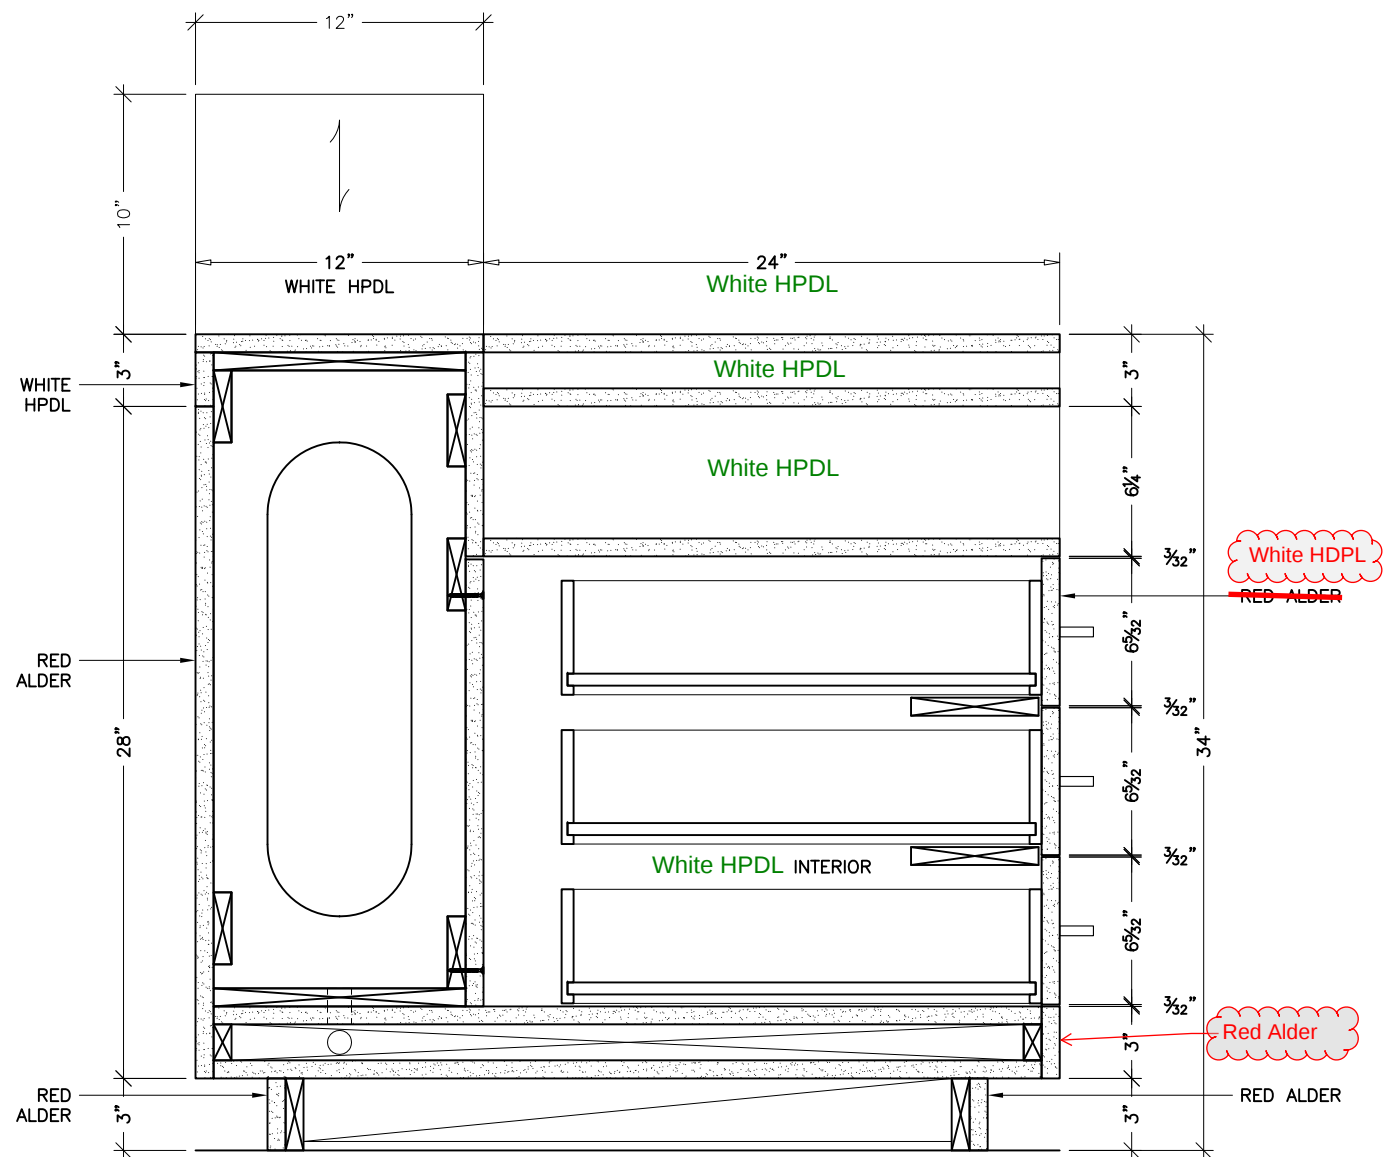

SECTION: GIFT SHOP CASE 1
Ref: 3/SK-RFI931-1 1-1/2"=1"

SC9
8.02

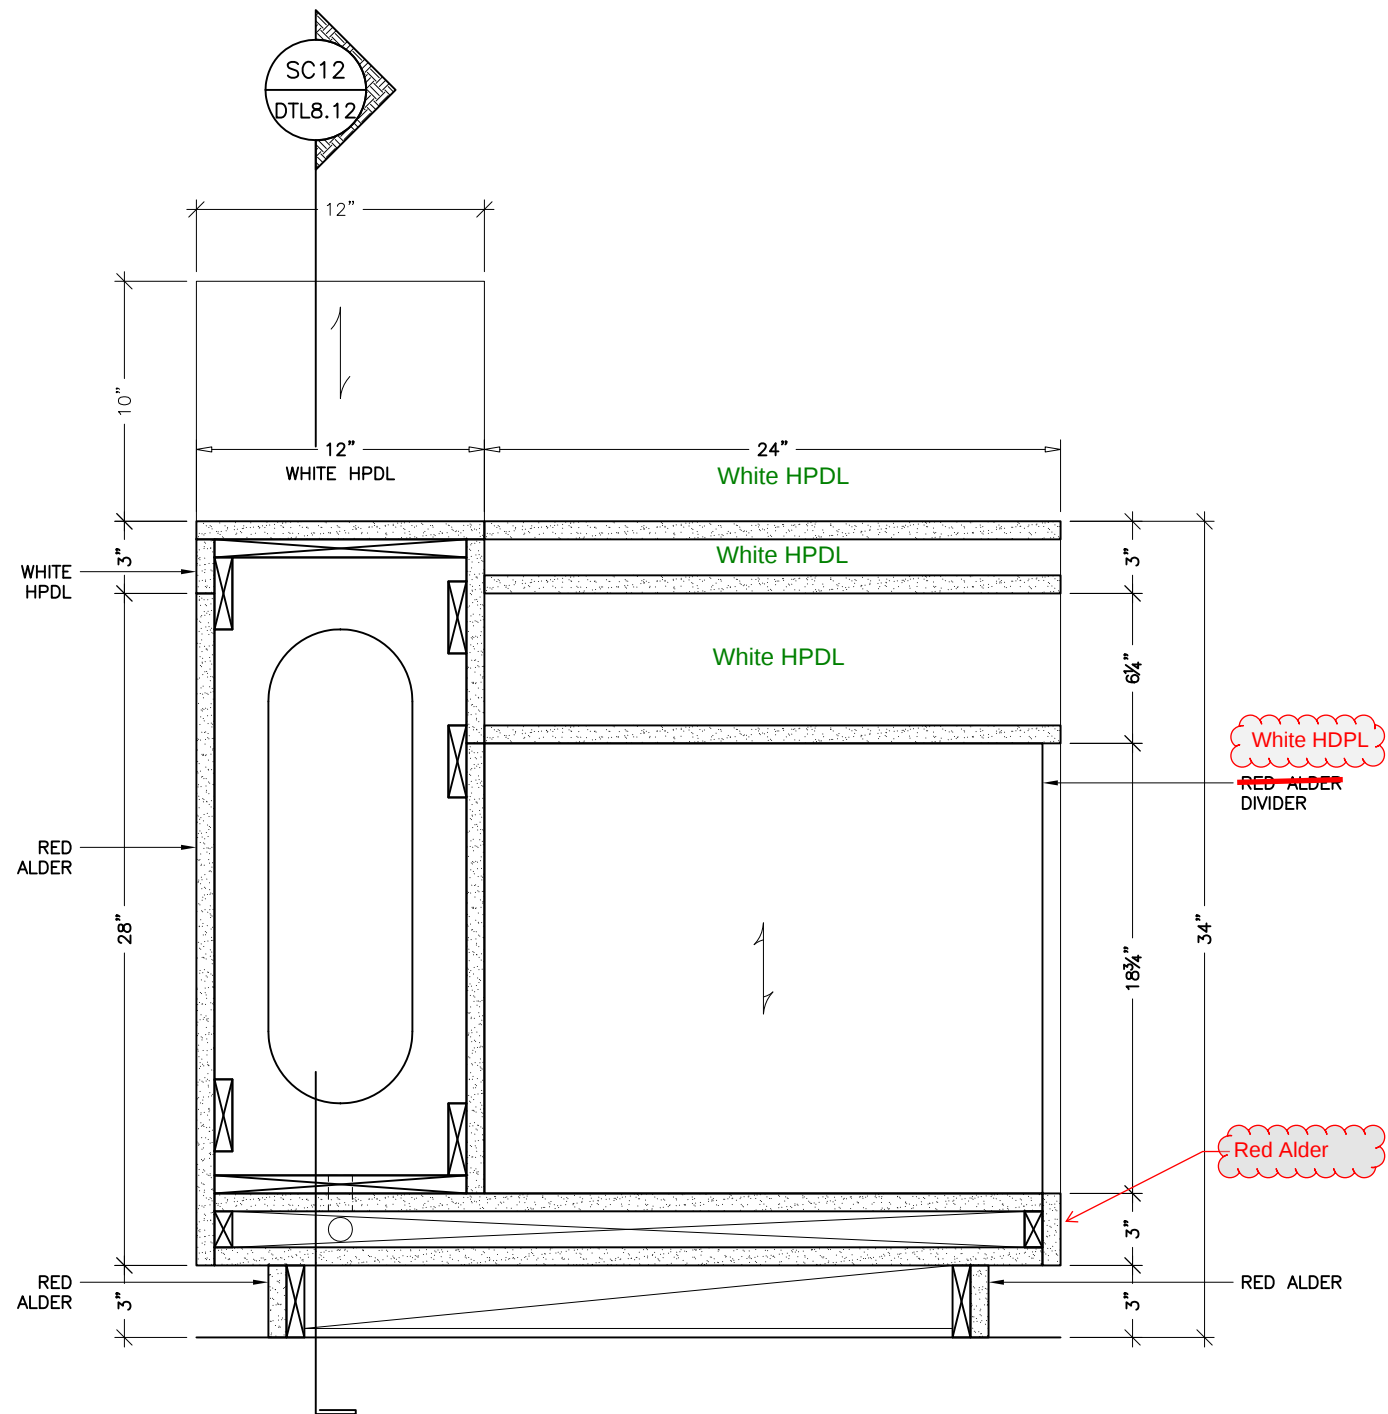

SECTION: GIFT SHOP CASE 1
Ref: 3/SK-RFI931-1 SIM. 1-1/2"=1"

SC10
8.02

801 SW 16th Street
Renton, WA 98057
phone: 800.643.3512
fax: 425.282.1944



Juneau SLAM
395 Whittier Street
Juneau, Alaska 99801-1718

GIFT SHOP

SCALE	
as noted	
DATE	DRAFTER
01/12/15	KSS
REVISIONS	
02/17/15 KSS	
06/12/15 KSS	
Rev3	
Rev4:	
Rev5:	
Rev6:	
FILE NAME	
Delta 2	
JOB #	
3592	
SHEET	

DTL8.11



SC13
8.03



SC14
8.03




SC15
8.03



GIF | SHOP

SCALE	
as noted	
DATE	DRAFTER
01/12/15	KSS
REVISIONS	
02/17/15 KSS	
06/12/15 KSS	
Rev3	
Rev4:	
Rev5:	
Rev6:	
FILE NAME	
Delta 2	
JOB #	
3592	
SHEET	

DTL8.13

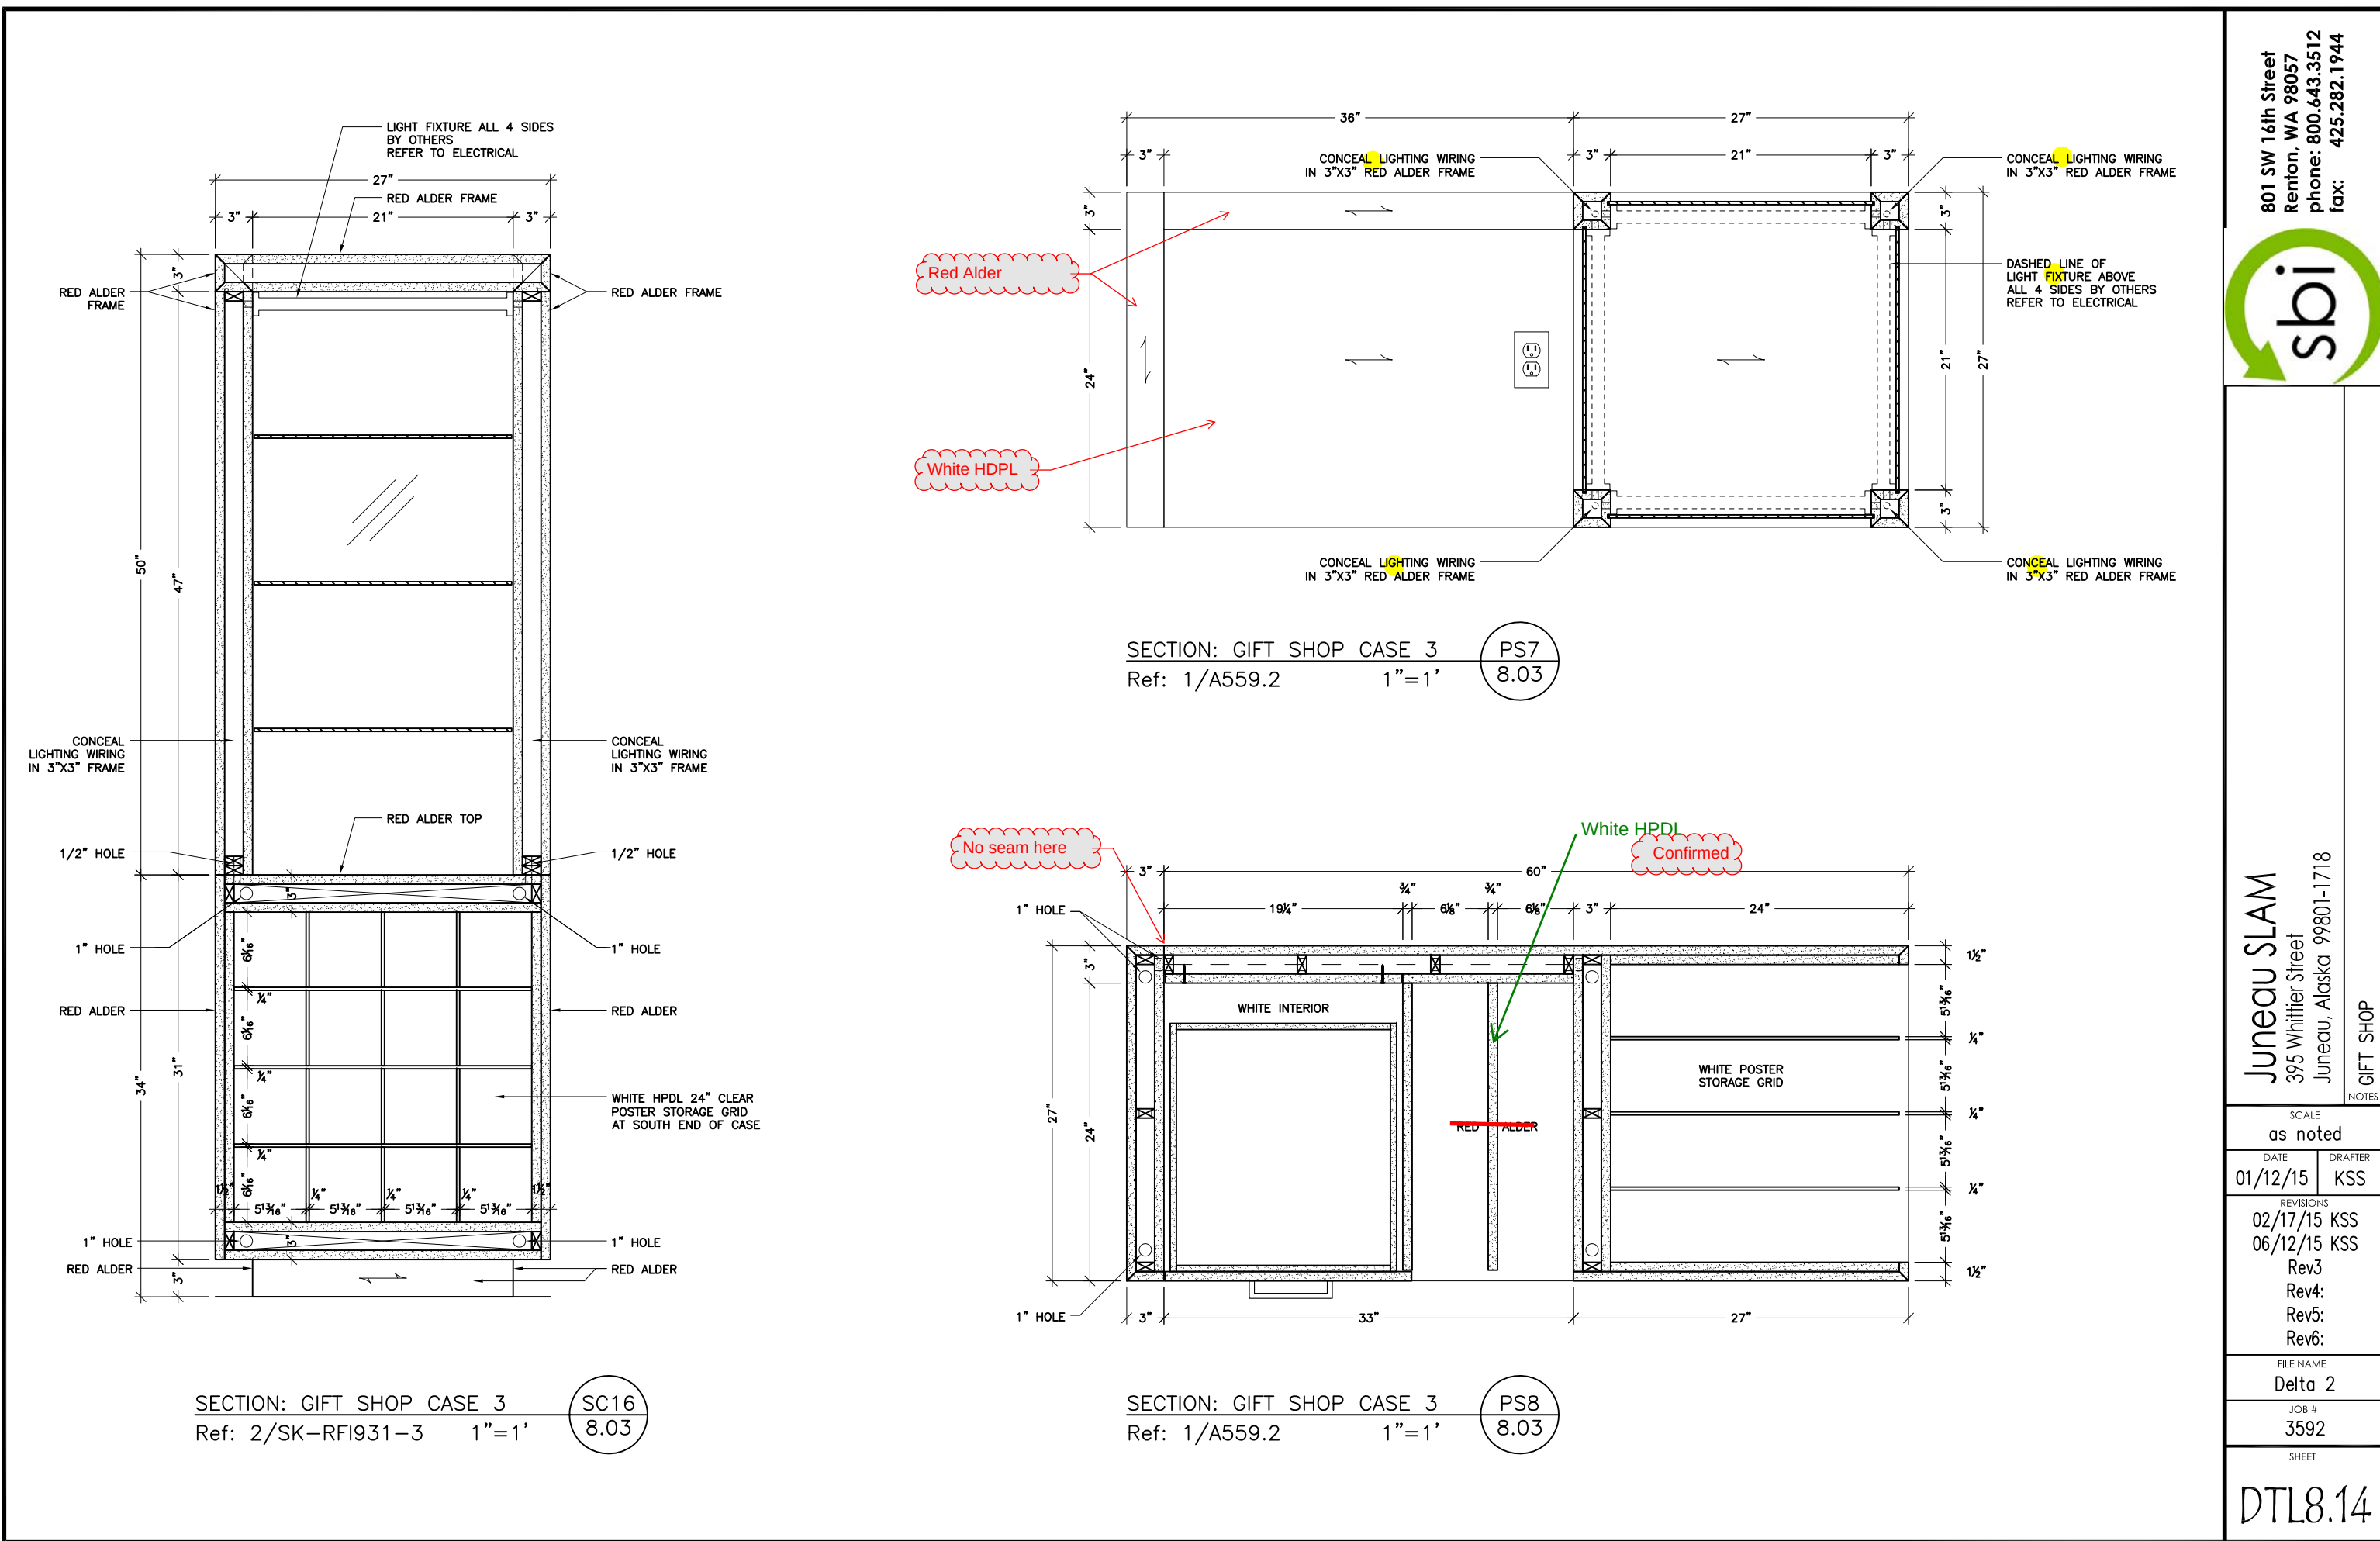


801 SW 16th Street
Renton, WA 98057
phone: 800.643.3512
fax: 425.282.1944

Juneau SLAM
395 Whittier Street
Juneau, Alaska 99801-1718

GIFT SHOP


SCALE as noted	
DATE 01/12/15	DRAFTER KSS
REVISIONS 02/17/15 KSS 06/12/15 KSS Rev3 Rev4: Rev5: Rev6:	
FILE NAME Delta 2	
JOB # 3592	
SHEET	

DTL8.14

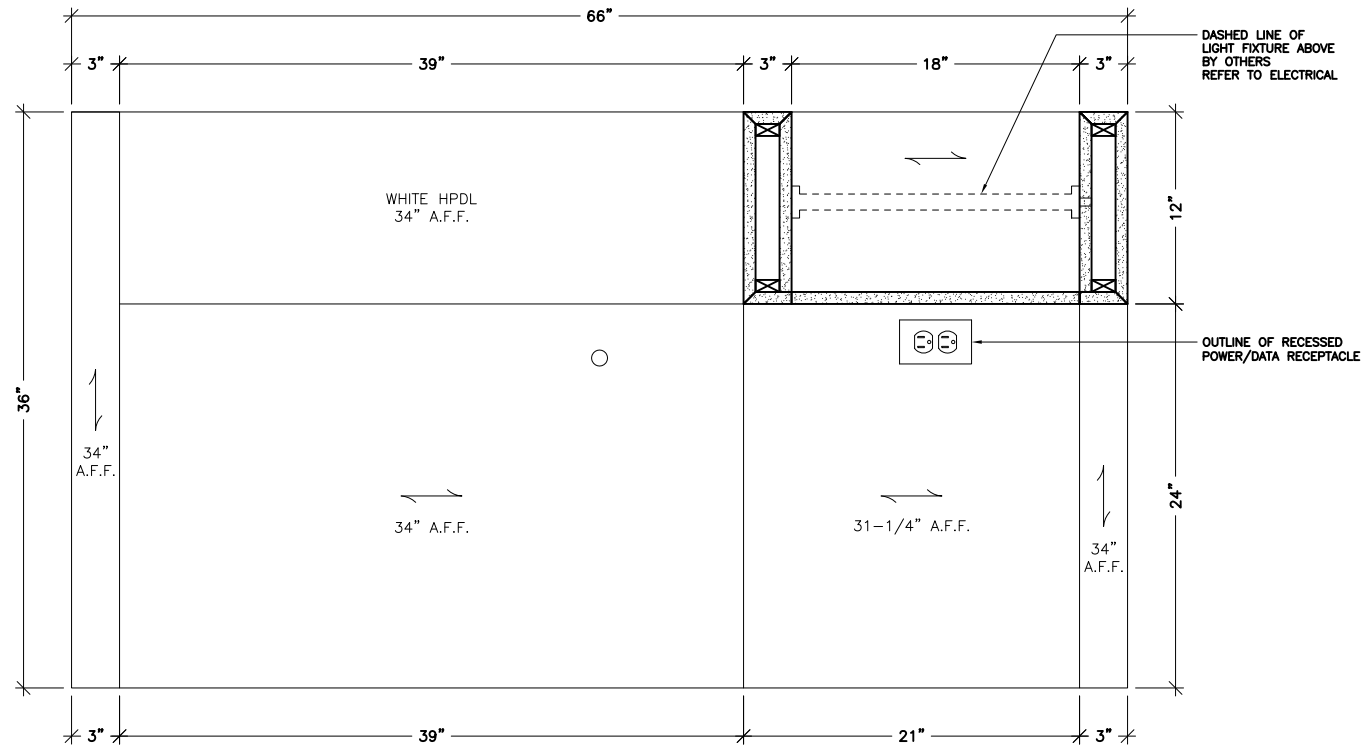

SECTION: GIFT SHOP CASE 1
Ref: 2/SK-RFI931-1 1"=1'

PS9
DTL8.02

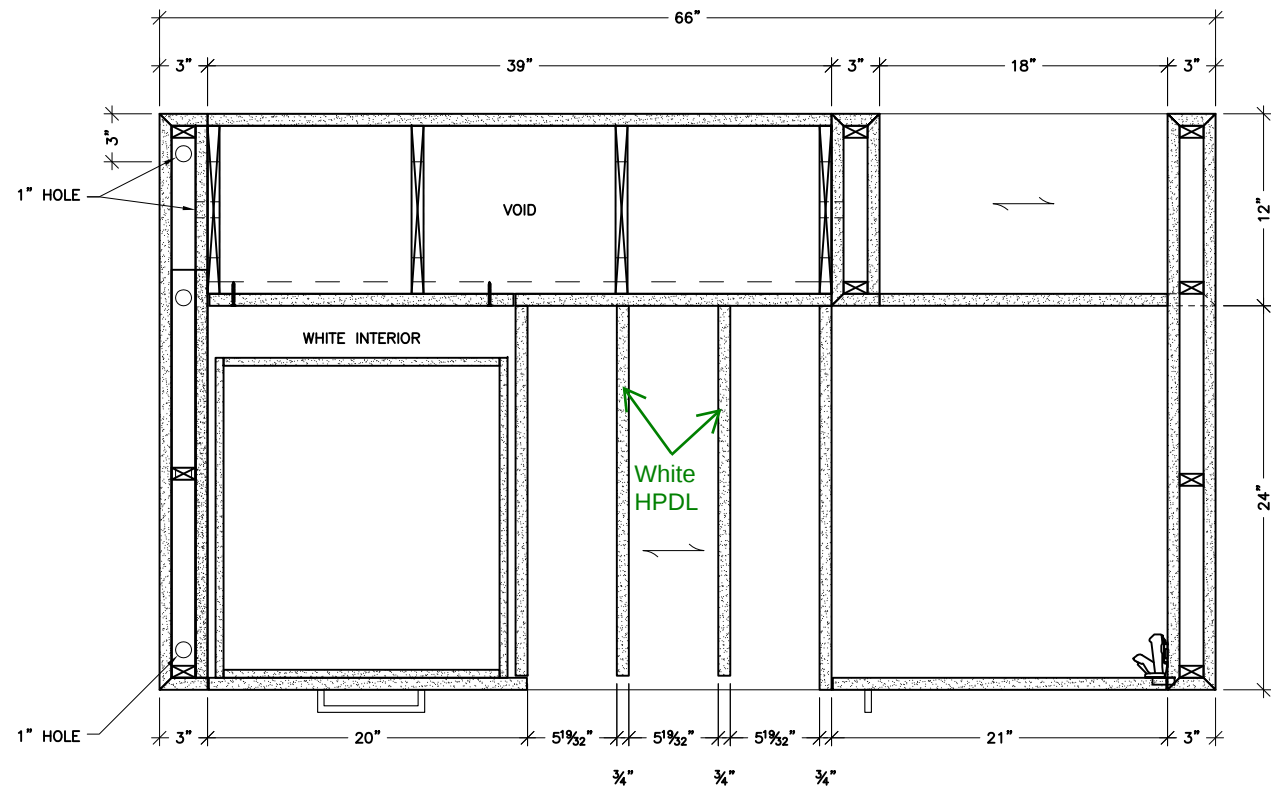

SECTION: GIFT SHOP CASE 1
Ref: 2/SK-RFI931-1 1"=1'

PS10
DTL8.02

801 SW 16th Street
Renton, WA 98057
phone: 800.643.3512
fax: 425.282.1944



Juneau SLAM
395 Whittier Street
Juneau, Alaska 99801-1718

GIFT SHOP

SCALE	
as noted	
DATE	DRAFTER
01/12/15	KSS
REVISIONS	
02/17/15	KSS
06/12/15	KSS
Rev3	
Rev4:	
Rev5:	
Rev6:	
FILE NAME	
Delta 2	
JOB #	
3592	
SHEET	
DTL8.15	