


1 ENLARGED PENTHOUSE DEMOLITION PLAN - SOUTH
1/4"=1'-0"

SHEET NOTES:

1 DEMOLISH DDC CONTROLS, FIRE ALARM WIRING ON CEILING, AND RELOCATE TO ALLOW INSTALLATION OF NEW LOUVER HOOD ON ROOF.

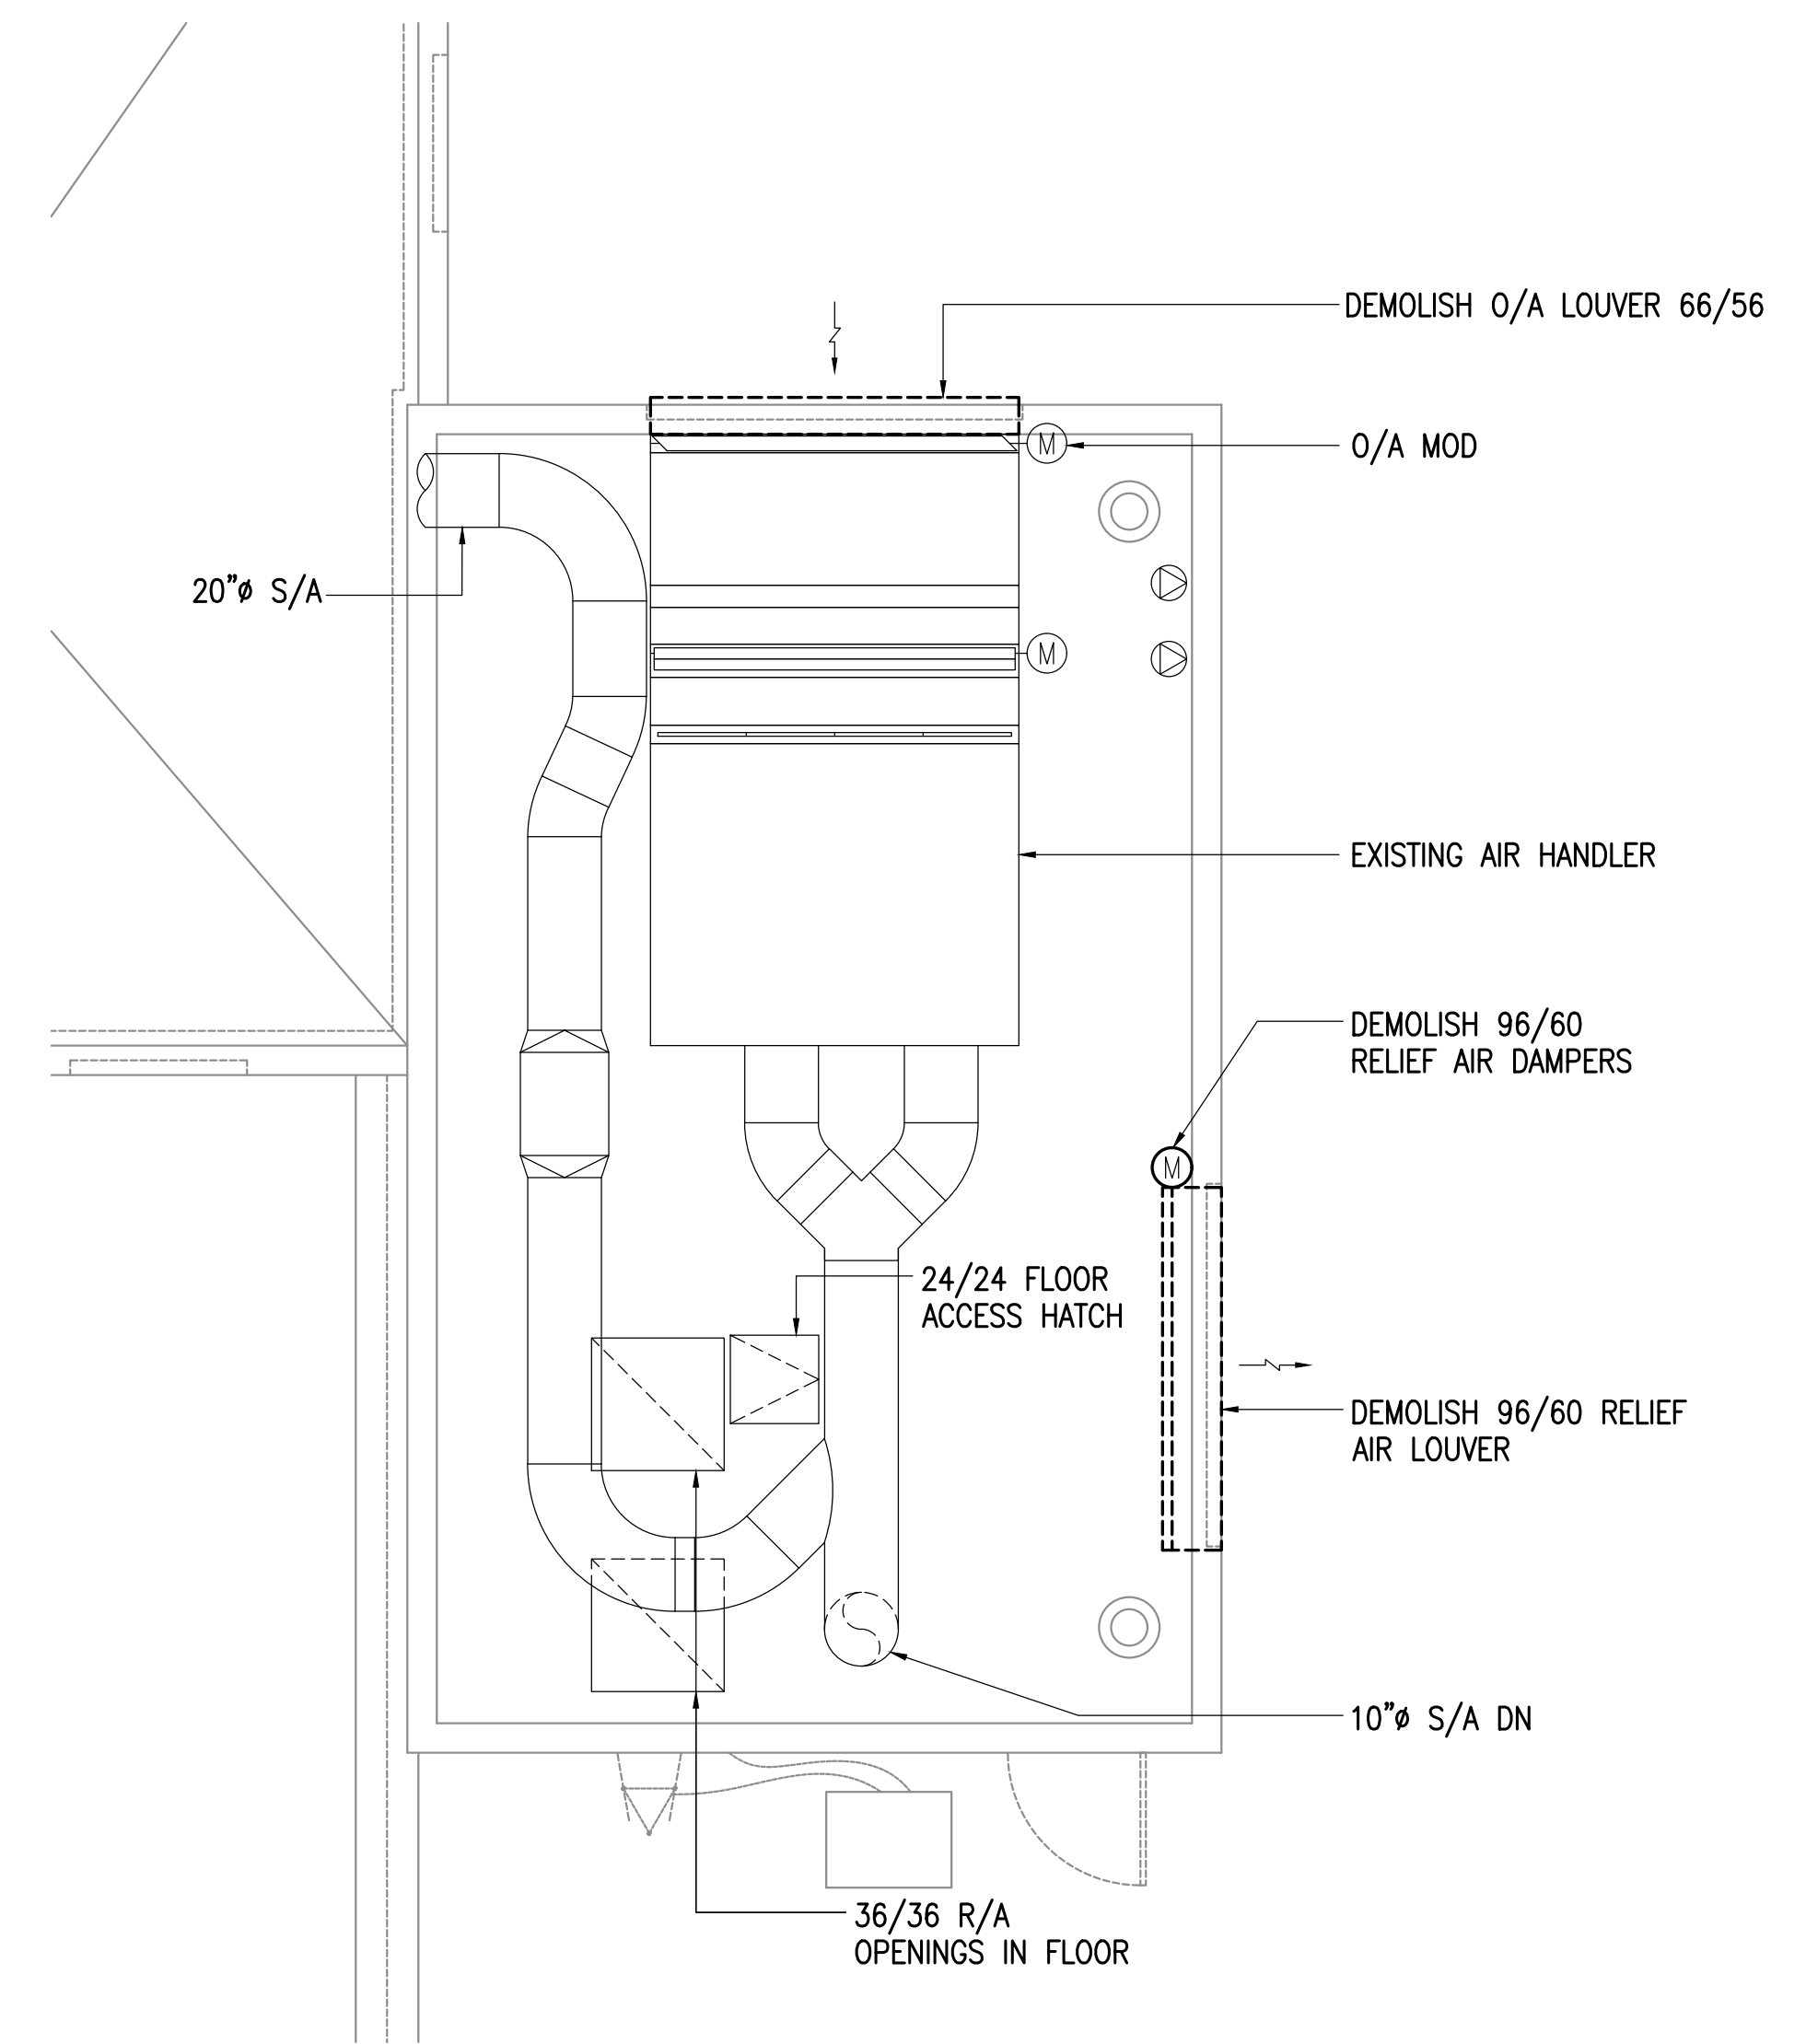

2 ENLARGED PENTHOUSE DEMOLITION PLAN - NORTH
1/4"=1'-0"

BDS INC. ENTITY# 25796D

Architecture | Planning | Roof Technology

3330 C St, Suite 200
Anchorage, AK 99503
T: 907.562.6076 | F: 907.562.6635
W: www.bdsak.com

SOLDOTNA, ALASKA
**UAA KPC
BROCKEL BLDG
REROOF**

UAA PROJECT NO. 16-0111
BDS PROJECT NO. 618004.002

PHASE
BID DOCUMENTS
DATE
FEBRUARY 28, 2017
DRAWING TITLE
**ENLARGED
PENTHOUSE
DEMOLITION PLAN**

M2