

FILE NAME: X:\16601 NSB001\Draws\1dwg\Sheet Files\16601 - G1.0.dwg
PLOTED: WPL 03/08/2017 11:05:20 AM

UNIVERSITY OF ALASKA ANCHORAGE NSB EM-2 MECHANICAL SYSTEMS CONVERSION/UPGRADE

UAA PROJECT 16-0103
ISSUED FOR CONSTRUCTION
1 FEBRUARY 2017

Drawings

GENERAL

- G1.0 COVER SHEET
- G1.1 LIFE SAFETY PLAN

CIVIL

- C1.0 ABBREVIATIONS, LEGEND, NOTES & DETAILS
- C2.0 DEMOLITION PLAN
- C3.0 SITE PLAN
- C4.0 DETAILS

STRUCTURAL

- S1.0 GENERAL NOTES
- S2.0 DETAILS

ARCHITECTURAL

- A1.1 DEMO & NEW FLOOR PLANS, AND DEMO & NEW CEILING PLANS
- A2.1 EXTERIOR BUILDING ELEVATION
- A3.1 BUILDING SECTIONS
- A3.2 WALL SECTIONS DEMO & NEW
- A4.1 INTERIOR ELEVATIONS DEMO & NEW
- A5.1 EXTERIOR DETAILS
- A6.1 DOOR & ROOM FINISH SCHEDULES, PARTITION TYPES & DETAILS
- A1.1 INTERIOR DETAILS

MECHANICAL

- M0.1 LEGEND
- M0.2 SCHEDULES
- M1.1 ENLARGED PLANS DEMO
- M2.1 ENLARGED PLANS
- M2.2 SECTIONS
- M3.1 DIAGRAMS HEATING SYSTEM
- M3.2 DIAGRAMS


ELECTRICAL

- E0.1 LEGEND
- E0.2 LIGHTING FIXTURE SCHEDULE, CALCULATIONS & ONE LINE
- E0.3 PANEL SCHEDULES
- E1.0 SITE PLAN
- E1.1 OVERALL PLAN
- E2.1 ENLARGED PLANS DEMO
- E3.1 ENLARGED PLANS

Project Details


Prime Consultant
Mechanical and Electrical Engineering
AMC Engineers, Inc.
101 E Tudor Rd, Suite 250
Anchorage, AK 99503
907-259-9100
www.amc-engineers.com

Vertical

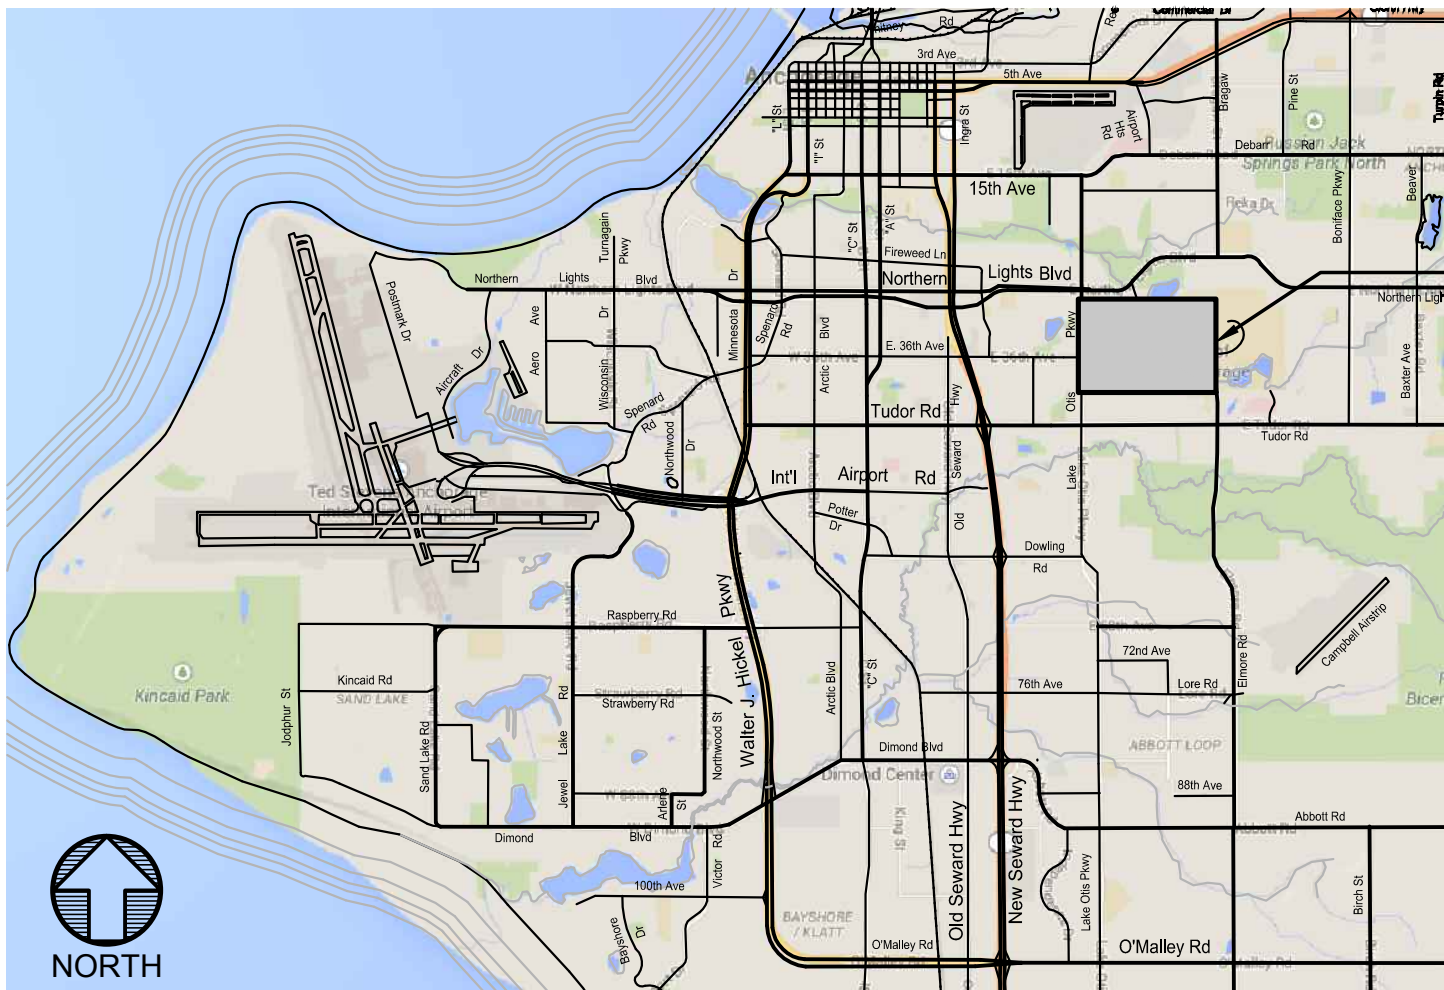


Anchorage, Alaska

Location

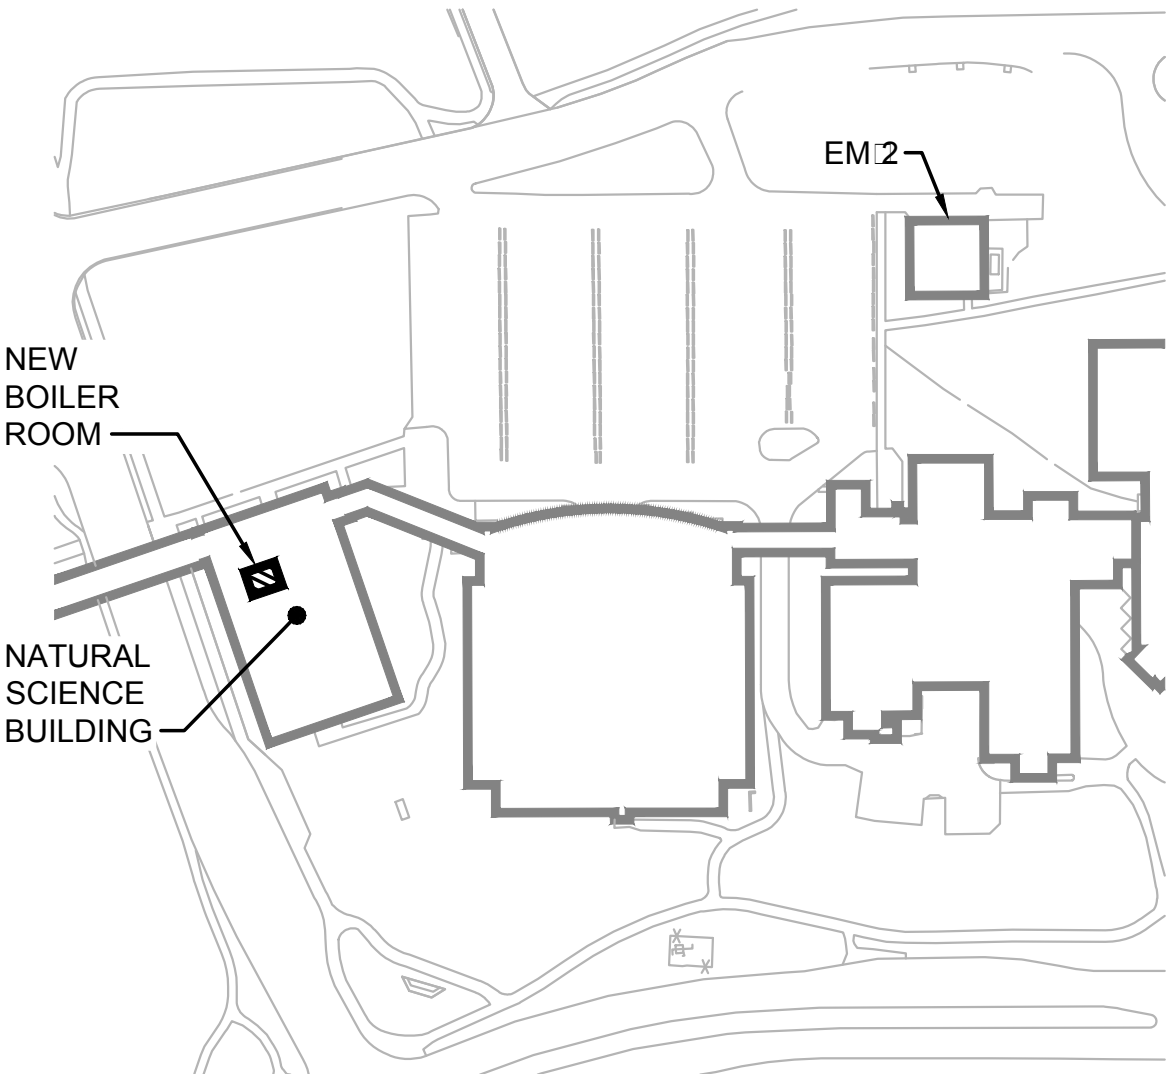

University of Alaska Anchorage Campus

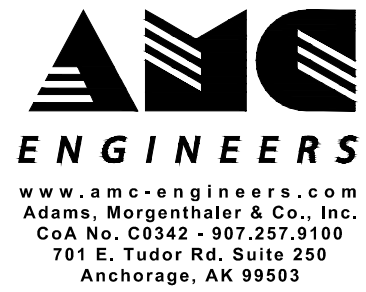

NSB EM-2 MECHANICAL SYSTEMS
CONVERSION/UPGRADE

Revisions		
No.	Date	Description
Design:	RHP	
Drawn:	ERP/MPL	
UAA Project No.:	16-0103	
Date:	02/17/2017	
Sheet Title	COVER SHEET	
Sheet Number	G1.0	

100% CONSTRUCTION DOCUMENTS