


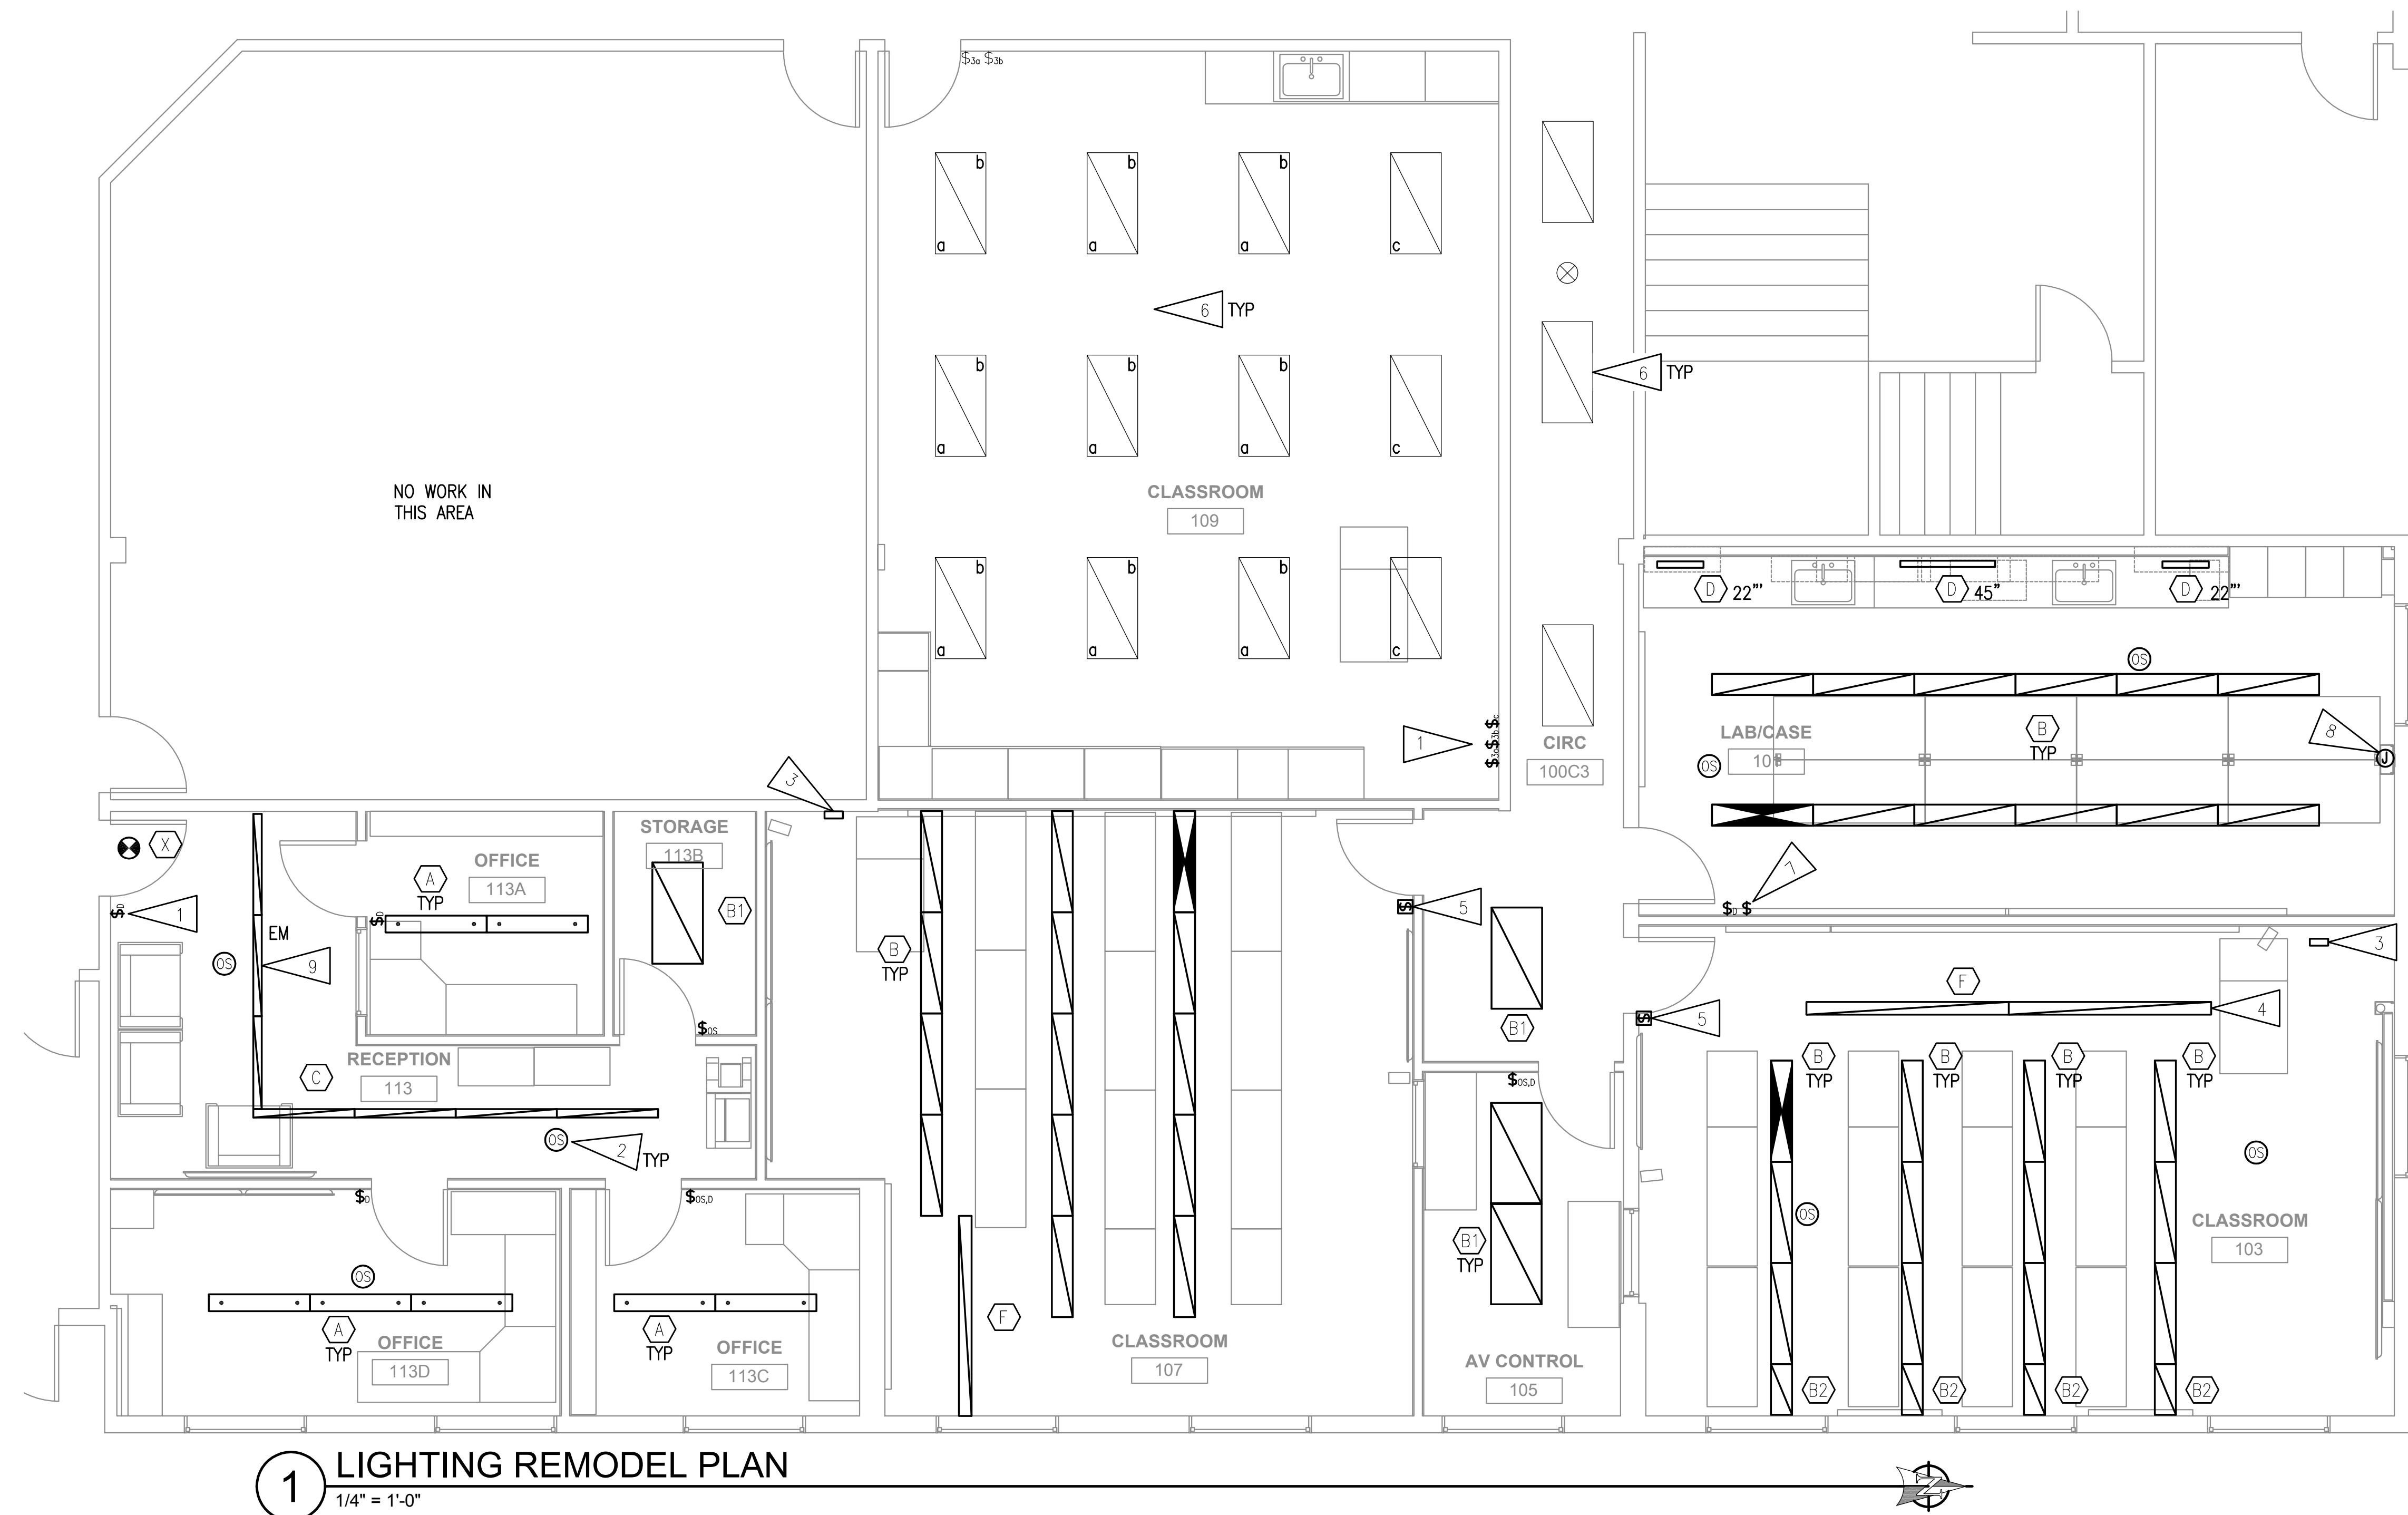


1 LIGHTING REMODEL PLAN
1/4" = 1'-0"

GENERAL NOTES:

- COORDINATE WITH ARCHITECTURAL REFLECTED CEILING PLAN FOR FINAL LOCATION OF ELECTRICAL EQUIPMENT AND DEVICES.
- CONTRACTOR SHALL COORDINATE WITH OTHER TRADES TO AVOID ANY CONFLICTS PRIOR TO ROUGH-IN CUT AND PATCH EXISTING WALL, CEILING AND FLOOR AS REQUIRED TO INSTALL NEW BRANCH CIRCUIT WIRING.
- JUNCTION BOXES IN ACCESSIBLE CEILING NOT SHOWN FOR CLARITY.
- PROVIDE GTD FOR ALL EMERGENCY LIGHTING FIXTURES AND CONNECT TO LOCAL EMERGENCY LIGHTING CIRCUIT.
- CONNECT ALL EXIT SIGNS TO LOCAL EMERGENCY LIGHTING CIRCUIT.
- CONNECT ALL NON-EMERGENCY LIGHTING TO LOCAL 277V LIGHTING CIRCUIT UNLESS OTHERWISE NOTED.
- SEE 2/E5.1 FOR CLASSROOM LIGHTING CONTROL DIAGRAM.

SHEET NOTES:

- RECONNECT LIGHT SWITCHES TO EXISTING LIGHTS.
- CEILING-MOUNTED OCCUPANCY SENSOR. DUAL-TECH LUTRON 'LOS-C' SERIES OR APPROVED EQUAL. PROVIDE POWER PACKS(S) AS NEEDED FOR CONTROL OF LIGHTS.
- NEW LIGHTING CONTROL STATION. LUTRON "GRAFIK EYE QS" OR APPROVED EQUAL.
- INSTALL WALL WASH FIXTURE WITH THE EDGE CLOSES TO THE WHITEBOARD SET BACK 30" FROM THE WALL, OR AS CLOSE AS POSSIBLE TO 30" IF CONFLICTS ARISE FROM OTHER DEVICES/TRADES.
- LOW-VOLTAGE ON/OFF SWITCH FOR CONTROL OF ALL LIGHTS IN THE SPACE. LUTRON "SEE TOUCH QS" OR APPROVED EQUAL.
- LIGHT FIXTURES TO REMAIN AS SHOWN.
- SWITCH FOR TASK LIGHTING UNDER LAB ISLAND SHELVES.
- JUNCTION BOX FOR LAB ISLAND TASK LIGHTING. LIGHTING WILL BE PROVIDED WITH FURNITURE. PROVIDE CONNECTION TO ONE OF THE 120V RECEPTACLE CIRCUITS ON THE ISLAND. AT CONTRACTOR'S OPTION, 45" VERSION OF TYPE D FIXTURE MAY BE USED INSTEAD.
- AT CONTRACTOR'S OPTION, A SINGLE SECTION OR ENTIRE LENGTH MAY BE CONNECTED TO EMERGENCY CIRCUIT.

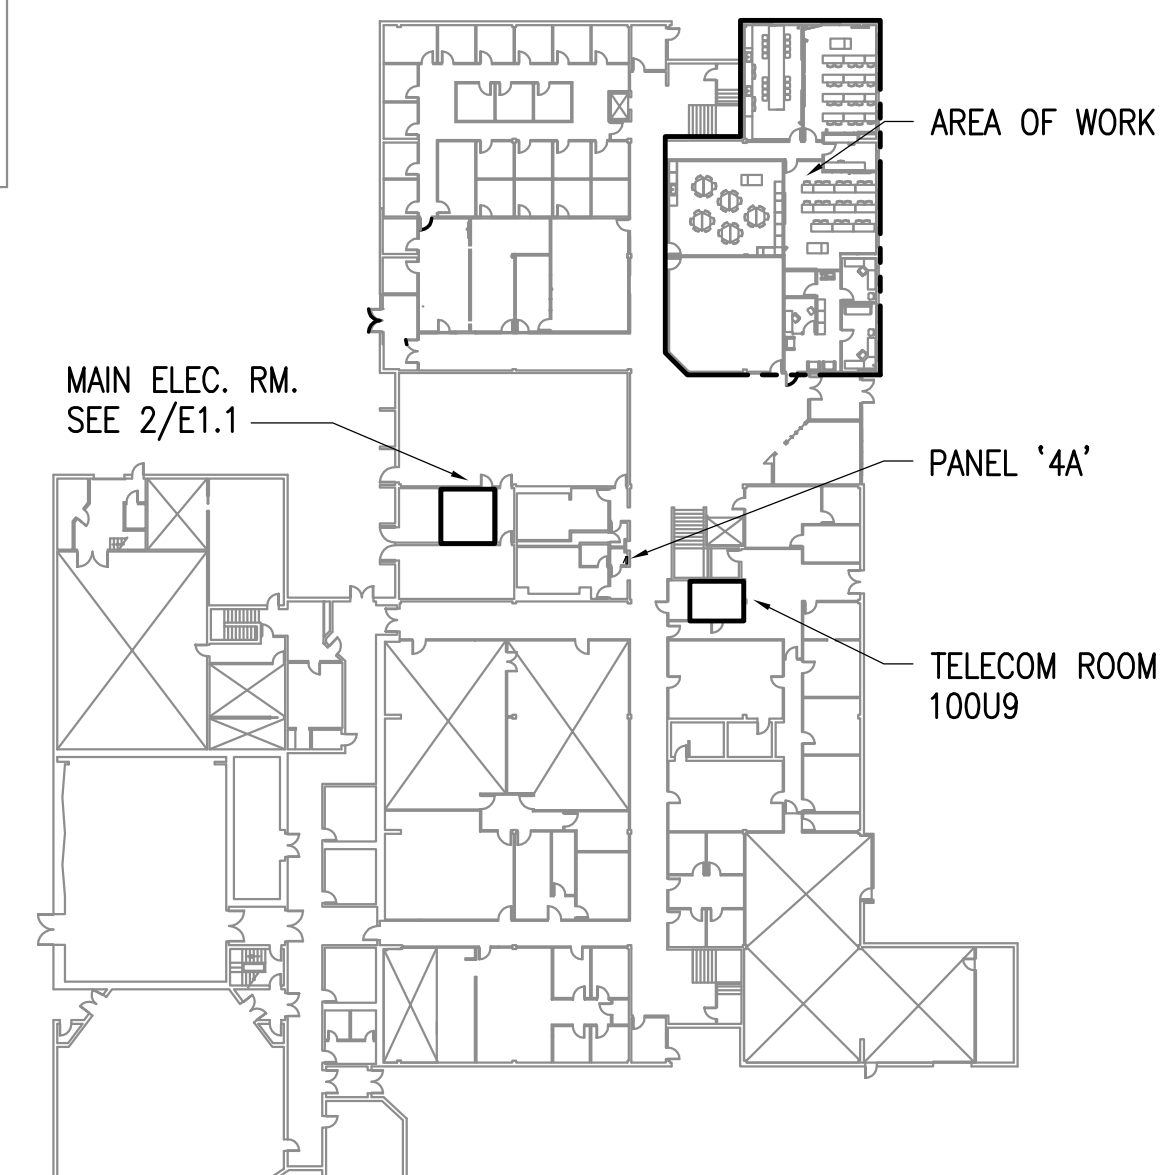

2 1ST FLOOR KEY PLAN
1" = 50'-0"


©2015 ECI/Hyer, Inc.

RS|A|Engineering, Inc.
MECHANICAL AND ELECTRICAL CONSULTING ENGINEERS
670 West Fairview Lane, Suite 200 Anchorage, AK 99503 (807) 276-0821
11000 Highway 101, Suite 101 Wasilla, AK 99567 (807) 357-1521
Corporate No.: ALEC5542

ECI/HYER ARCHITECTURE + INTERIORS
3909 Arctic Boulevard, Suite 103
ANCHORAGE, ALASKA 99503 907.561.5543
PROJECT NO. 13-008.11

UAA/ISU

**Phase II Doctor of Pharmacy Program
Tenant Improvements at the PSB Building**
CONSTRUCTION DOCUMENTS

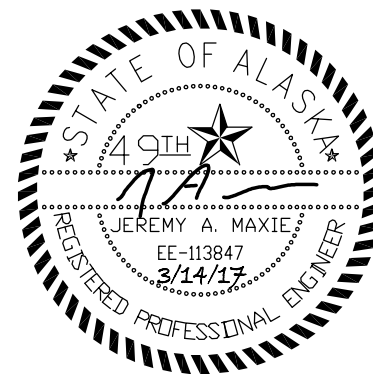

LIGHTING REMODEL

AUTHOR: JAM/RWM CHECKED: JAM/RLW
OWNER PROJECT #: L5202.10
ISSUE DATE: 3-14-17
REVISION: