

2 FORCED WASTE PLAN
1/16" = 1'-0"

1 PIPING REMODEL PLAN
1/4" = 1'-0"



GENERAL NOTES:

- A. HEATING BRANCH PIPING TO BE 3/4" UNLESS OTHERWISE INDICATED.
- B. CONNECT NEW BRANCH PIPING TO EXISTING HEATING SUPPLY AND RETURN MAINS IN CEILING SPACE.

SHEET NOTES:

1. CONNECT NEW VENT, HOT AND COLD DOMESTIC WATER PIPING AT EXISTING AT SINK.
2. 3/4" CONDENSATE FROM AC-1. CONNECT TO WASTE TAIL PIECE OF P-2.
3. CONCEAL PIPING WITHIN NEW CHASE. FOR CHASE DETAILS SEE ARCHITECTURAL.
4. 1/2" HW/CW DN TO OFCI DISHWASHER. CONNECT DISHWASHER DISCHARGE TO AIR GAP FITTING AT P-1.

5. PROVIDE FORCED WASTE LINE FROM LIFT STATION, LS-1, TO EXISTING BATHROOM MAIN APPROXIMATELY 150 FEET AWAY. SEAL ALL WALL PENETRATIONS.
6. CONNECT FORCED WASTE LINE TO EXISTING 4" WASTE LINE WITHIN PLUMBING CHASE.

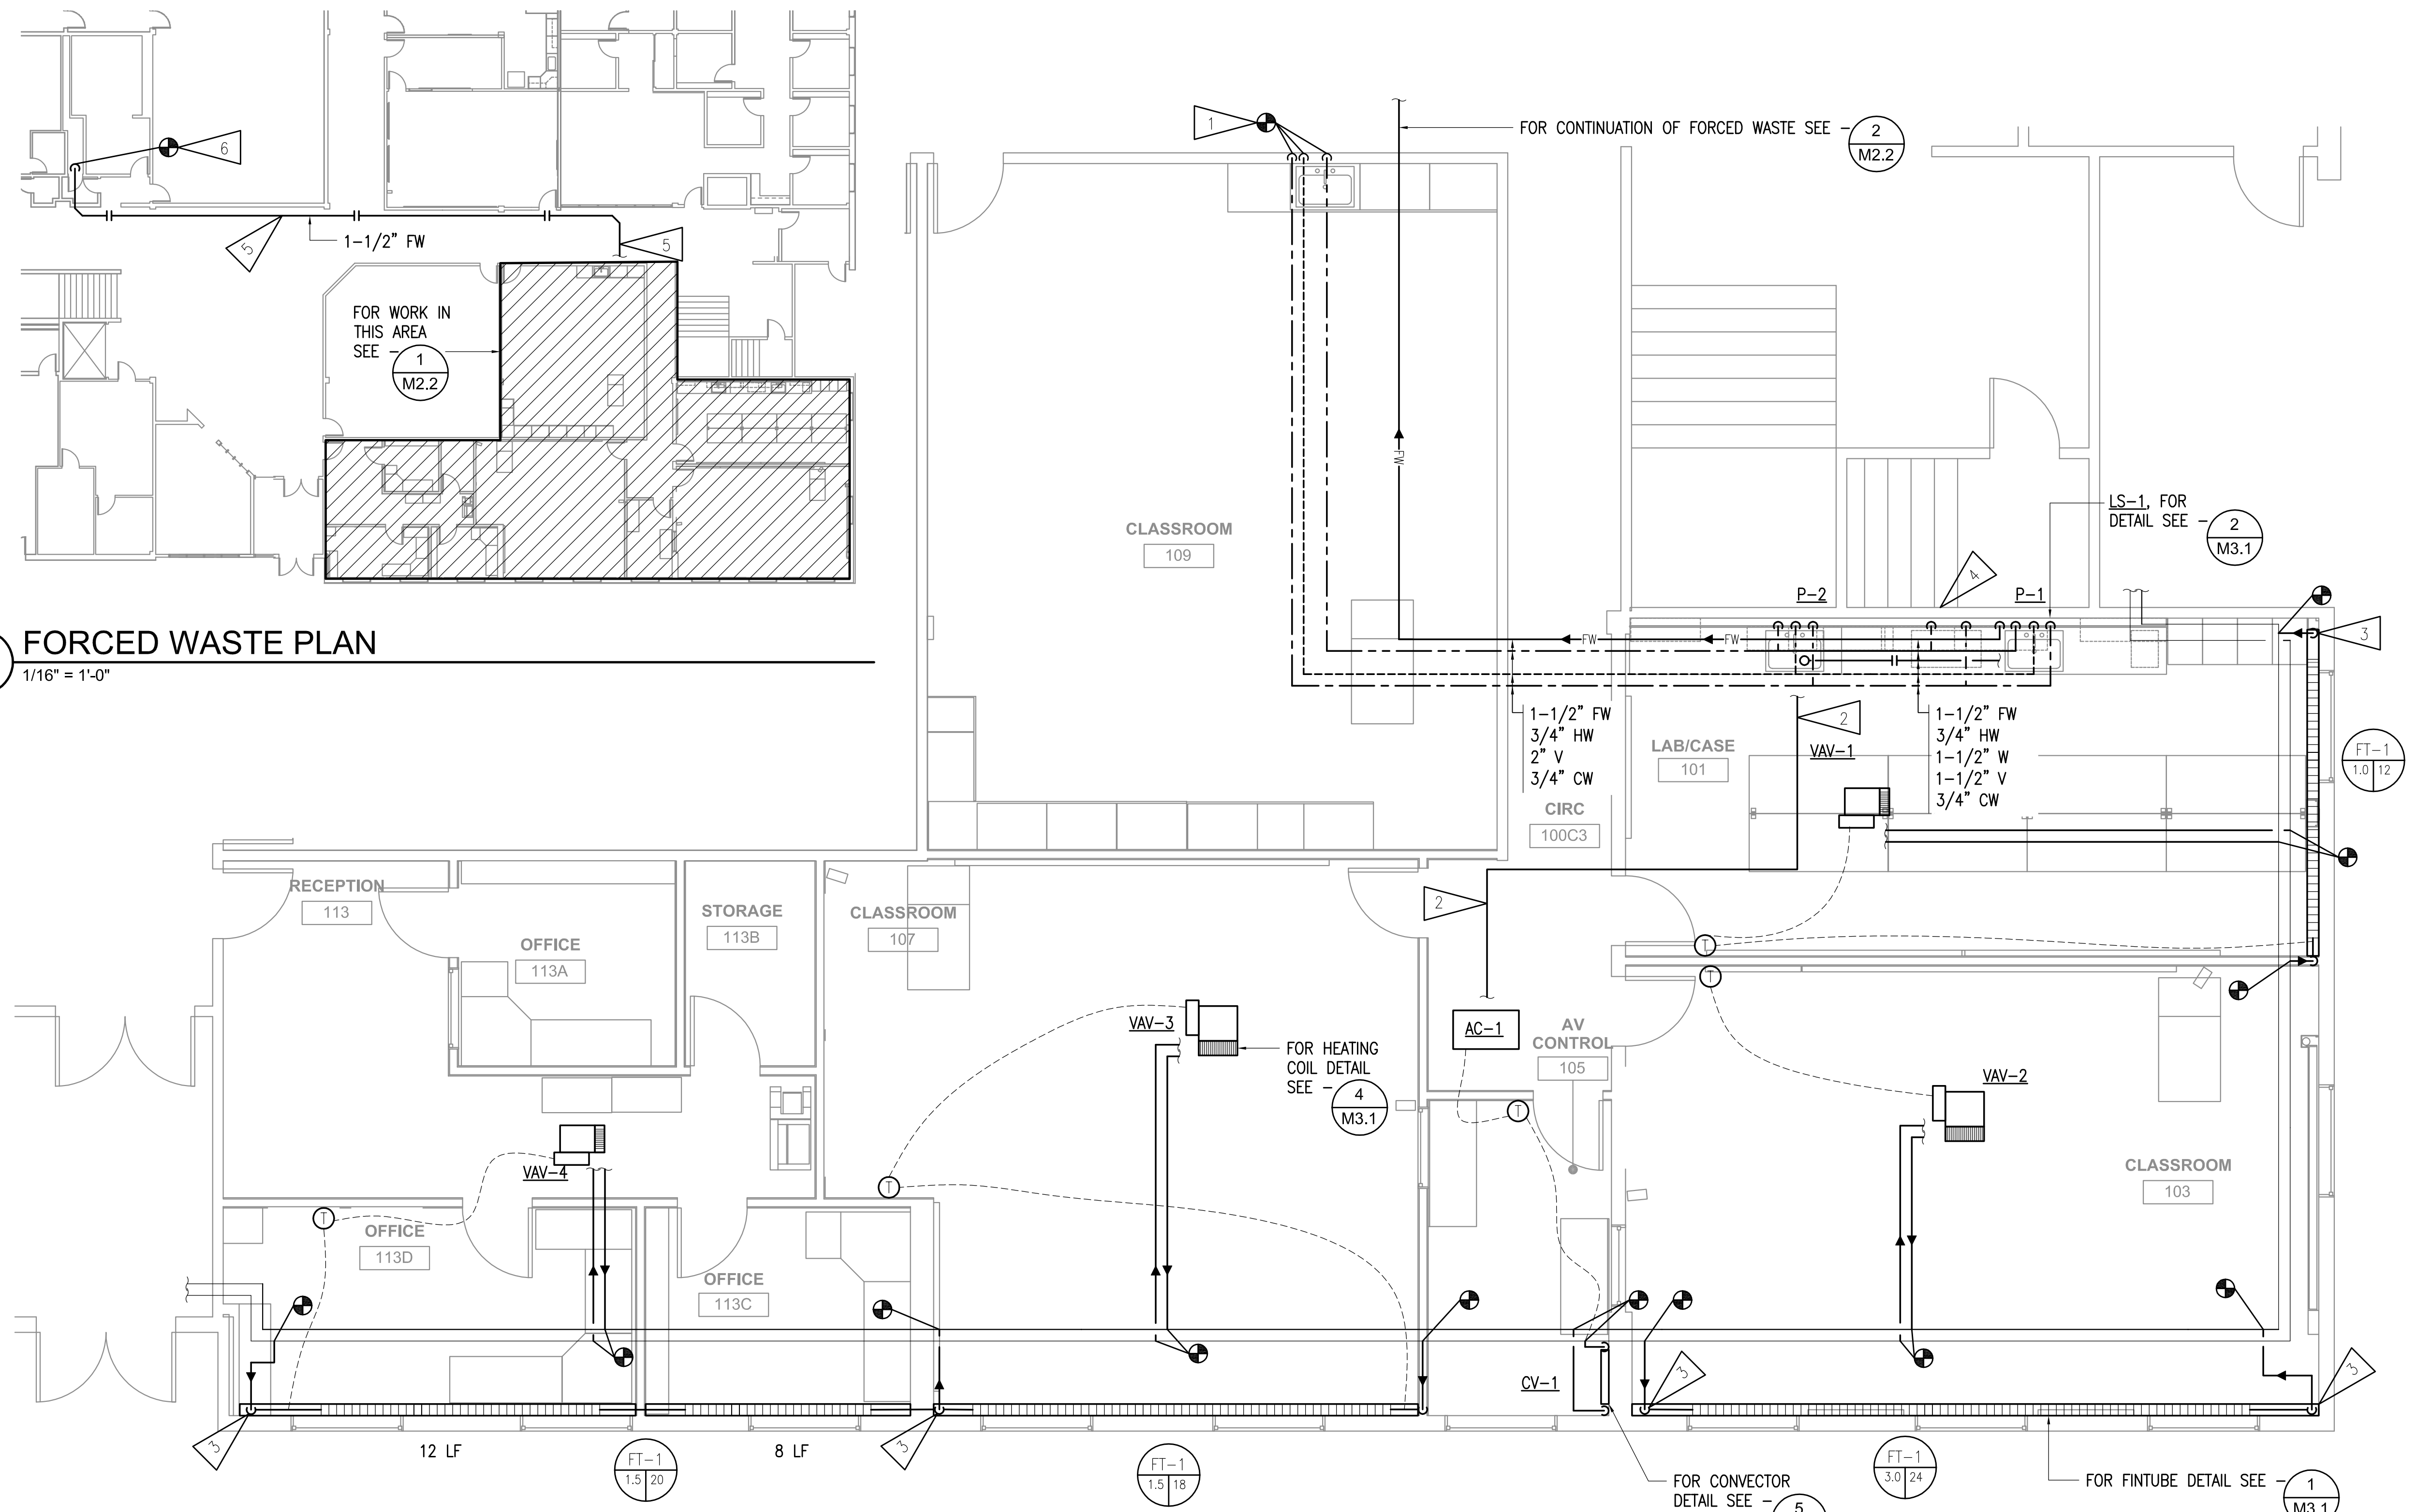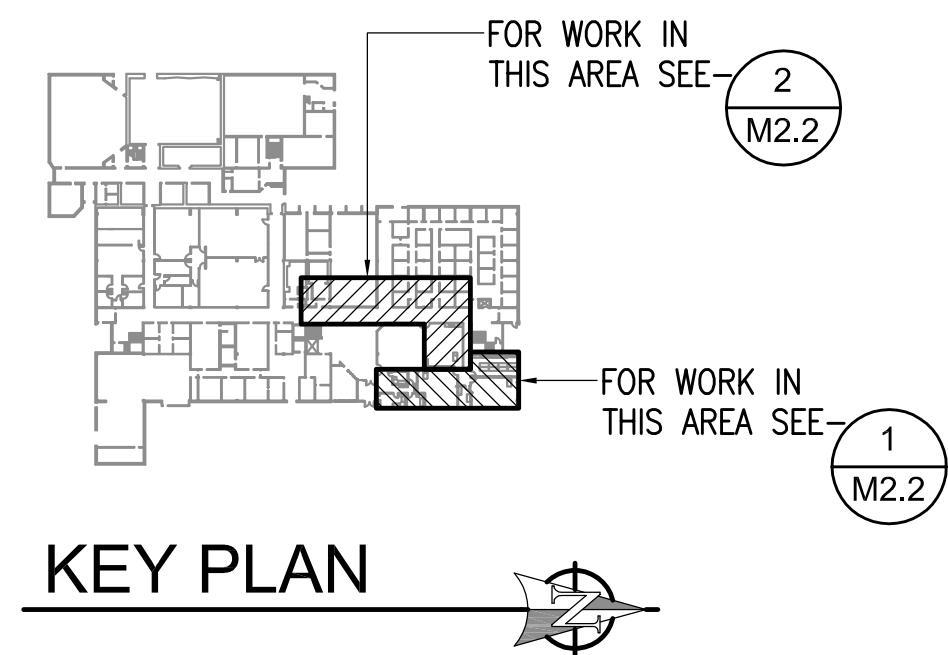

FULL SIZE PRINTED ON 22 x 34

MECHANICAL PIPING PLAN

AUTHOR: ARN
OWNER PROJECT #: L5202.10
ISSUE DATE: 3-14-17
CHECKED: DRM
REVISION:

M2.2



UAA/ISU

Phase II Doctor of Pharmacy Program
Tenant Improvements at the PSB Building

CONSTRUCTION DOCUMENTS

©2015 ECI/Hyer, Inc.

RS|A|Engineering, Inc.
MECHANICAL AND ELECTRICAL CONSULTING ENGINEERS
670 West Fireweed Lane, Suite 200 Anchorage, AK 99503 (807) 276-0021
1100 West 12th Avenue, Suite 101 Wasilla, AK 99654 (807) 357-1521
Corporate No.: AEC0542

ECI/HYER ARCHITECTURE + INTERIORS
3909 Arctic Boulevard, Suite 103
ANCHORAGE, ALASKA 99503 907.561.5543
PROJECT NO. 13-008.11