



FILE NAME: X:\17601 UABAS\A\Draws\Edwg\Sheet Files\17601 - E104.dwg
PLOTED: ejk 4/26/2017 11:50 AM

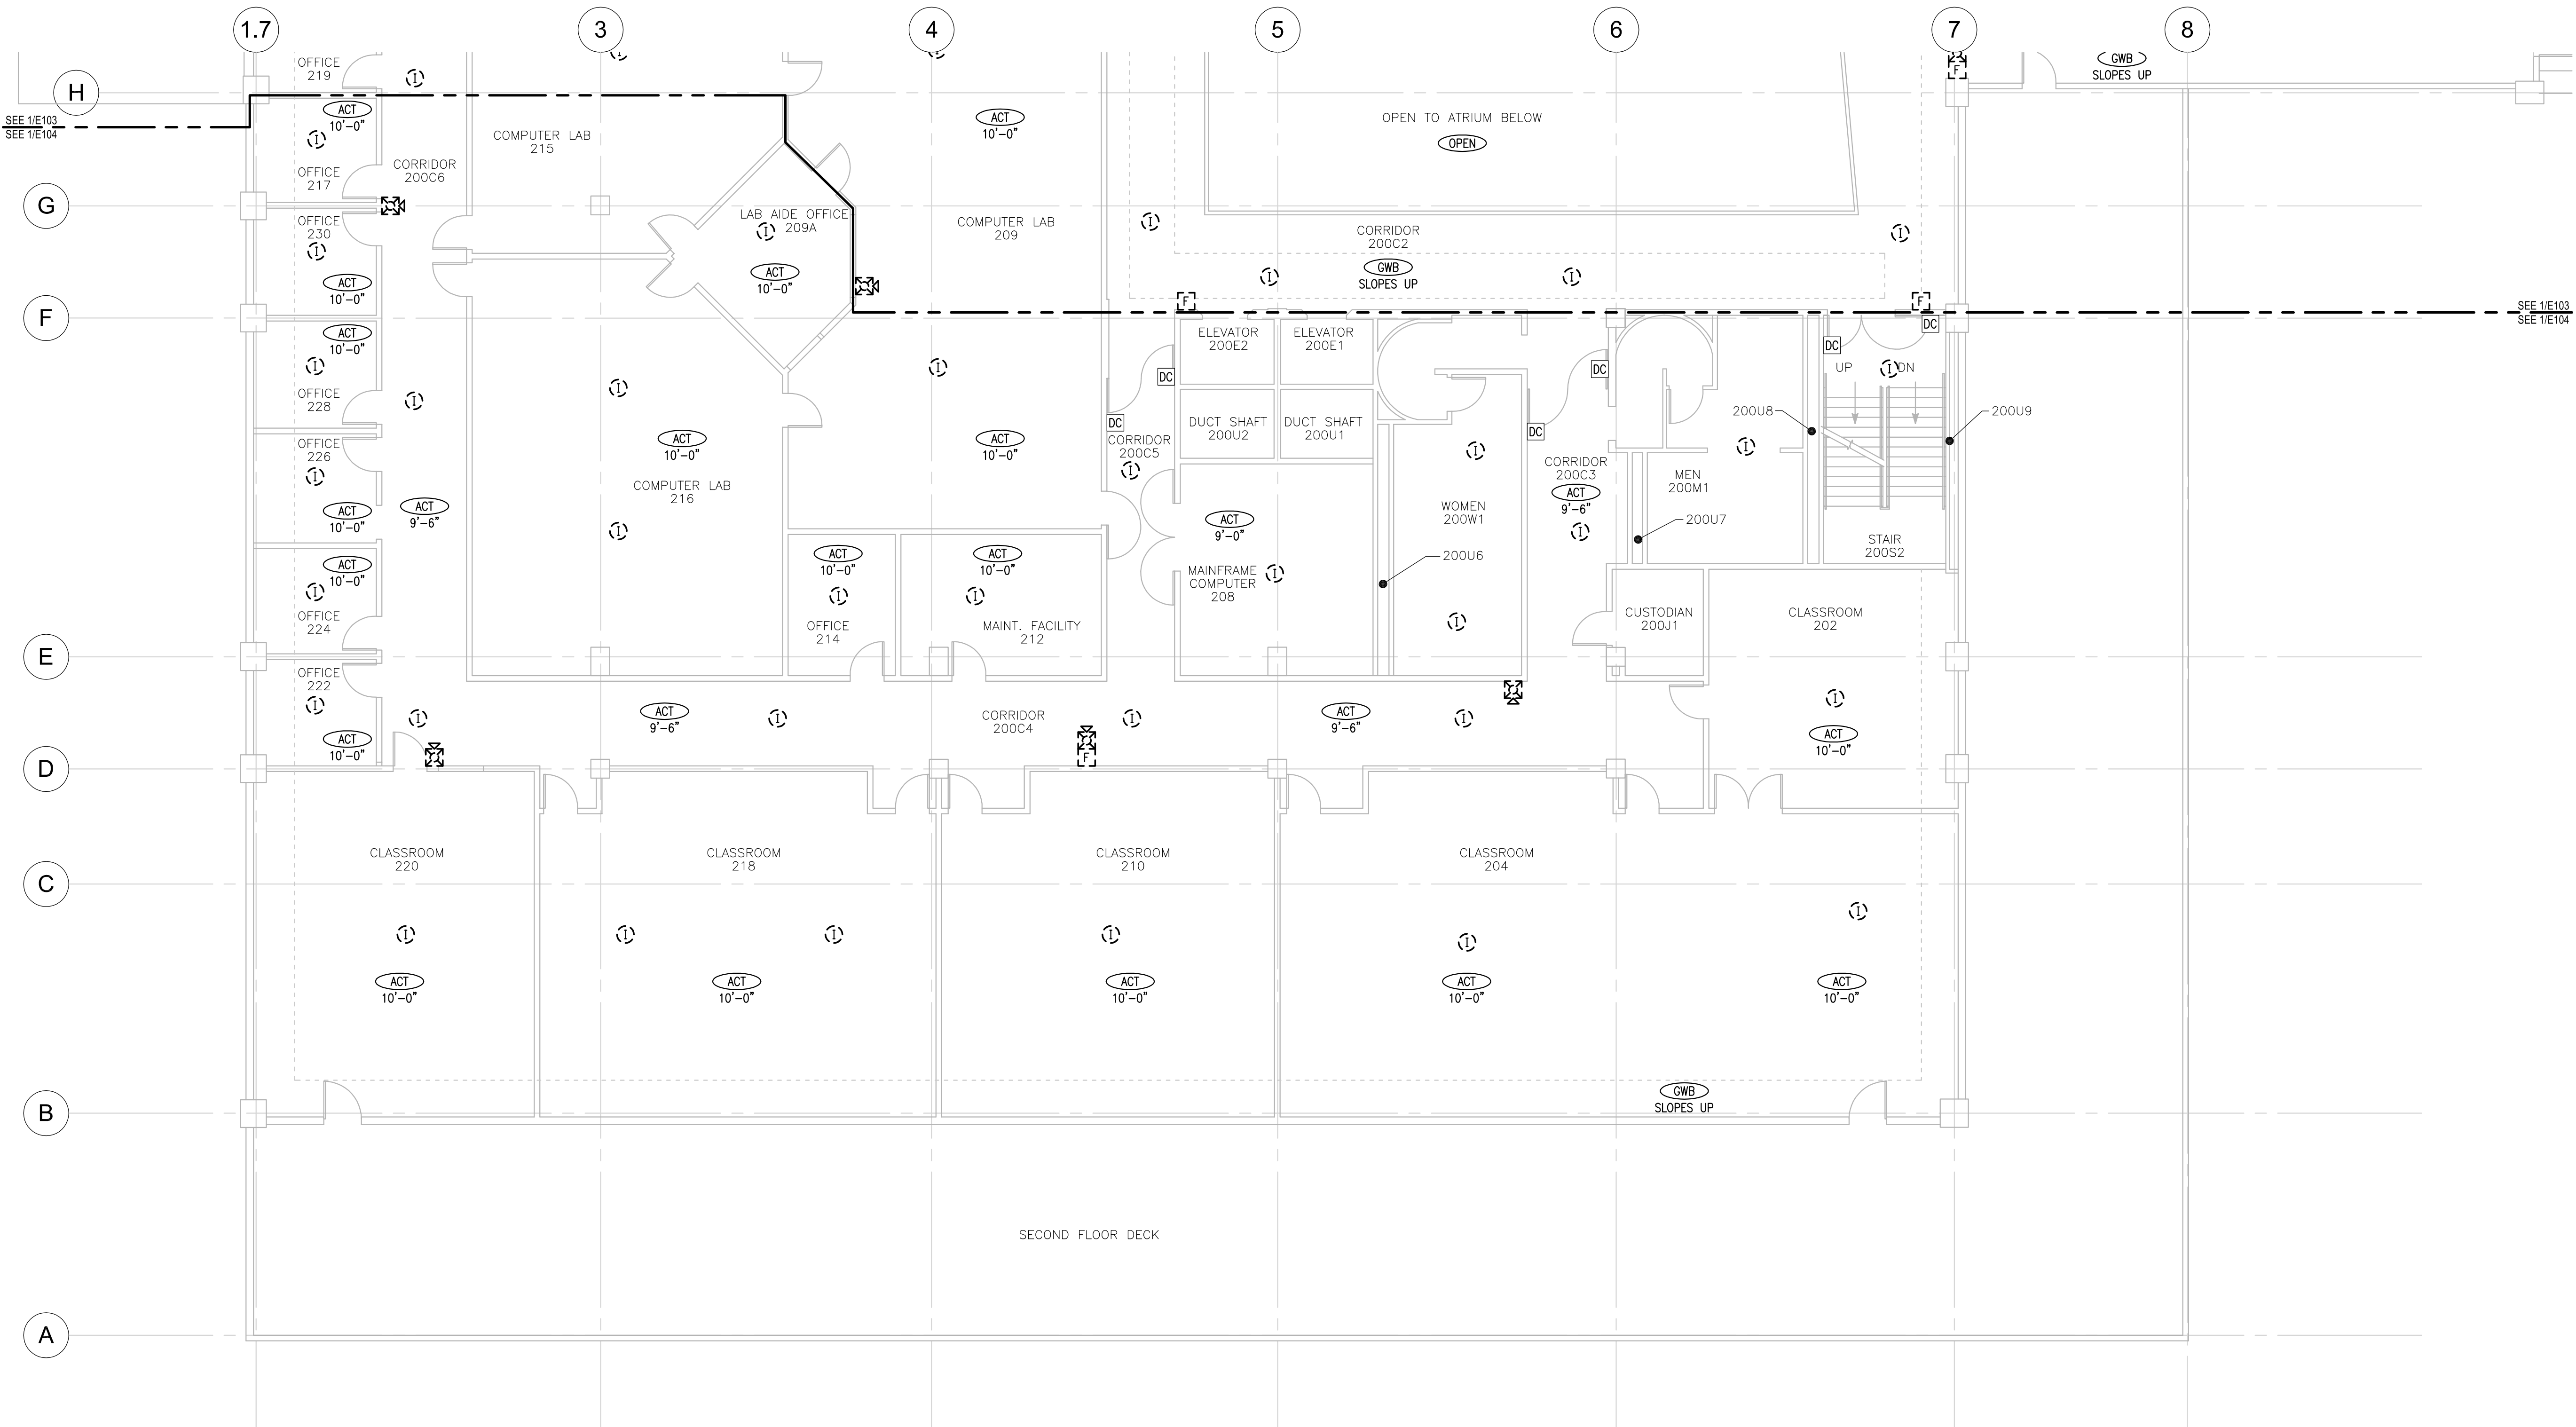

1 SECOND FLOOR PLAN SOUTH – FIRE ALARM – DEMOLITION
E104 SCALE: 1/8" = 1'-0"

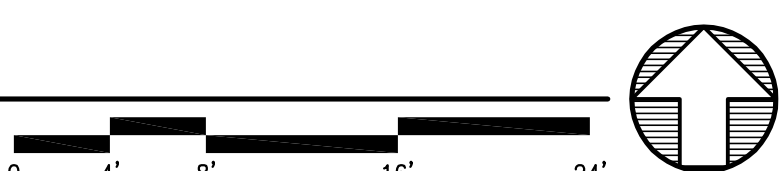

SHEET NOTES

- UNLESS OTHERWISE NOTED DEMOLISH ALL EXISTING FIRE ALARM DEVICES, APPLIANCES AND PANELS UNDER THE FIRE ALARM INSTALLATION WORK. EXISTING FIRE ALARM SYSTEM EQUIPMENT, DEVICE AND APPLIANCE QUANTITIES AND LOCATIONS SHOWN ARE BASED UPON AS-BUILT DRAWINGS AND LIMITED FIELD VERIFICATION. COORDINATE/PHASE DEMOLITION AND NEW WORK TO ENSURE THERE IS NO LAPSE OF FIRE ALARM SYSTEM COVERAGE. REFER TO SECTIONS 26 0000 ELECTRICAL GENERAL REQUIREMENTS AND 28 3100 ADDRESSABLE FIRE ALARM FOR SPECIFIC DEMOLITION AND FIRE ALARM SYSTEM REQUIREMENTS.
- EXISTING MAGNETIC DOOR HOLDERS AND DOOR CLOSERS SHALL REMAIN AND SHALL BE CONNECTED TO AND CONTROLLED BY THE NEW FIRE ALARM SYSTEM.

UNIVERSITY OF ALASKA ANCHORAGE
RASMUSON HALL FIRE ALARM REPLACEMENT
PROJECT NUMBER 17-0071

Revisions

No.	Date	Description

Design: EJK/NPS/KTR

Drawn: ERP

Date: 04/26/2017

Sheet Title

SECOND FLOOR
PLAN SOUTH - FIRE
ALARM -
DEMOLITION

Sheet Number

E104