


1. UNLESS OTHERWISE NOTED DEMOLISH ALL EXISTING FIRE ALARM DEVICES, APPLIANCES AND PANELS UNDER THE FIRE ALARM INSTALLATION WORK. EXISTING FIRE ALARM SYSTEM EQUIPMENT, DEVICE AND APPLIANCE QUANTITIES AND LOCATIONS SHOWN ARE BASED UPON AS-BUILT DRAWINGS AND LIMITED FIELD VERIFICATION. COORDINATE/PHASE DEMOLITION AND NEW WORK TO ENSURE THERE IS NO LAPSE OF FIRE ALARM SYSTEM COVERAGE. REFER TO SECTIONS 26 0000 ELECTRICAL GENERAL REQUIREMENTS AND 28 3100 ADDRESSABLE FIRE ALARM FOR SPECIFIC DEMOLITION AND FIRE ALARM SYSTEM REQUIREMENTS.
2. EXISTING MAGNETIC DOOR HOLDERS AND DOOR CLOSERS SHALL REMAIN AND SHALL BE CONNECTED TO AND CONTROLLED BY THE NEW FIRE ALARM SYSTEM.

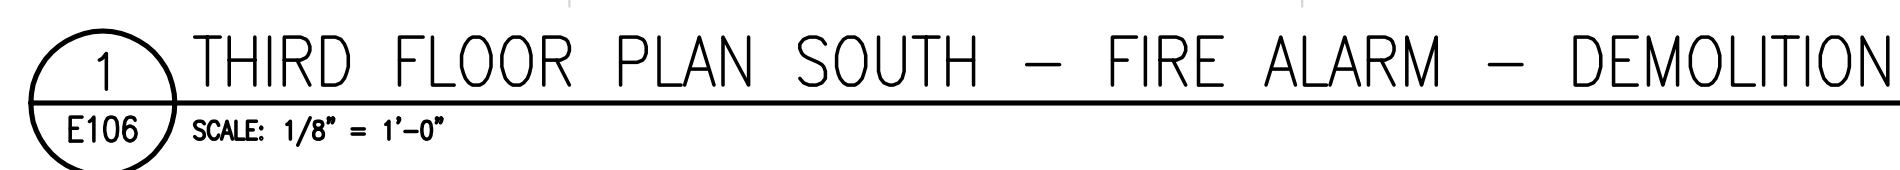

Revisions		
No.	Date	Description

Design: EJK/NPS/KTR
Drawn: ERP
Date: 04/26/2017

Sheet Title

THIRD FLOOR PLAN EAST - FIRE ALARM DEMOLITION

Sheet Number