


FILE NAME: X:\17601 UABASFA\Draws\Edwg\Sheet Files\17601 - E108.dwg
PLOTED: ejk 4/26/2017 11:51 AM

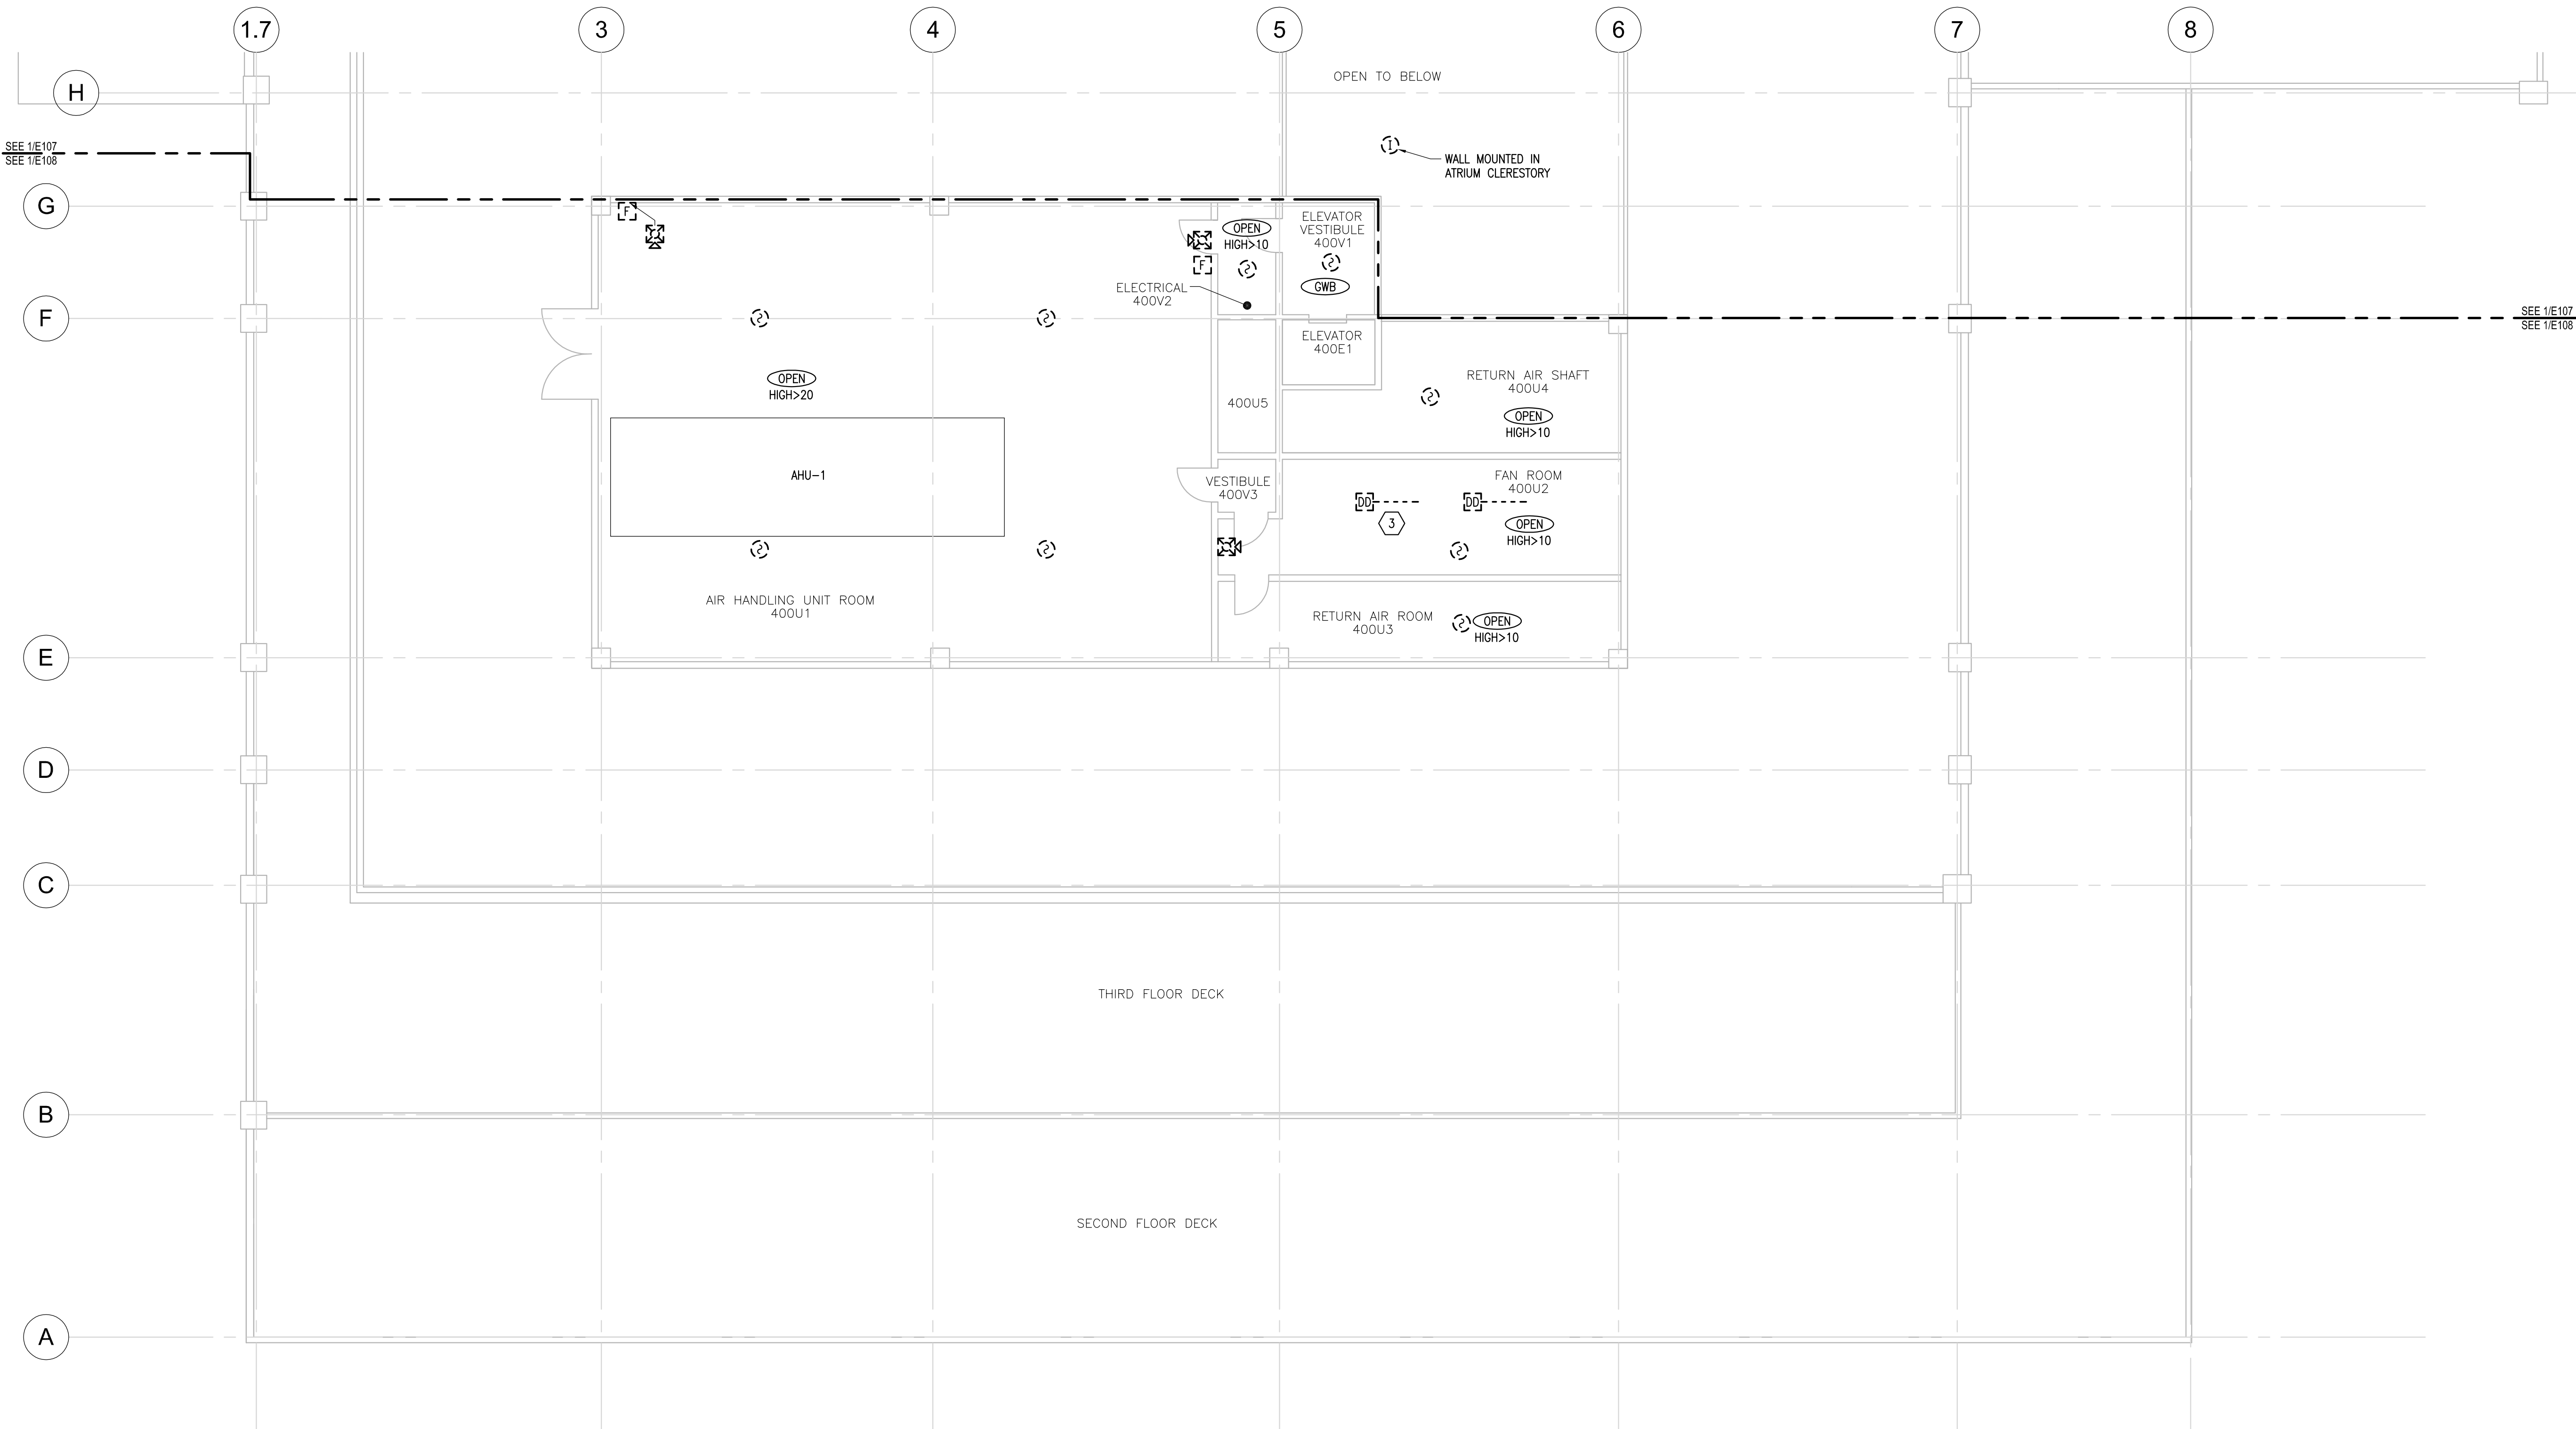

- SHEET NOTES**
1.

UNLESS OTHERWISE NOTED DEMOLISH ALL EXISTING FIRE ALARM DEVICES, APPLIANCES AND PANELS UNDER THE FIRE ALARM INSTALLATION WORK. EXISTING FIRE ALARM SYSTEM EQUIPMENT, DEVICE AND APPLIANCE QUANTITIES AND LOCATIONS SHOWN ARE BASED UPON AS-BUILT DRAWINGS AND LIMITED FIELD VERIFICATION. COORDINATE/PHASE DEMOLITION AND NEW WORK TO ENSURE THERE IS NO LAPSE OF FIRE ALARM SYSTEM COVERAGE. REFER TO SECTIONS 26 0000 ELECTRICAL GENERAL REQUIREMENTS AND 28 3100 ADDRESSABLE FIRE ALARM FOR SPECIFIC DEMOLITION AND FIRE ALARM SYSTEM REQUIREMENTS.
2.

EXISTING MAGNETIC DOOR HOLDERS AND DOOR CLOSERS SHALL REMAIN AND SHALL BE CONNECTED TO AND CONTROLLED BY THE NEW FIRE ALARM SYSTEM.
3.

DEMOLISH EXISTING RETURN AIR DUCT DETECTOR ACROSS RETURN AIR OPENING AT SILENCERS.

www.smc-engineers.com
Adams, Morgenthaler & Co., Inc.
CoA No. C0342 - 907.257.9100
701 E. Tudor Rd, Suite 200
Anchorage, AK 99503

© 17601

UNIVERSITY OF ALASKA ANCHORAGE
RASMUSON HALL FIRE ALARM REPLACEMENT
PROJECT NUMBER 17-0071

Revisions		
No.	Date	Description
Design: EJK/NPS/KTR		
Drawn: ERP		
Date: 04/26/2017		
Sheet Title		
FOURTH FLOOR PLAN SOUTH - FIRE ALARM - DEMOLITION		
Sheet Number		

E108