


0"
1"
2"
3"

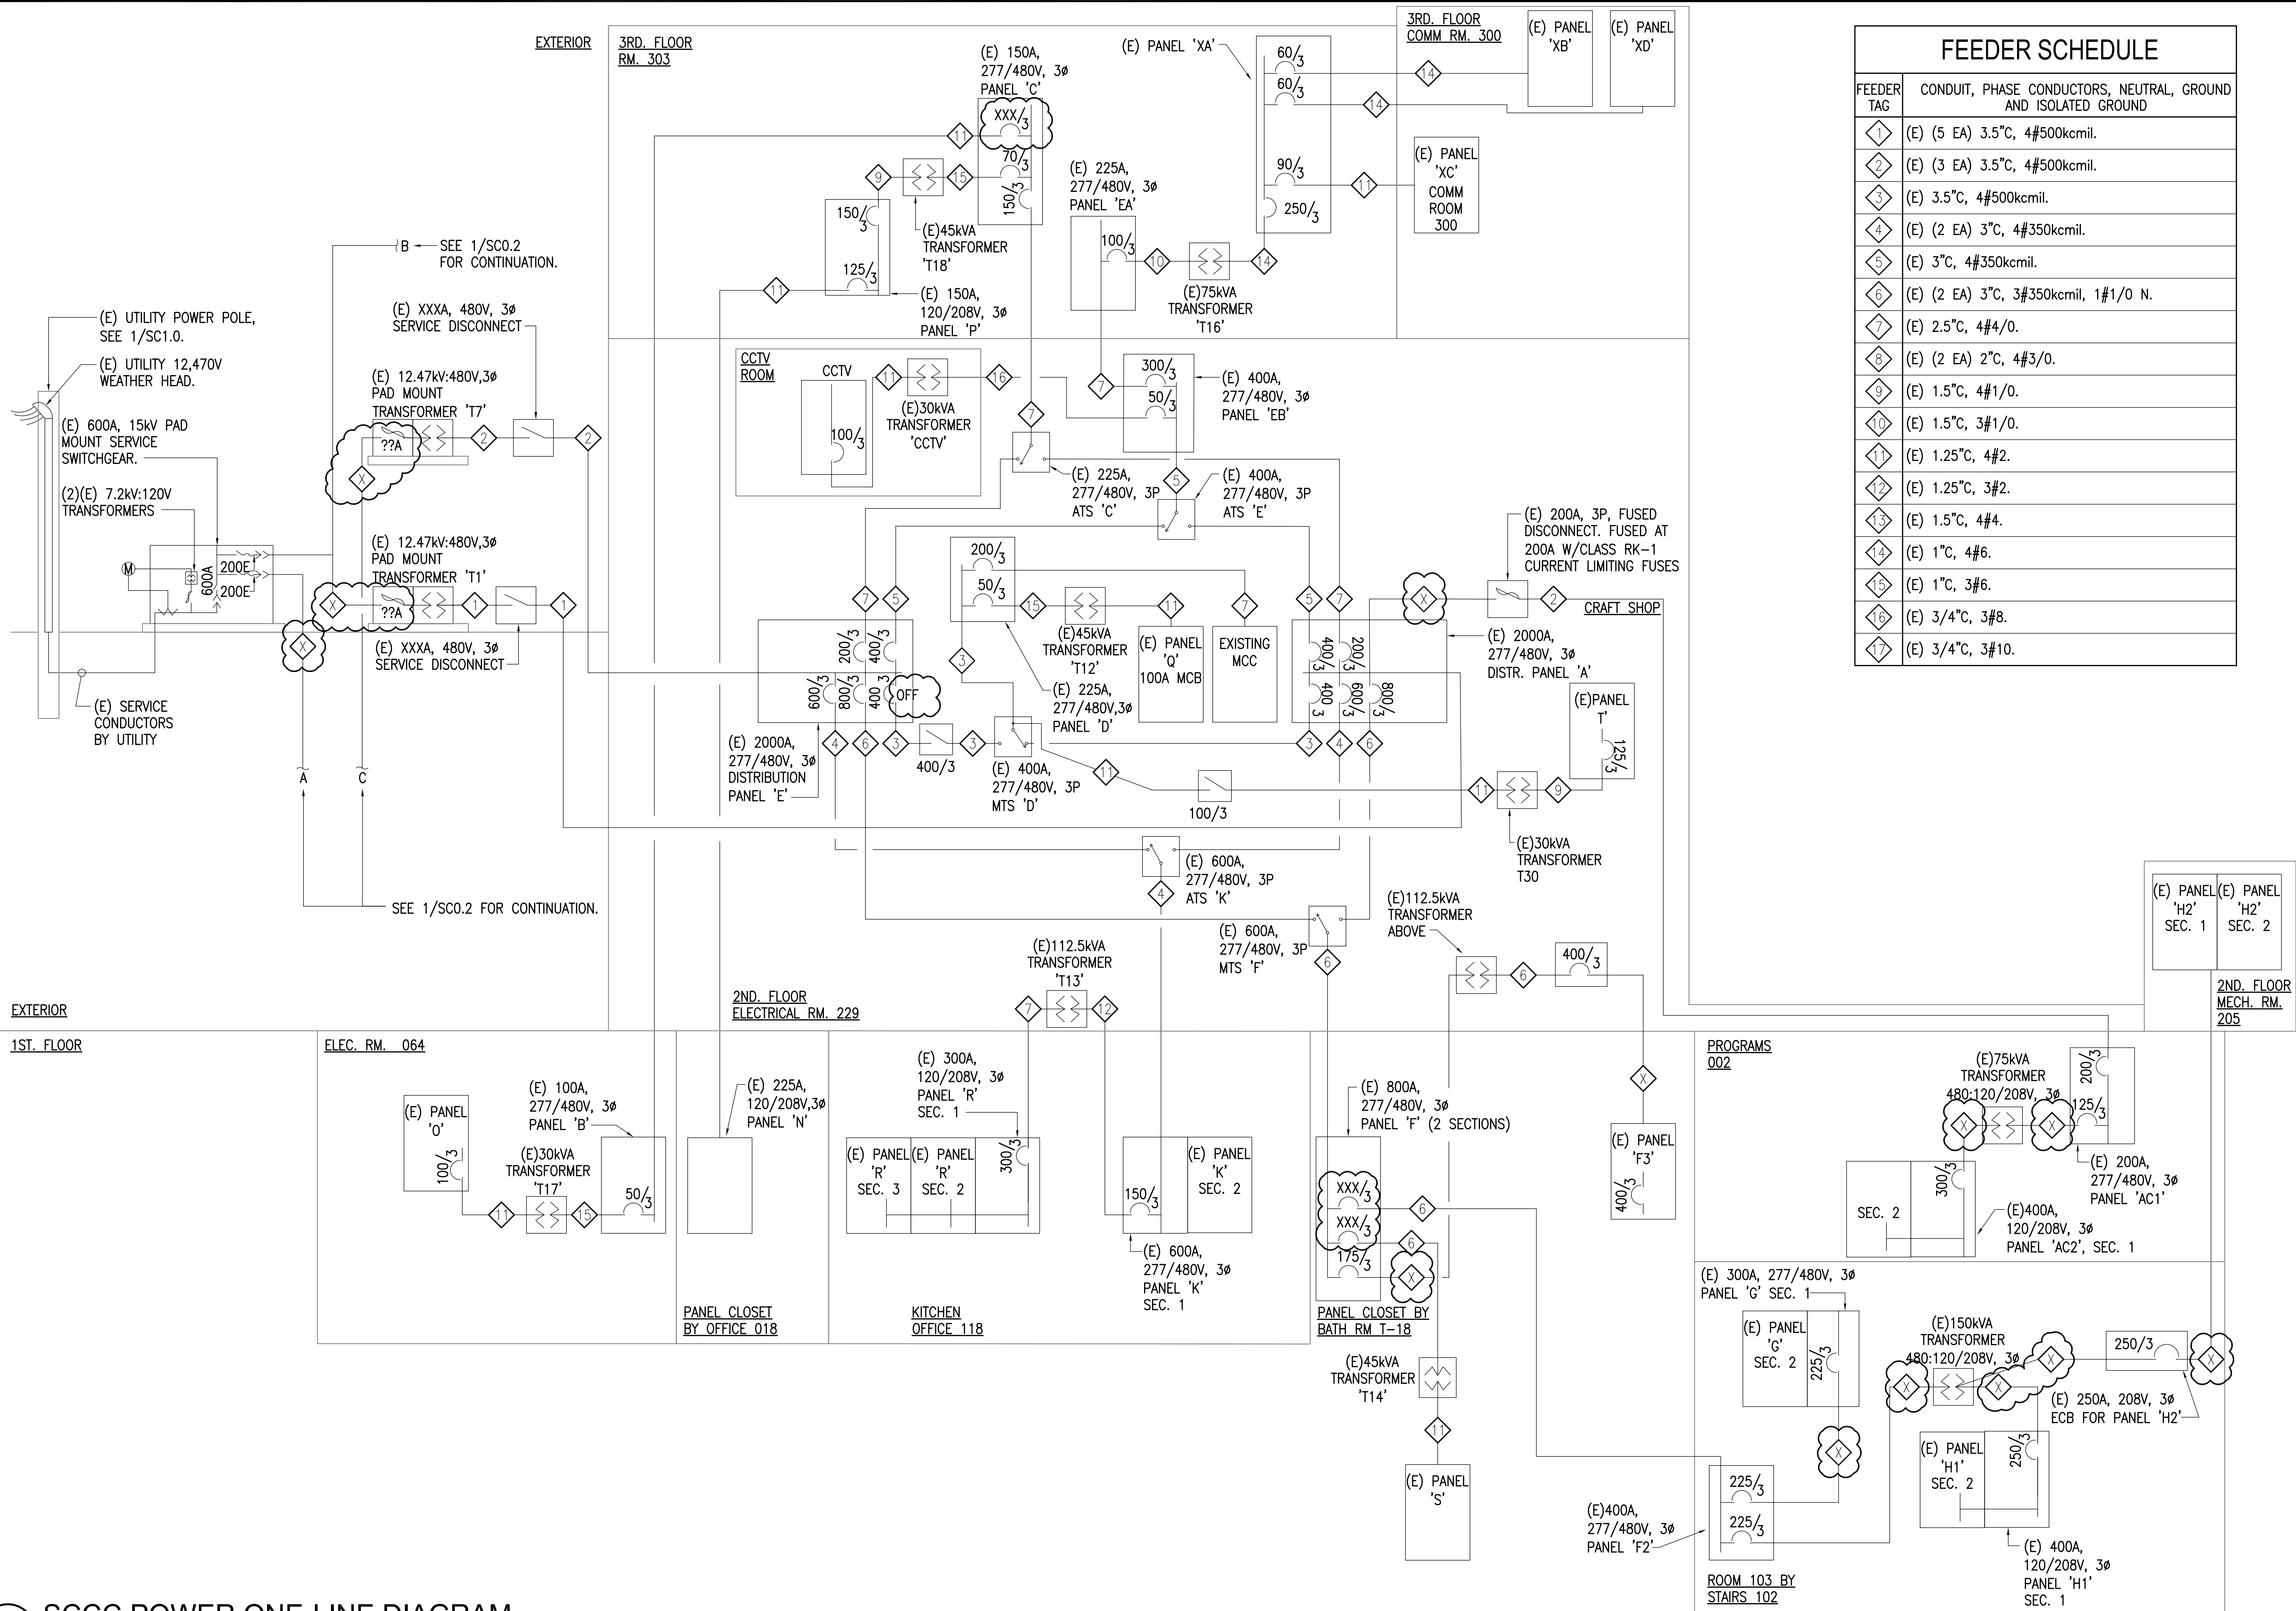


REFERENCE
ONLY

ELECTRICAL ENGINEER
RSA ENGINEERING, INC.
670 W. Fireweed Ln., Suite 200
Anchorage, AK 99503-2516
Phone (907) 276-0521 Fax (907) 276-1751


State of Alaska
DOC Arc Flash Survey and Report
Spring Creek Correctional Center
Seward, AK

0"
1"
2"
3"

SEE 1/SC0.1 FOR CONTINUATION.

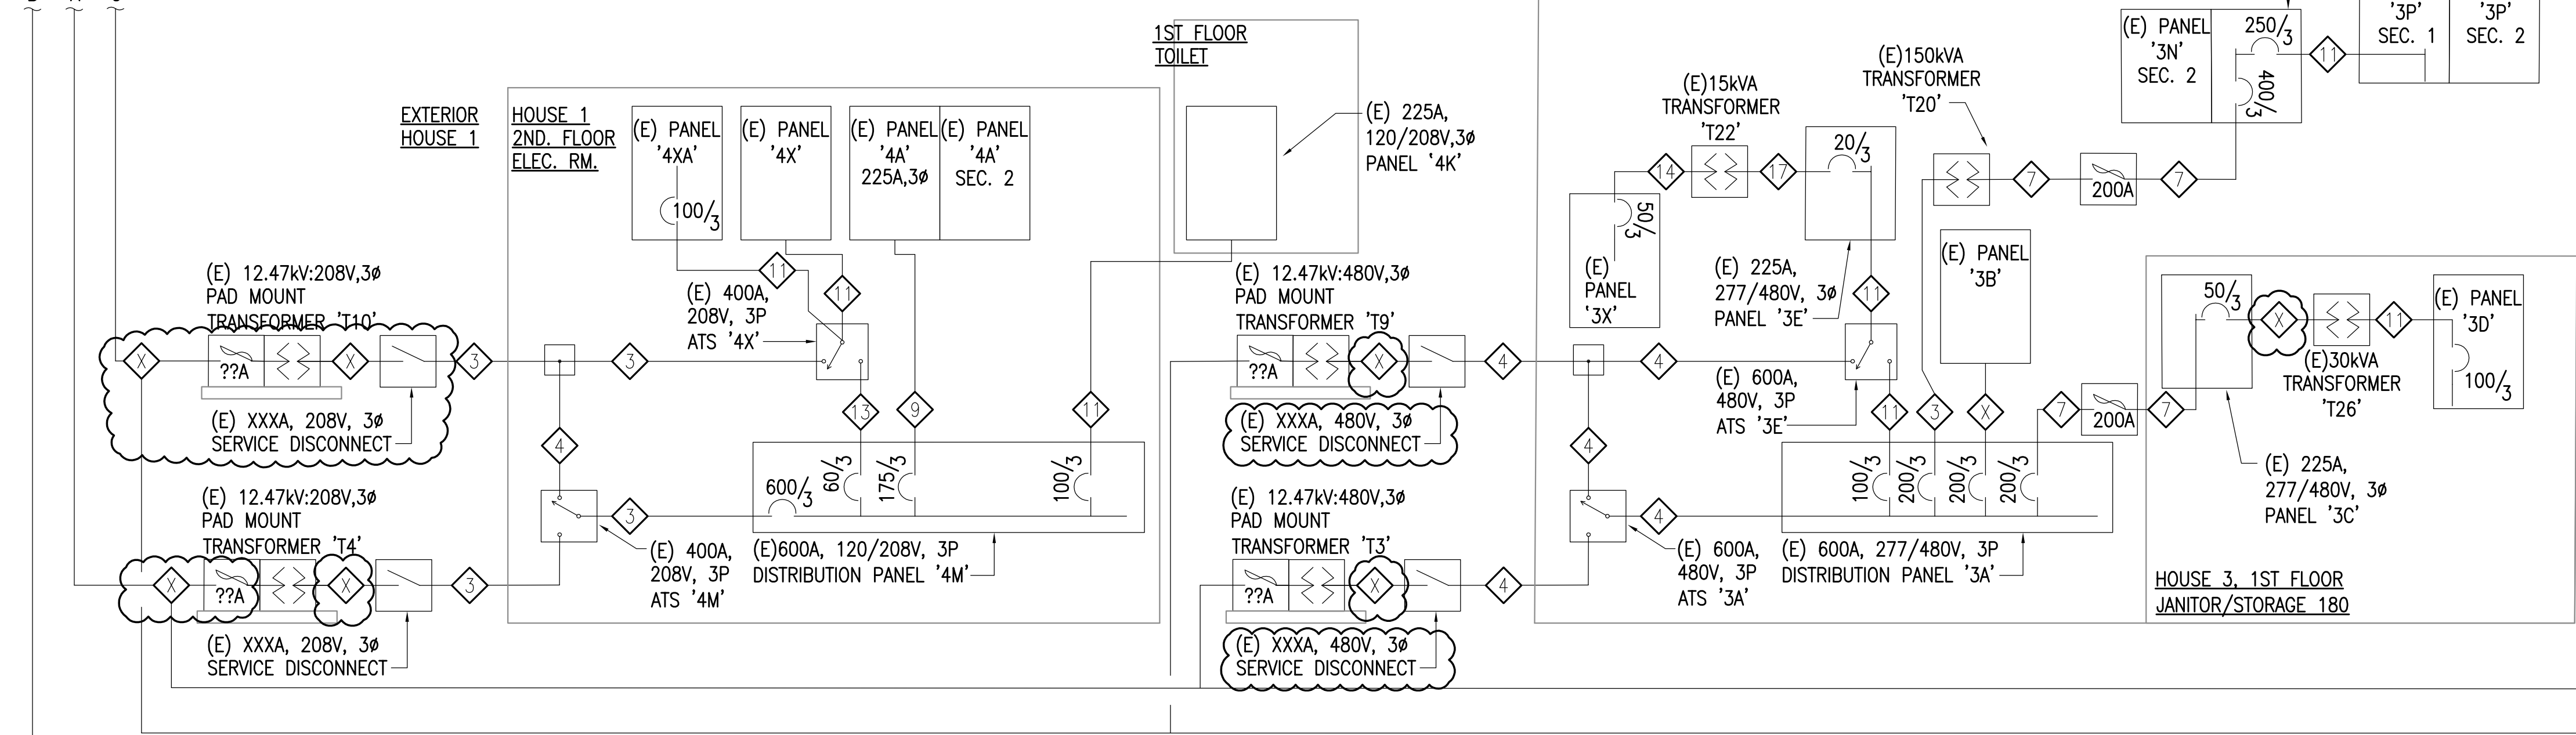

FEEDER SCHEDULE	
FEEDER TAG	CONDUIT, PHASE CONDUCTORS, NEUTRAL, GROUND AND ISOLATED GROUND
1	(E) (5 EA) 3.5"C, 4#500kcmil.
2	(E) (3 EA) 3.5"C, 4#500kcmil.
3	(E) 3.5"C, 4#500kcmil.
4	(E) (2 EA) 3"C, 4#350kcmil.
5	(E) 3"C, 4#350kcmil.
6	(E) (2 EA) 3"C, 3#350kcmil, 1#1/0 N.
7	(E) 2.5"C, 4#4/0.
8	(E) (2 EA) 2"C, 4#3/0.
9	(E) 1.5"C, 4#1/0.
10	(E) 1.5"C, 3#1/0.
11	(E) 1.25"C, 4#2.
12	(E) 1.25"C, 3#2.
13	(E) 1.5"C, 4#4.
14	(E) 1"C, 4#6.
15	(E) 1"C, 3#6.
16	(E) 3/4"C, 3#8.
17	(E) 3/4"C, 3#10.

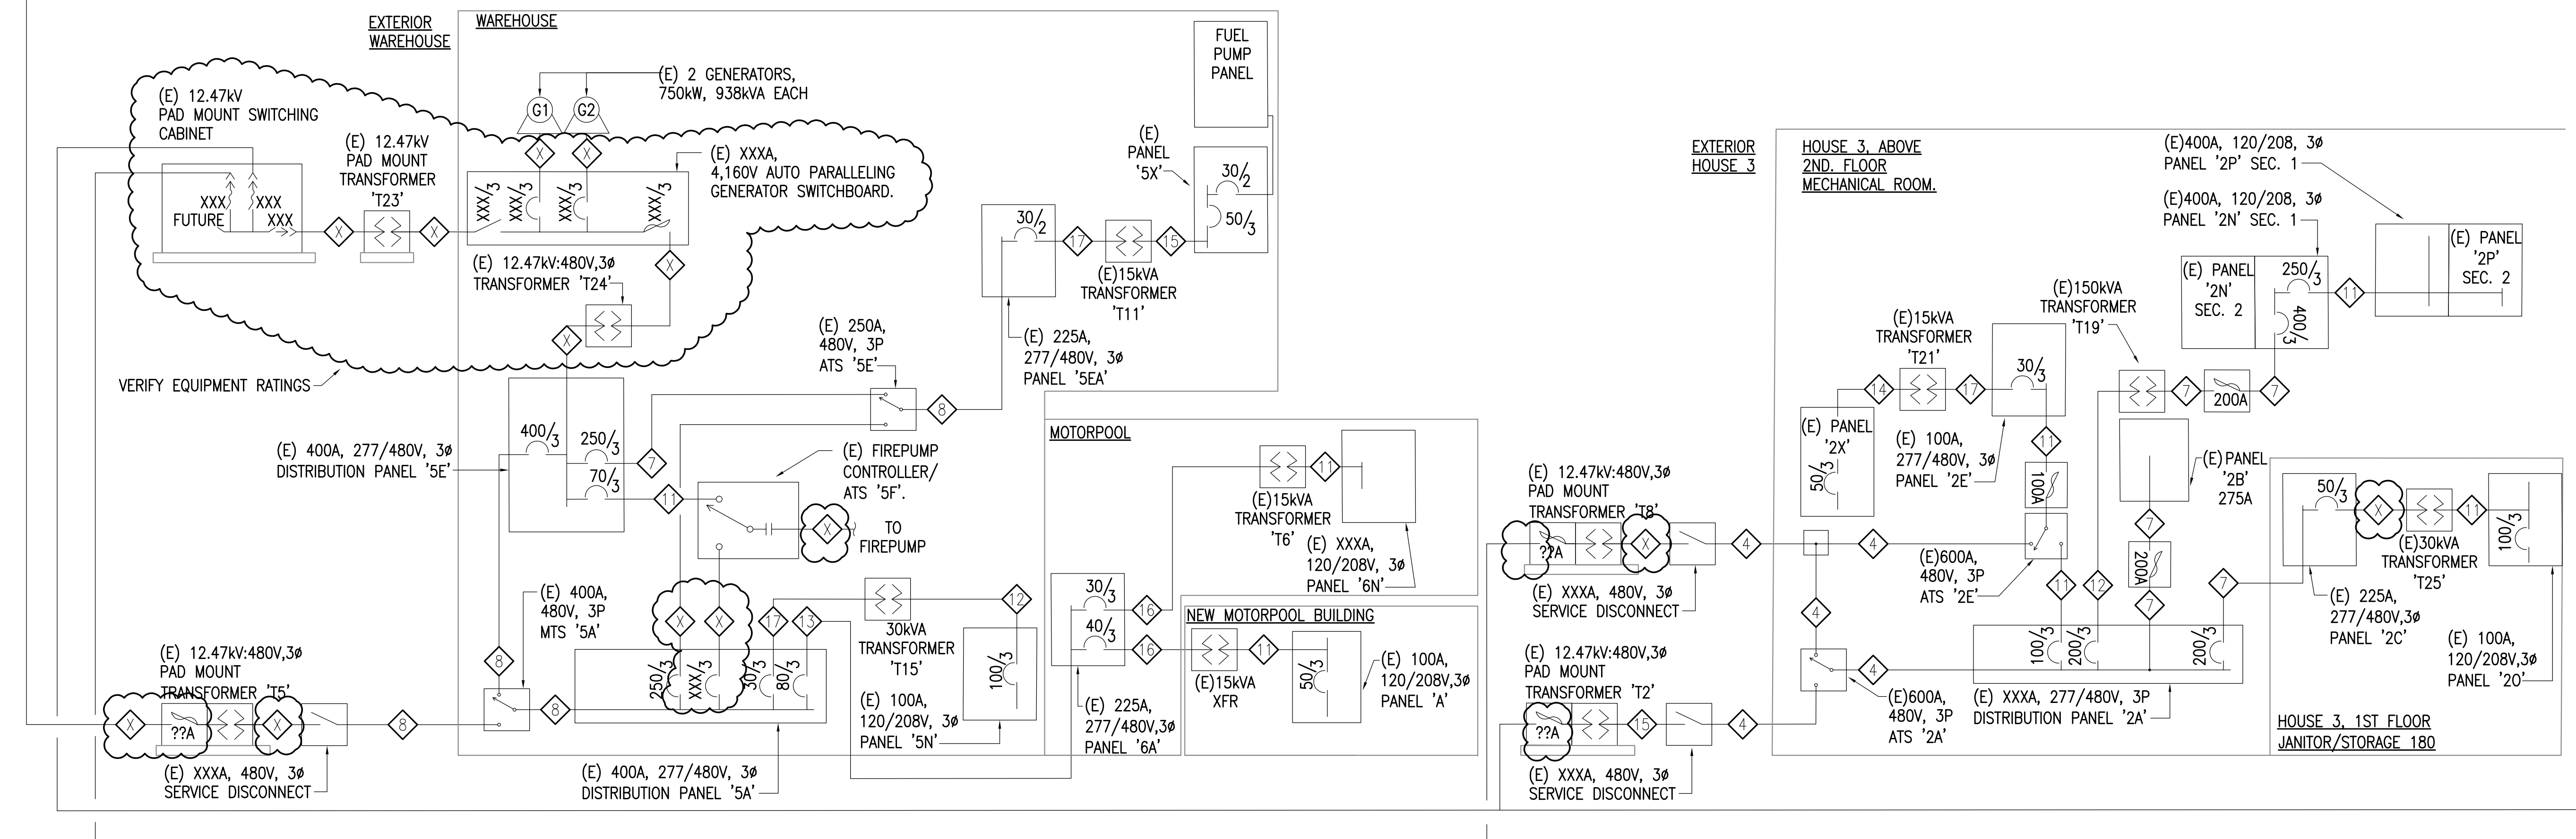

1 SCCC POWER ONE-LINE DIAGRAM CONTINUED
NTS

REFERENCE
ONLY

ELECTRICAL ENGINEER
RSA ENGINEERING, INC.
670 W. Fireweed Ln., Suite 200
Anchorage, AK 99503-2516
Phone (907) 276-0521 Fax (907) 276-1751

State of Alaska
DOC Arc Flash Survey and Report
Spring Creek Correctional Center
Seward, AK

REVISIONS:

DRAWN BY: BRE, MJC
CHECKED BY: JAM
DATE: 10/13/2017
JOB NUMBER: L6206
DWG FILE: L6206_ESERIES

DRAWING TITLE:
SCCC BUILDING POWER
ONE-LINE DIAGRAM
CONTINUED

SHEET:
SC0.2

ELECTRICAL ENGINEER
RSA ENGINEERING, INC.
670 W. Fireweed Ln., Suite 200
Anchorage, AK 99503-2516
Phone (907) 276-0521 Fax (907) 276-1751

RSA ENGINEERING, INC.
670 W. Fireweed Ln., Suite 200
Anchorage, AK 99503-2516
Phone (907) 276-0521 Fax (907) 276-1751

DOC Arc Flash Survey and Report
Spring Creek Correctional Center
Seward, AK

DRAWN BY: MJC
CHECKED BY: JAM
DATE: 10/13/2017
JOB NUMBER: L6206
DWG FILE: L6206_ESERIES

SHEET:
SC1.0



ELECTRICAL ENGINEER
RSA ENGINEERING, INC.
670 W. Fireweed Ln., Suite 200
Anchorage, AK 99503-2516
Phone (907) 276-0521 Fax (907) 276-1751

REVISIONS:

DRAWN BY: MJC
CHECKED BY: JAM
DATE: 10/13/2017
JOB NUMBER: L6206
DWG FILE: L6206_ESERIES

DRAWING TITLE:
APS BUILDING PANEL
MAP - 1ST. FLOOR

SHEET:
SC2.0




1 APS BUILDING PANEL MAP - 1ST. FLOOR
1/16" = 1'-0"

0"
1"
2"
3"

REFERENCE
ONLY

ELECTRICAL ENGINEER
RSA ENGINEERING, INC.
670 W. Fireweed Ln., Suite 200
Anchorage, AK 99503-2516
Phone (907) 276-0521 Fax (907) 276-1751

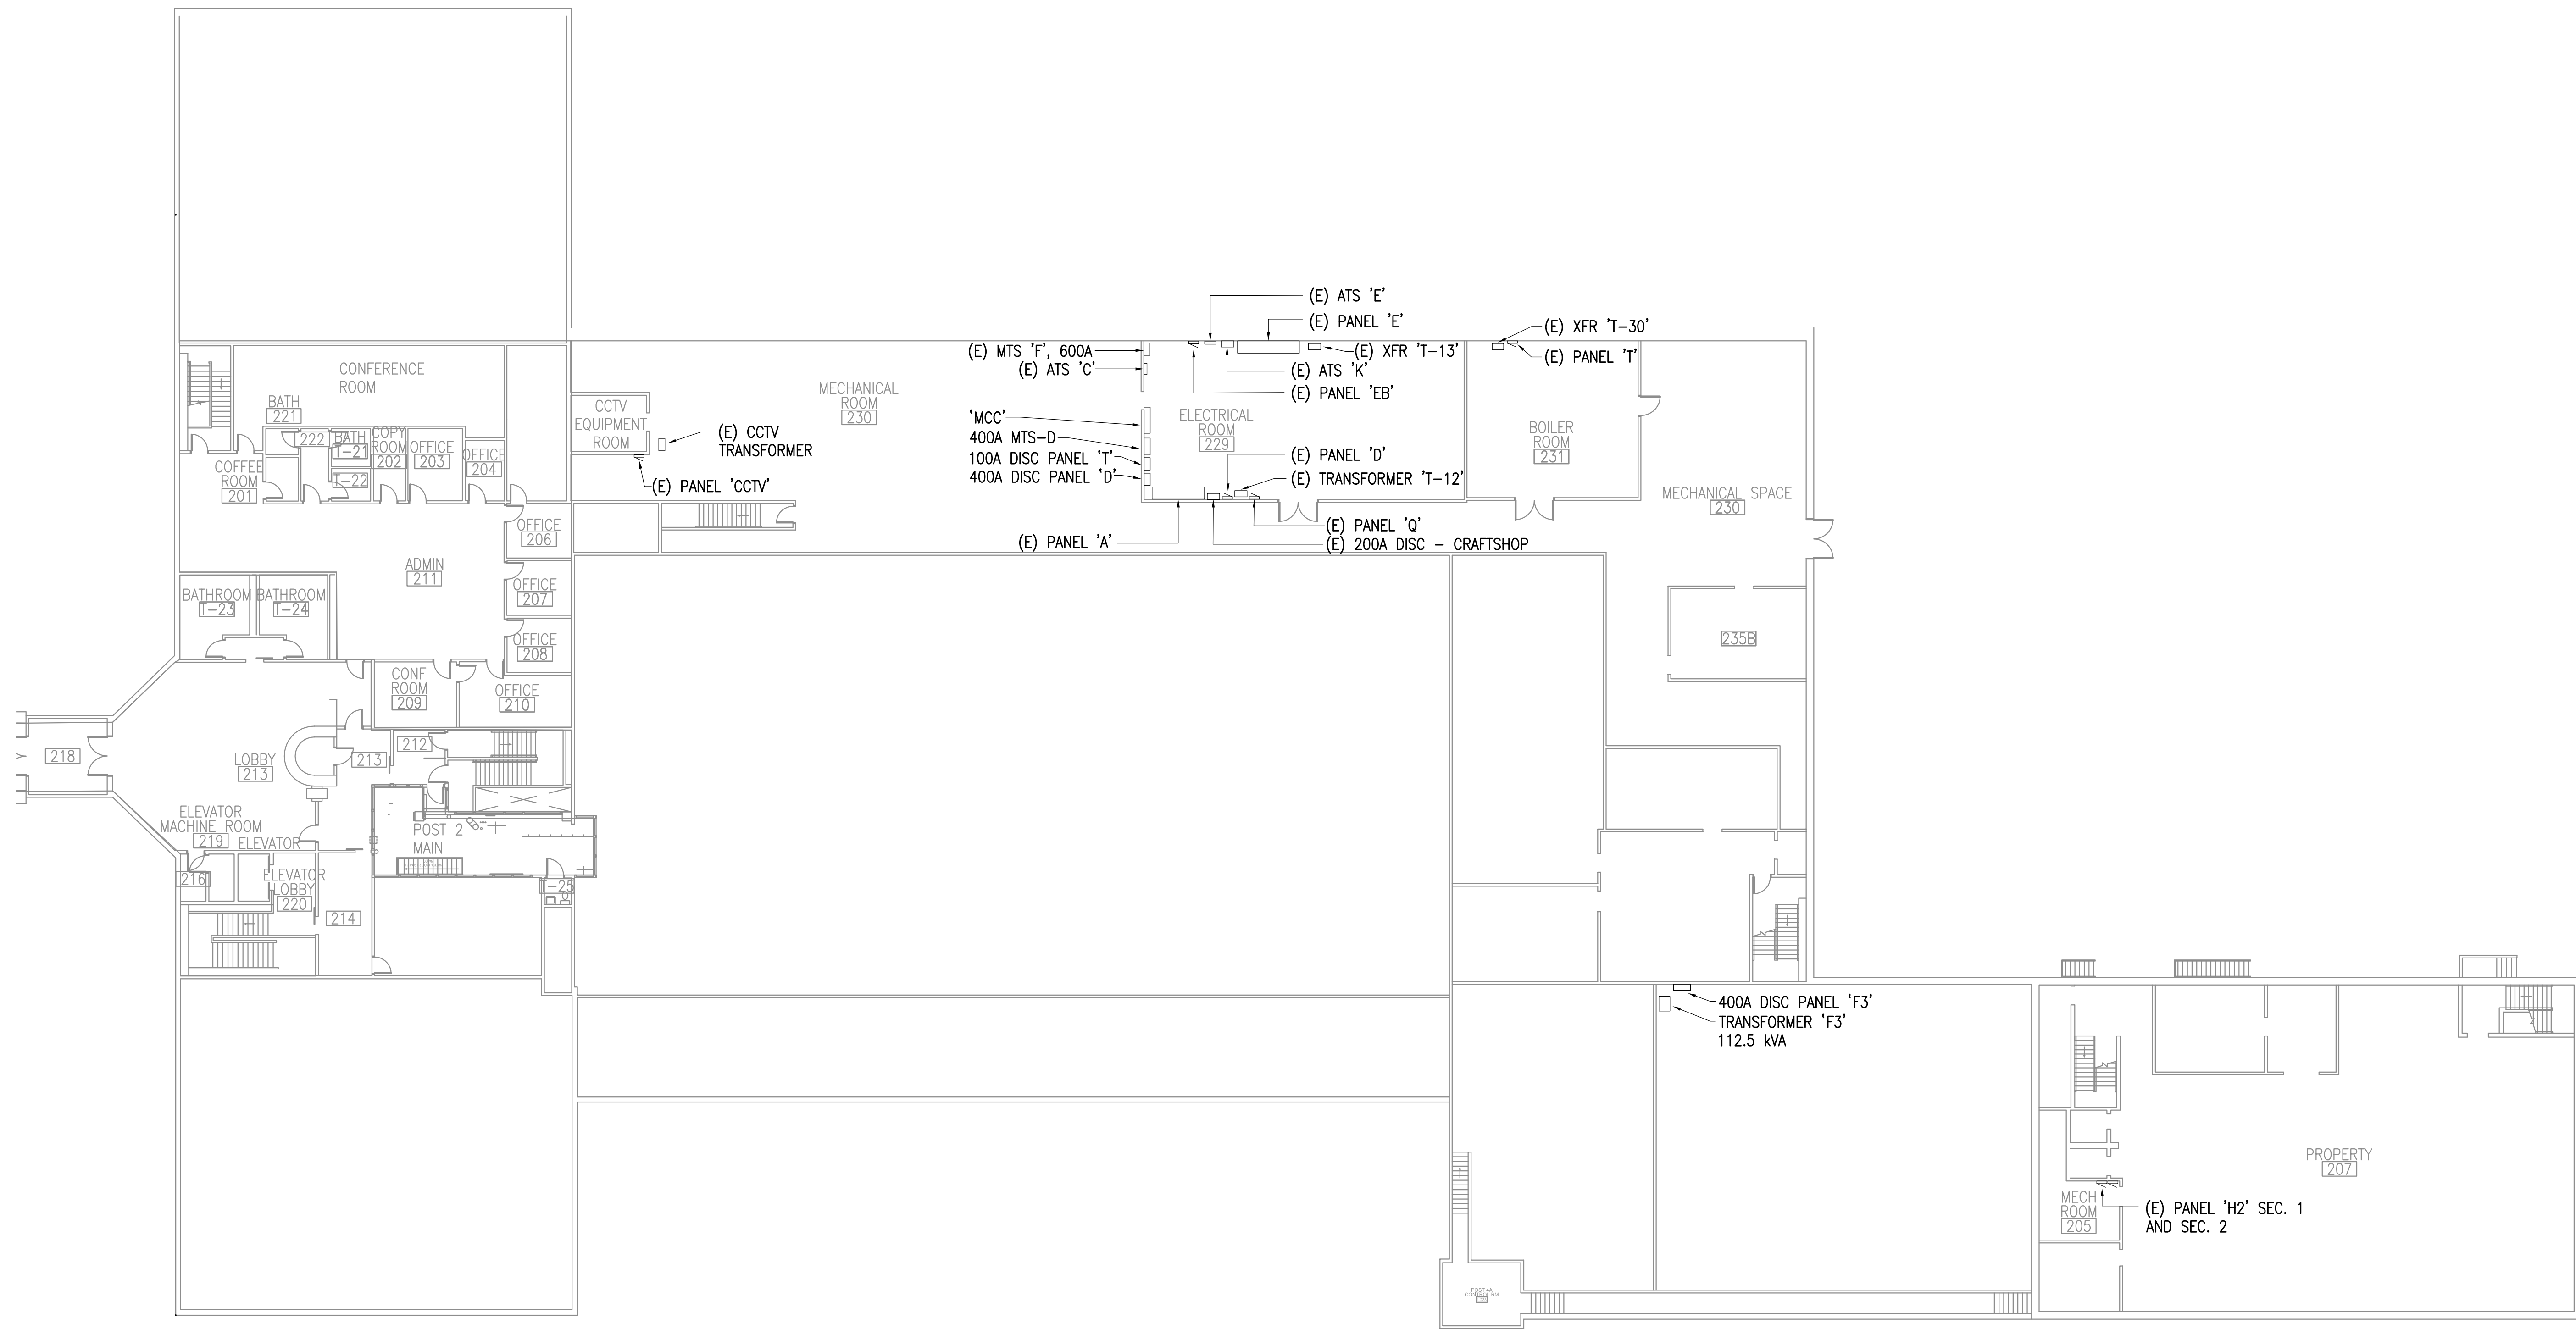

State of Alaska
DOC Arc Flash Survey and Report
Spring Creek Correctional Center
Seward, AK

REVISIONS:

DRAWN BY: MJC
CHECKED BY: JAM
DATE: 10/13/2017
JOB NUMBER: L6206
DWG FILE: L6206_ESERIES


DRAWING TITLE:
APS BUILDING PANEL
MAP - 2ND. FLOOR

SHEET:
SC2.1

1 APS BUILDING PANEL MAP - 2ND. FLOOR
1/16" = 1'-0"



0"
1"
2"
3"

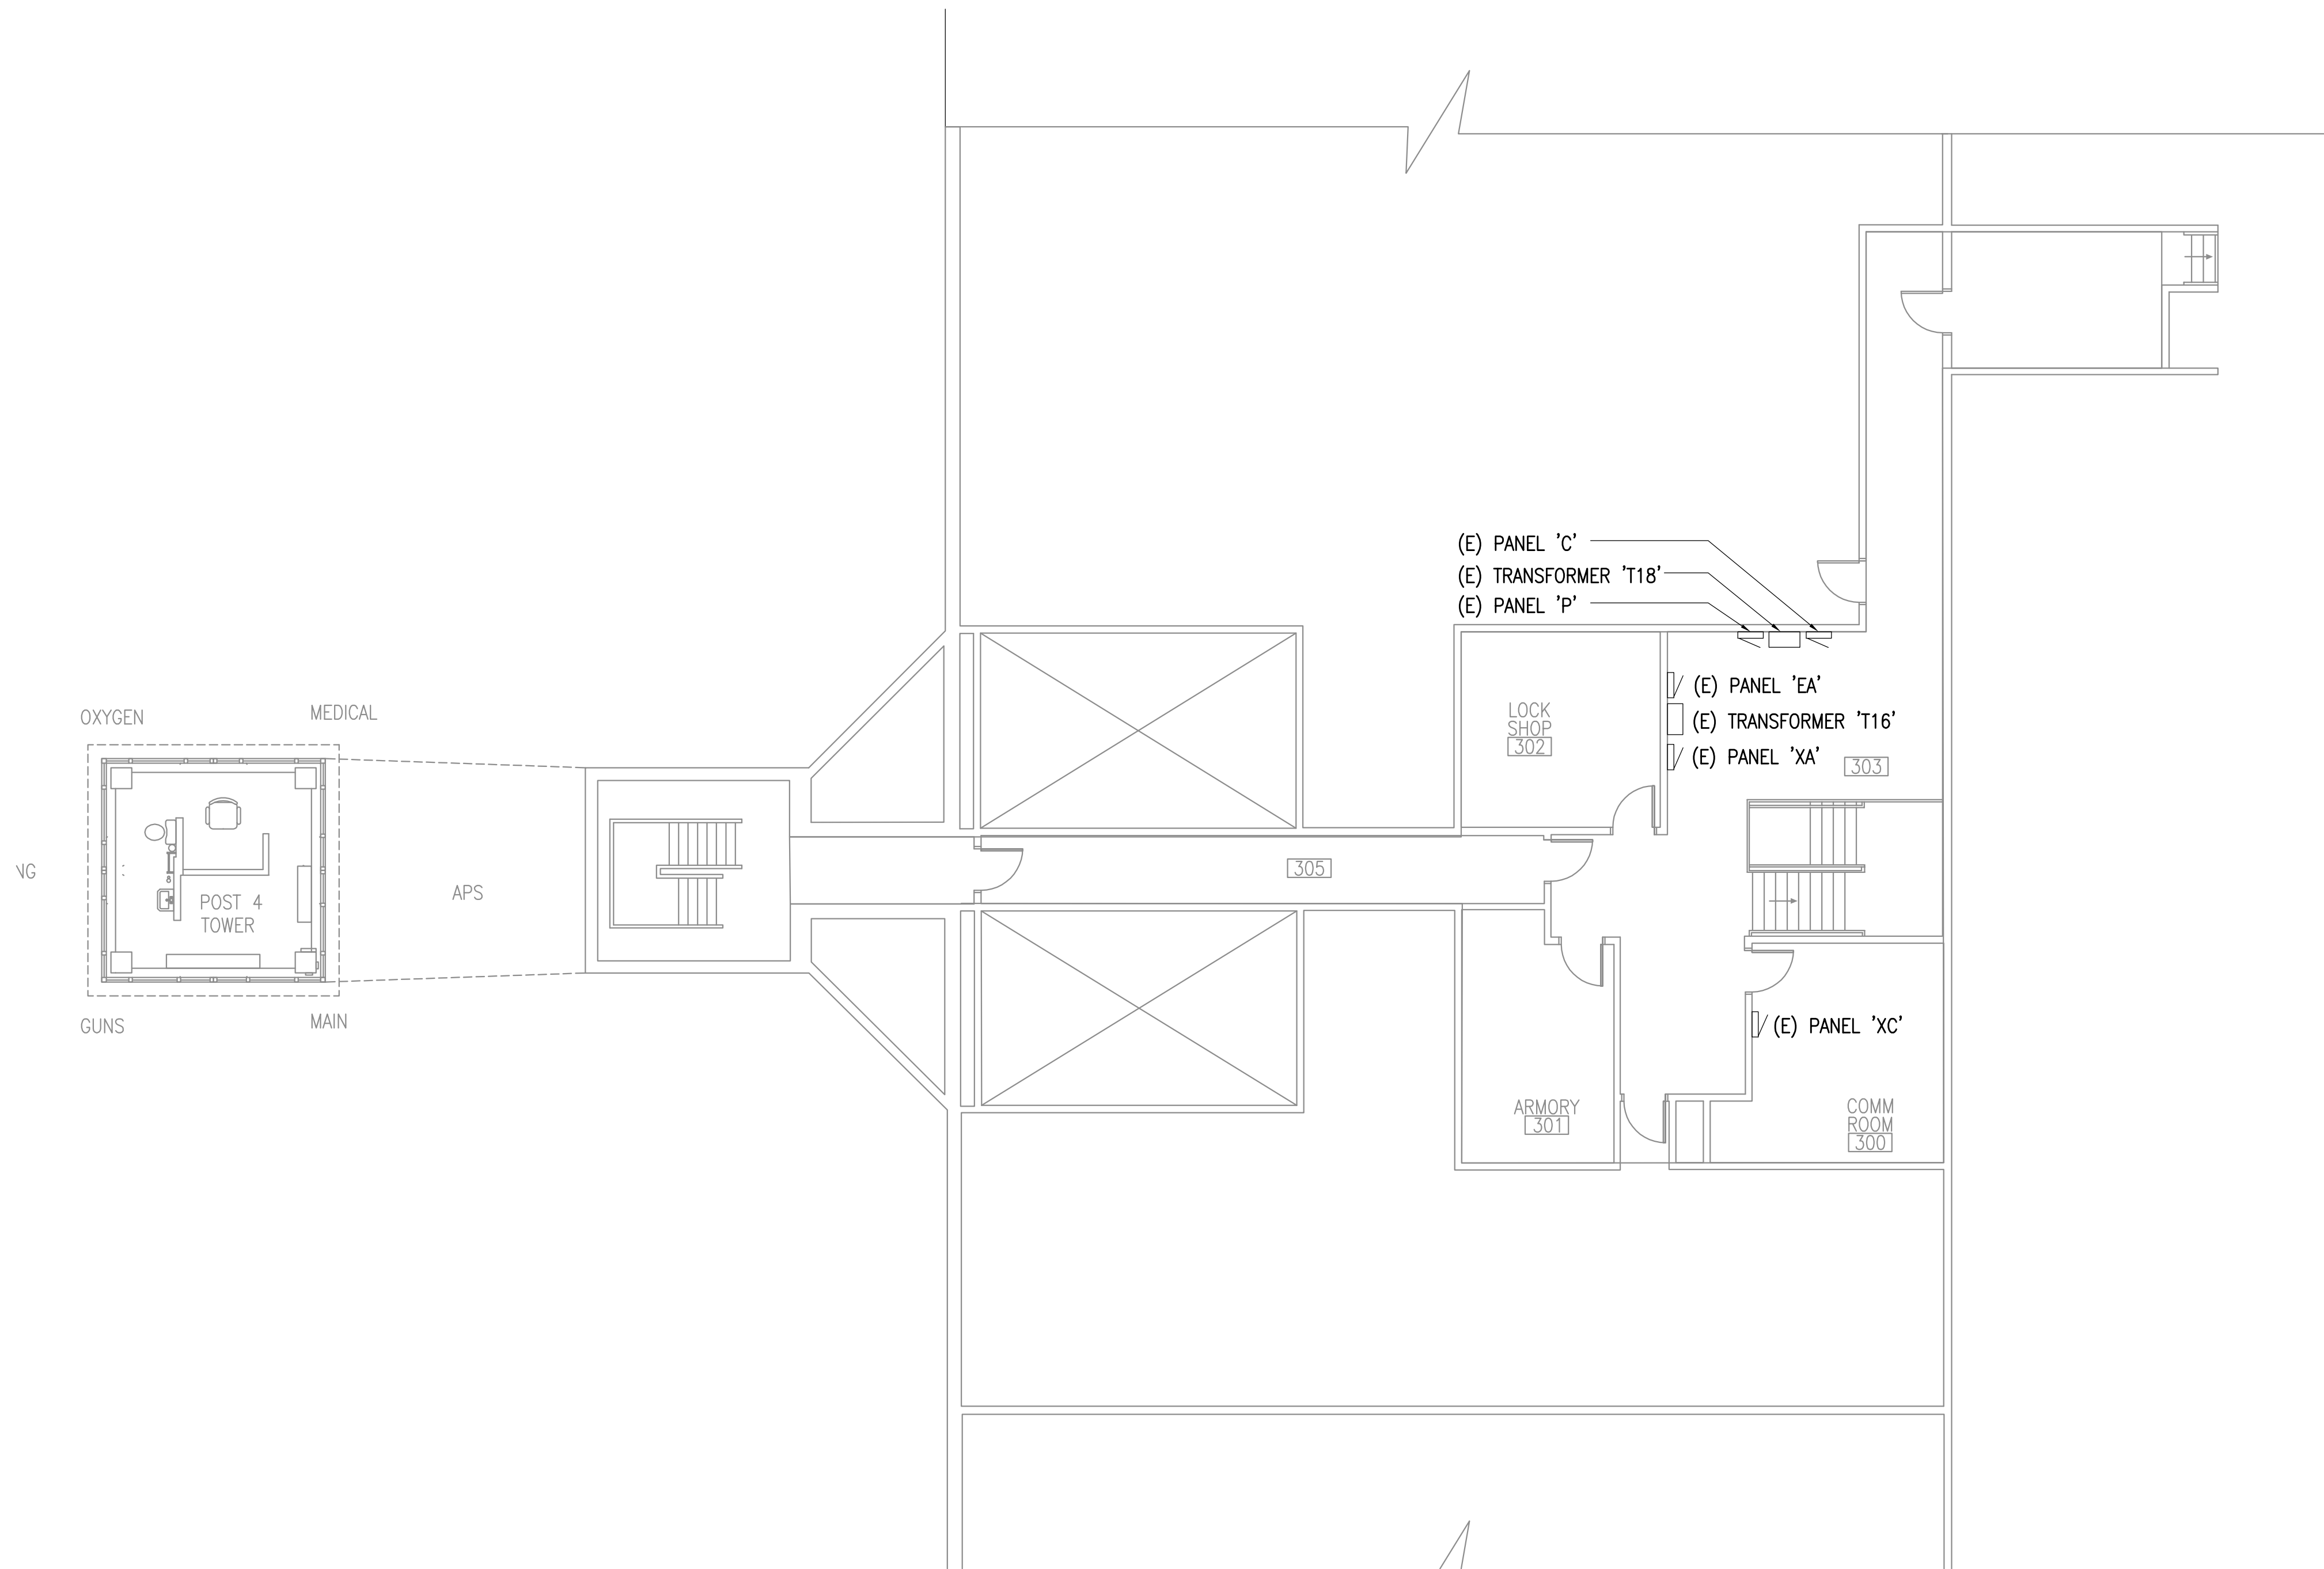

1 APS BUILDING PANEL MAP - 3RD. FLOOR / TOWER
1/8" = 1'-0"



REFERENCE
ONLY

ELECTRICAL ENGINEER

RSA ENGINEERING, INC.
670 W. Fireweed Ln., Suite 200
Anchorage, AK 99503-2516
Phone (907) 276-0521 Fax (907) 276-1751

State of Alaska

DOC Arc Flash Survey and Report
Spring Creek Correctional Center
Seward, AK

REVISIONS:


DRAWN BY: MJC
CHECKED BY: JAM
DATE: 10/13/2017
JOB NUMBER: L6206
DWG FILE: L6206_ESERIES

DRAWING TITLE:
APS BUILDING PANEL
MAP - 3RD. FLOOR / TOWER

SHEET:

SC2.2

0"
1"
2"
3"

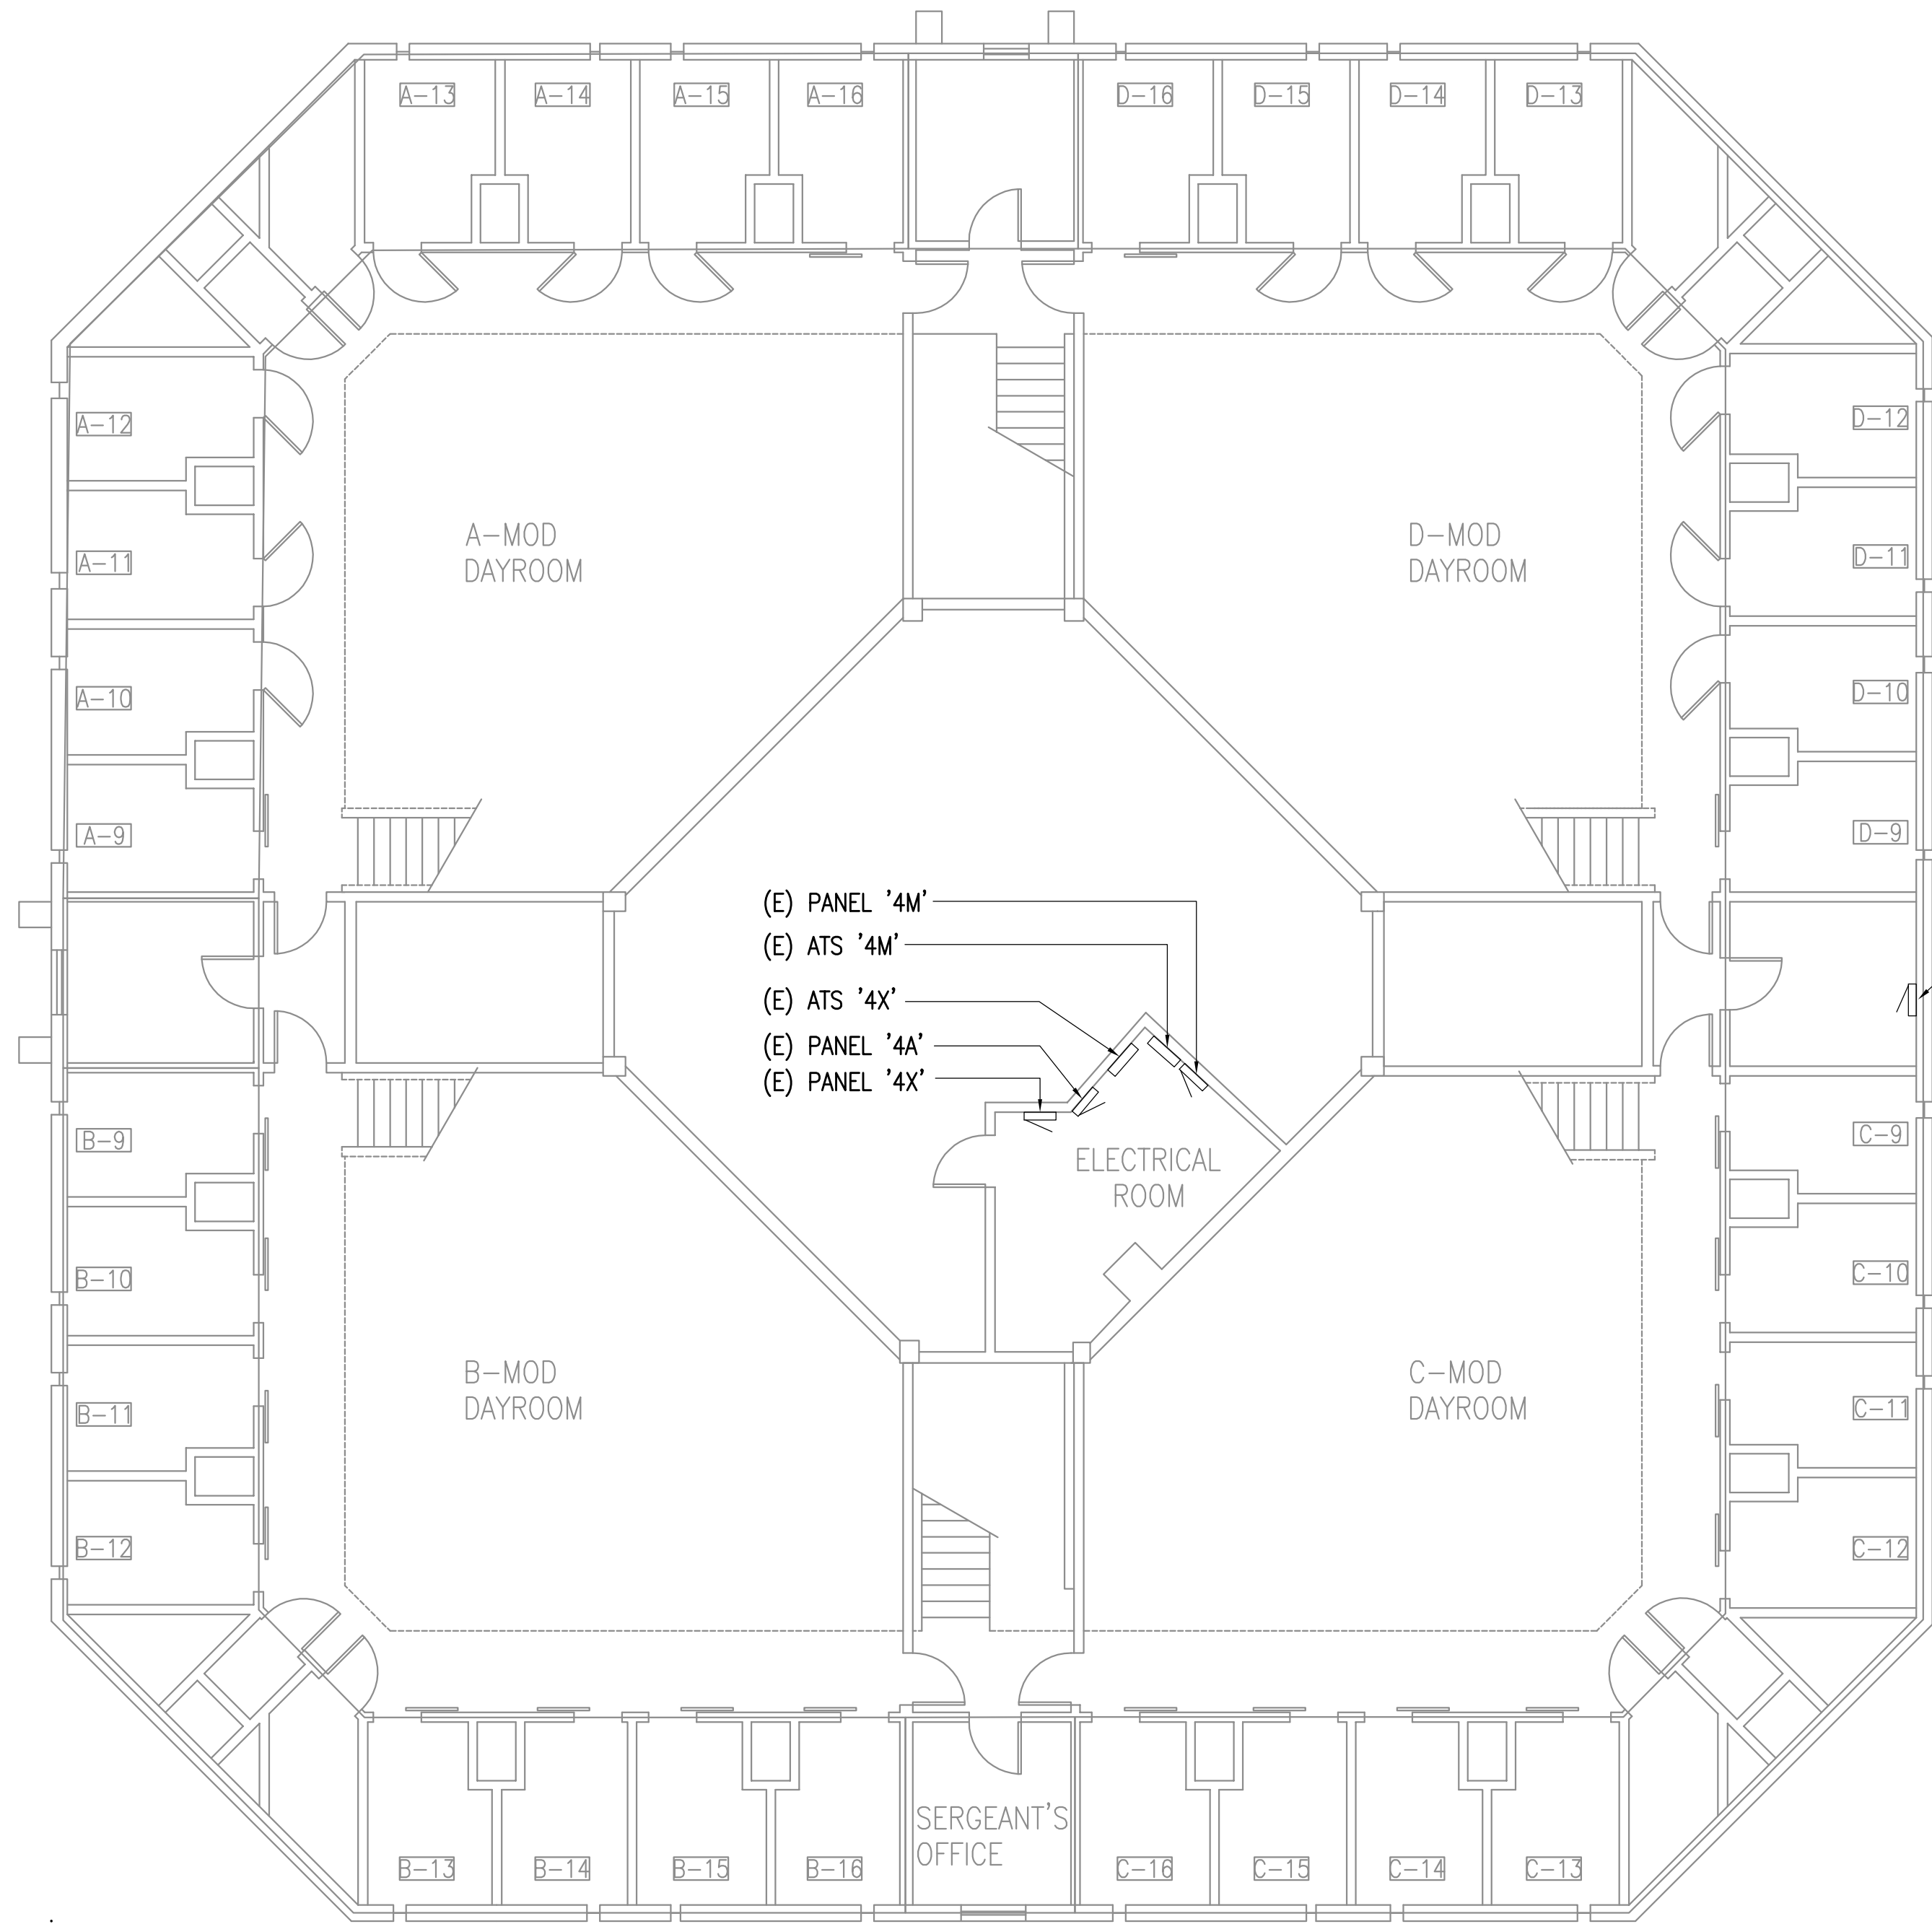

1 HOUSE #1 BUILDING PANEL MAP - 2ND. FLOOR
1/8" = 1'-0"



REFERENCE
ONLY

ELECTRICAL ENGINEER
RSA ENGINEERING, INC.
670 W. Fireweed Ln., Suite 200
Anchorage, AK 99503-2516
Phone (907) 276-0521 Fax (907) 276-1751

State of Alaska
DOC Arc Flash Survey and Report
Spring Creek Correctional Center
Seward, AK


REVISIONS:

DRAWN BY: MJC
CHECKED BY: JAM
DATE: 10/13/2017
JOB NUMBER: L6206
DWG FILE: L6206_ESERIES



DRAWING TITLE:
HOUSE #1 BUILDING PANEL
MAP - 2ND. FLOOR

SHEET:
SC2.3



0"
1"
2"
3"

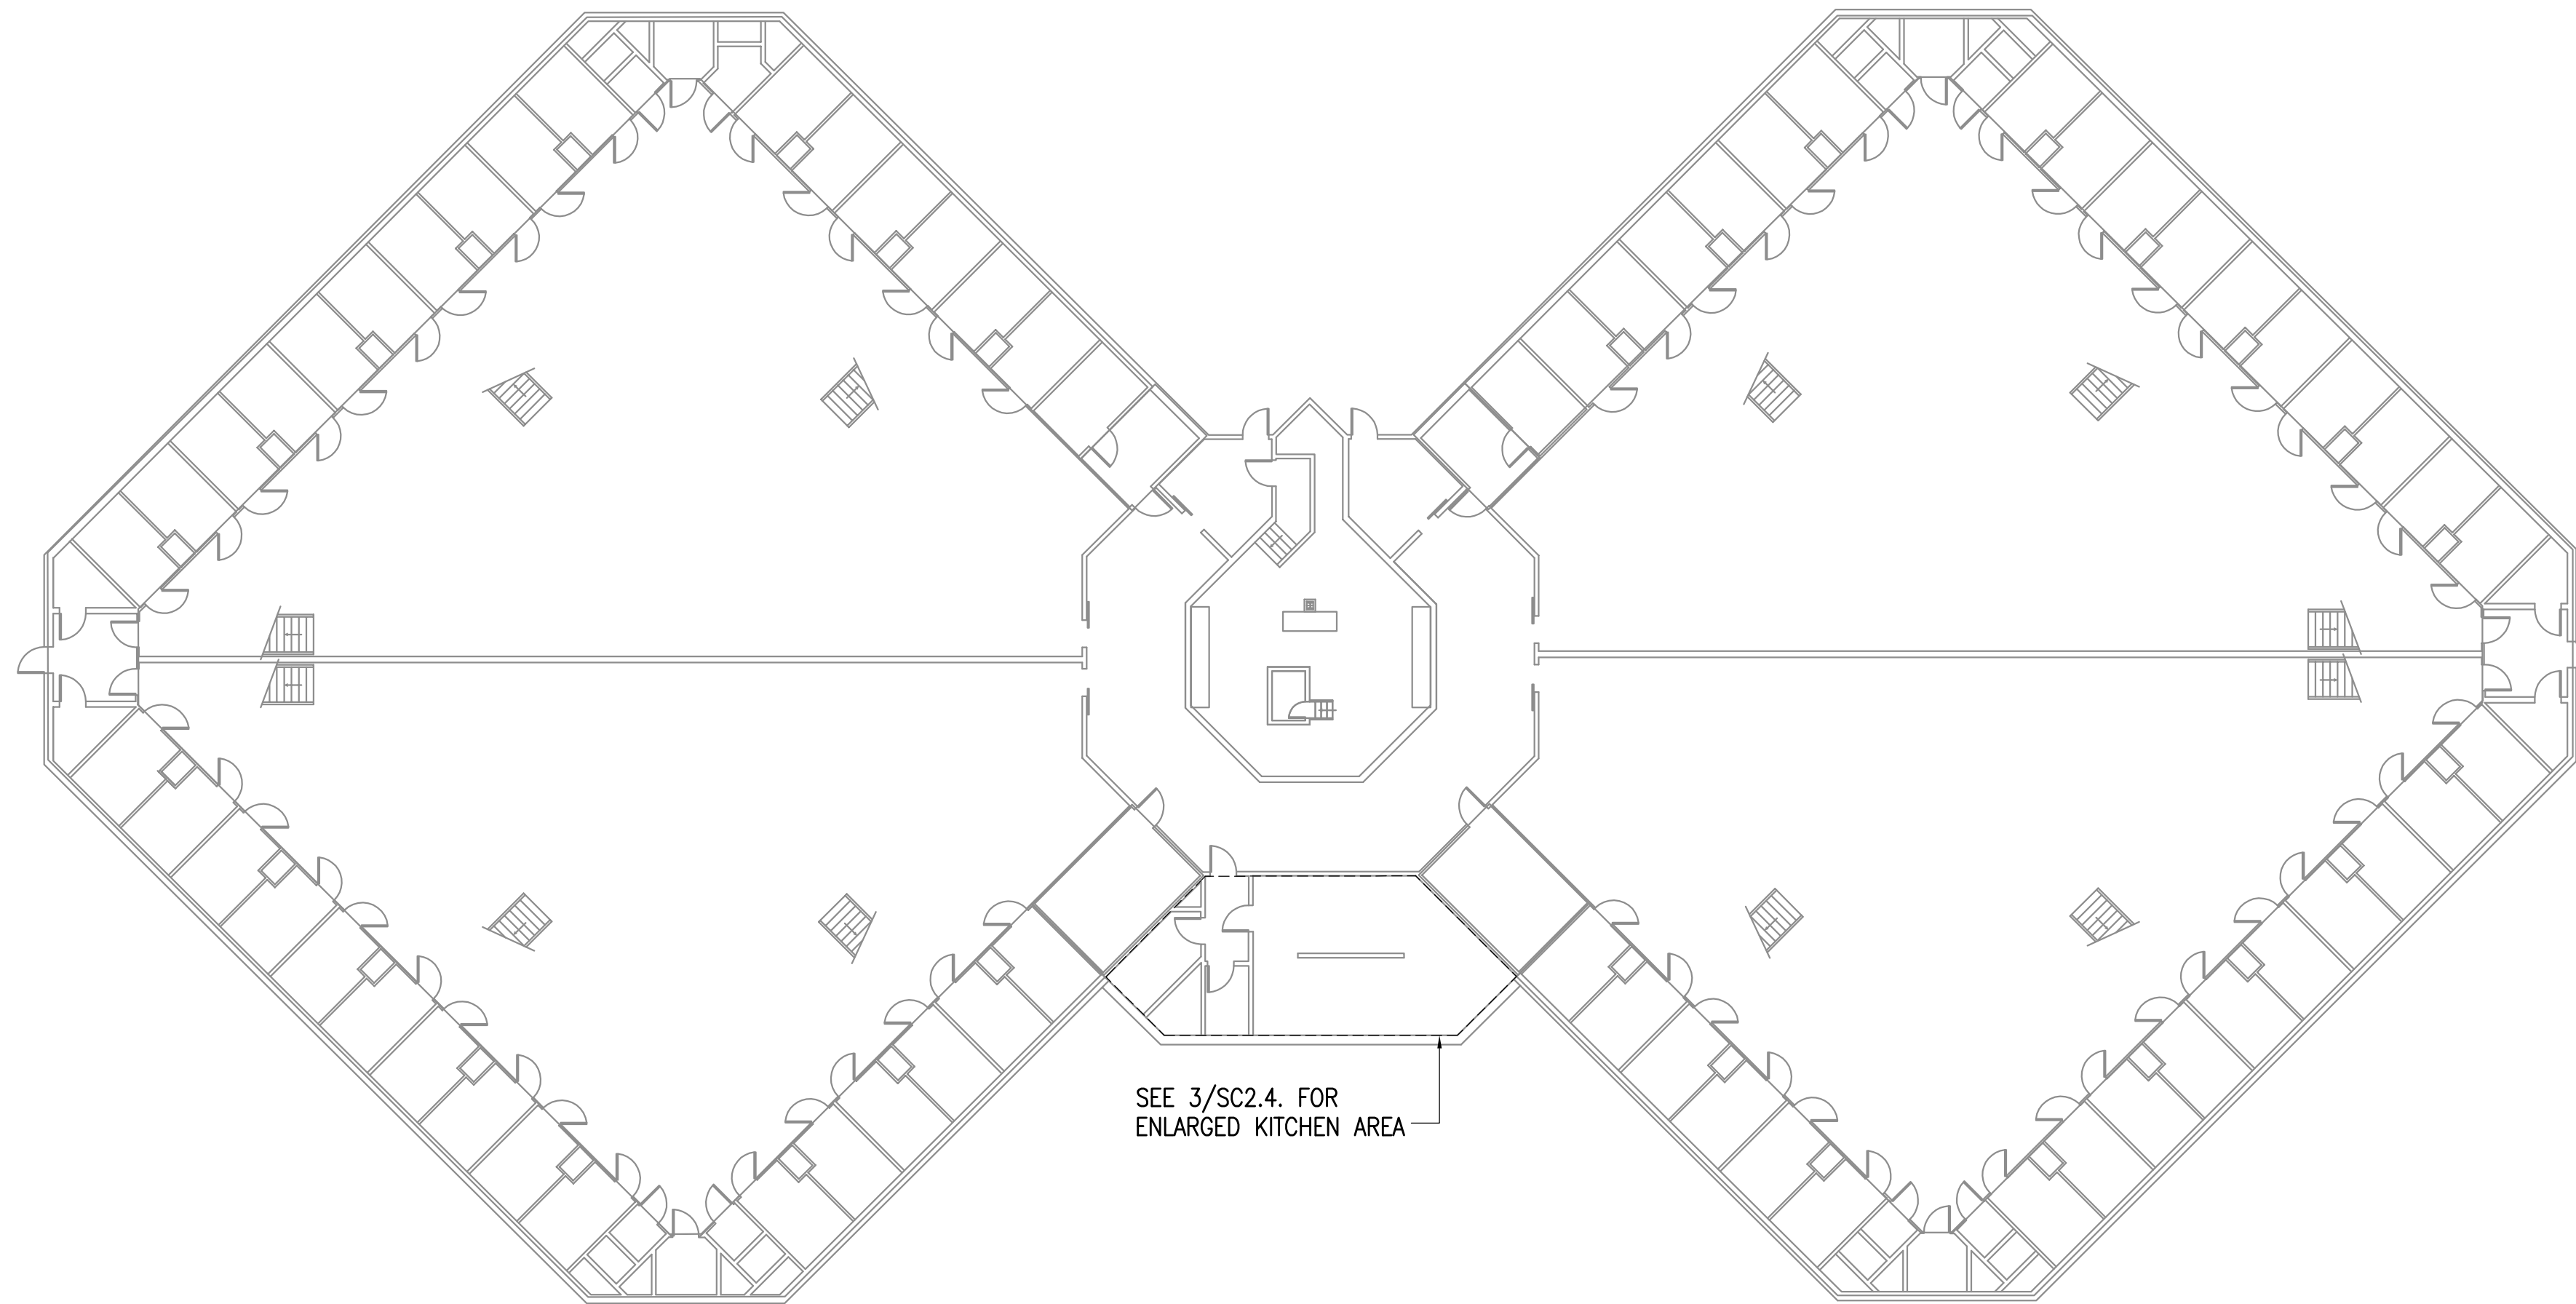

 
1 HOUSE #3 BUILDING PANEL MAP - 1ST. FLOOR
1/16" = 1'-0"

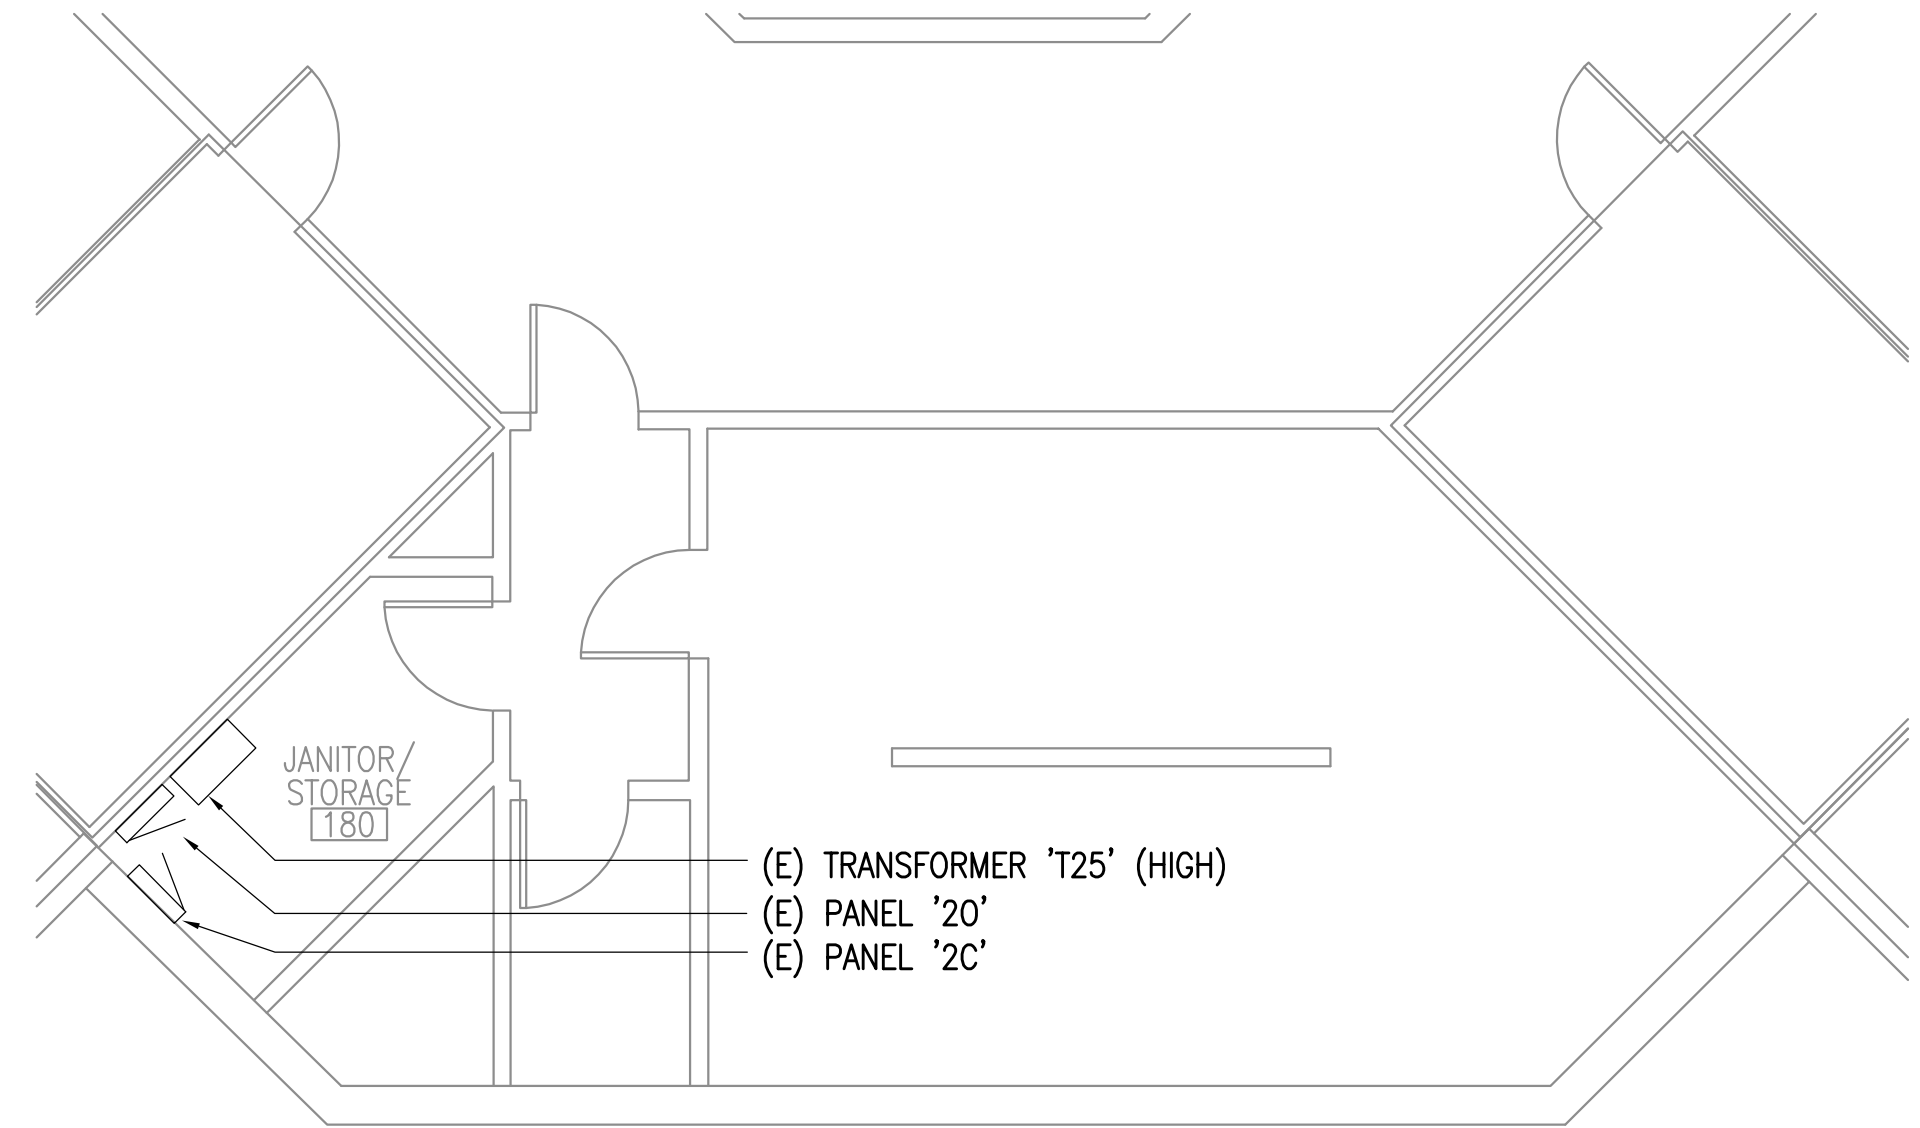

 3 HOUSE #3 BUILDING PANEL MAP - KITCHEN AREA
3/16" = 1'-0"

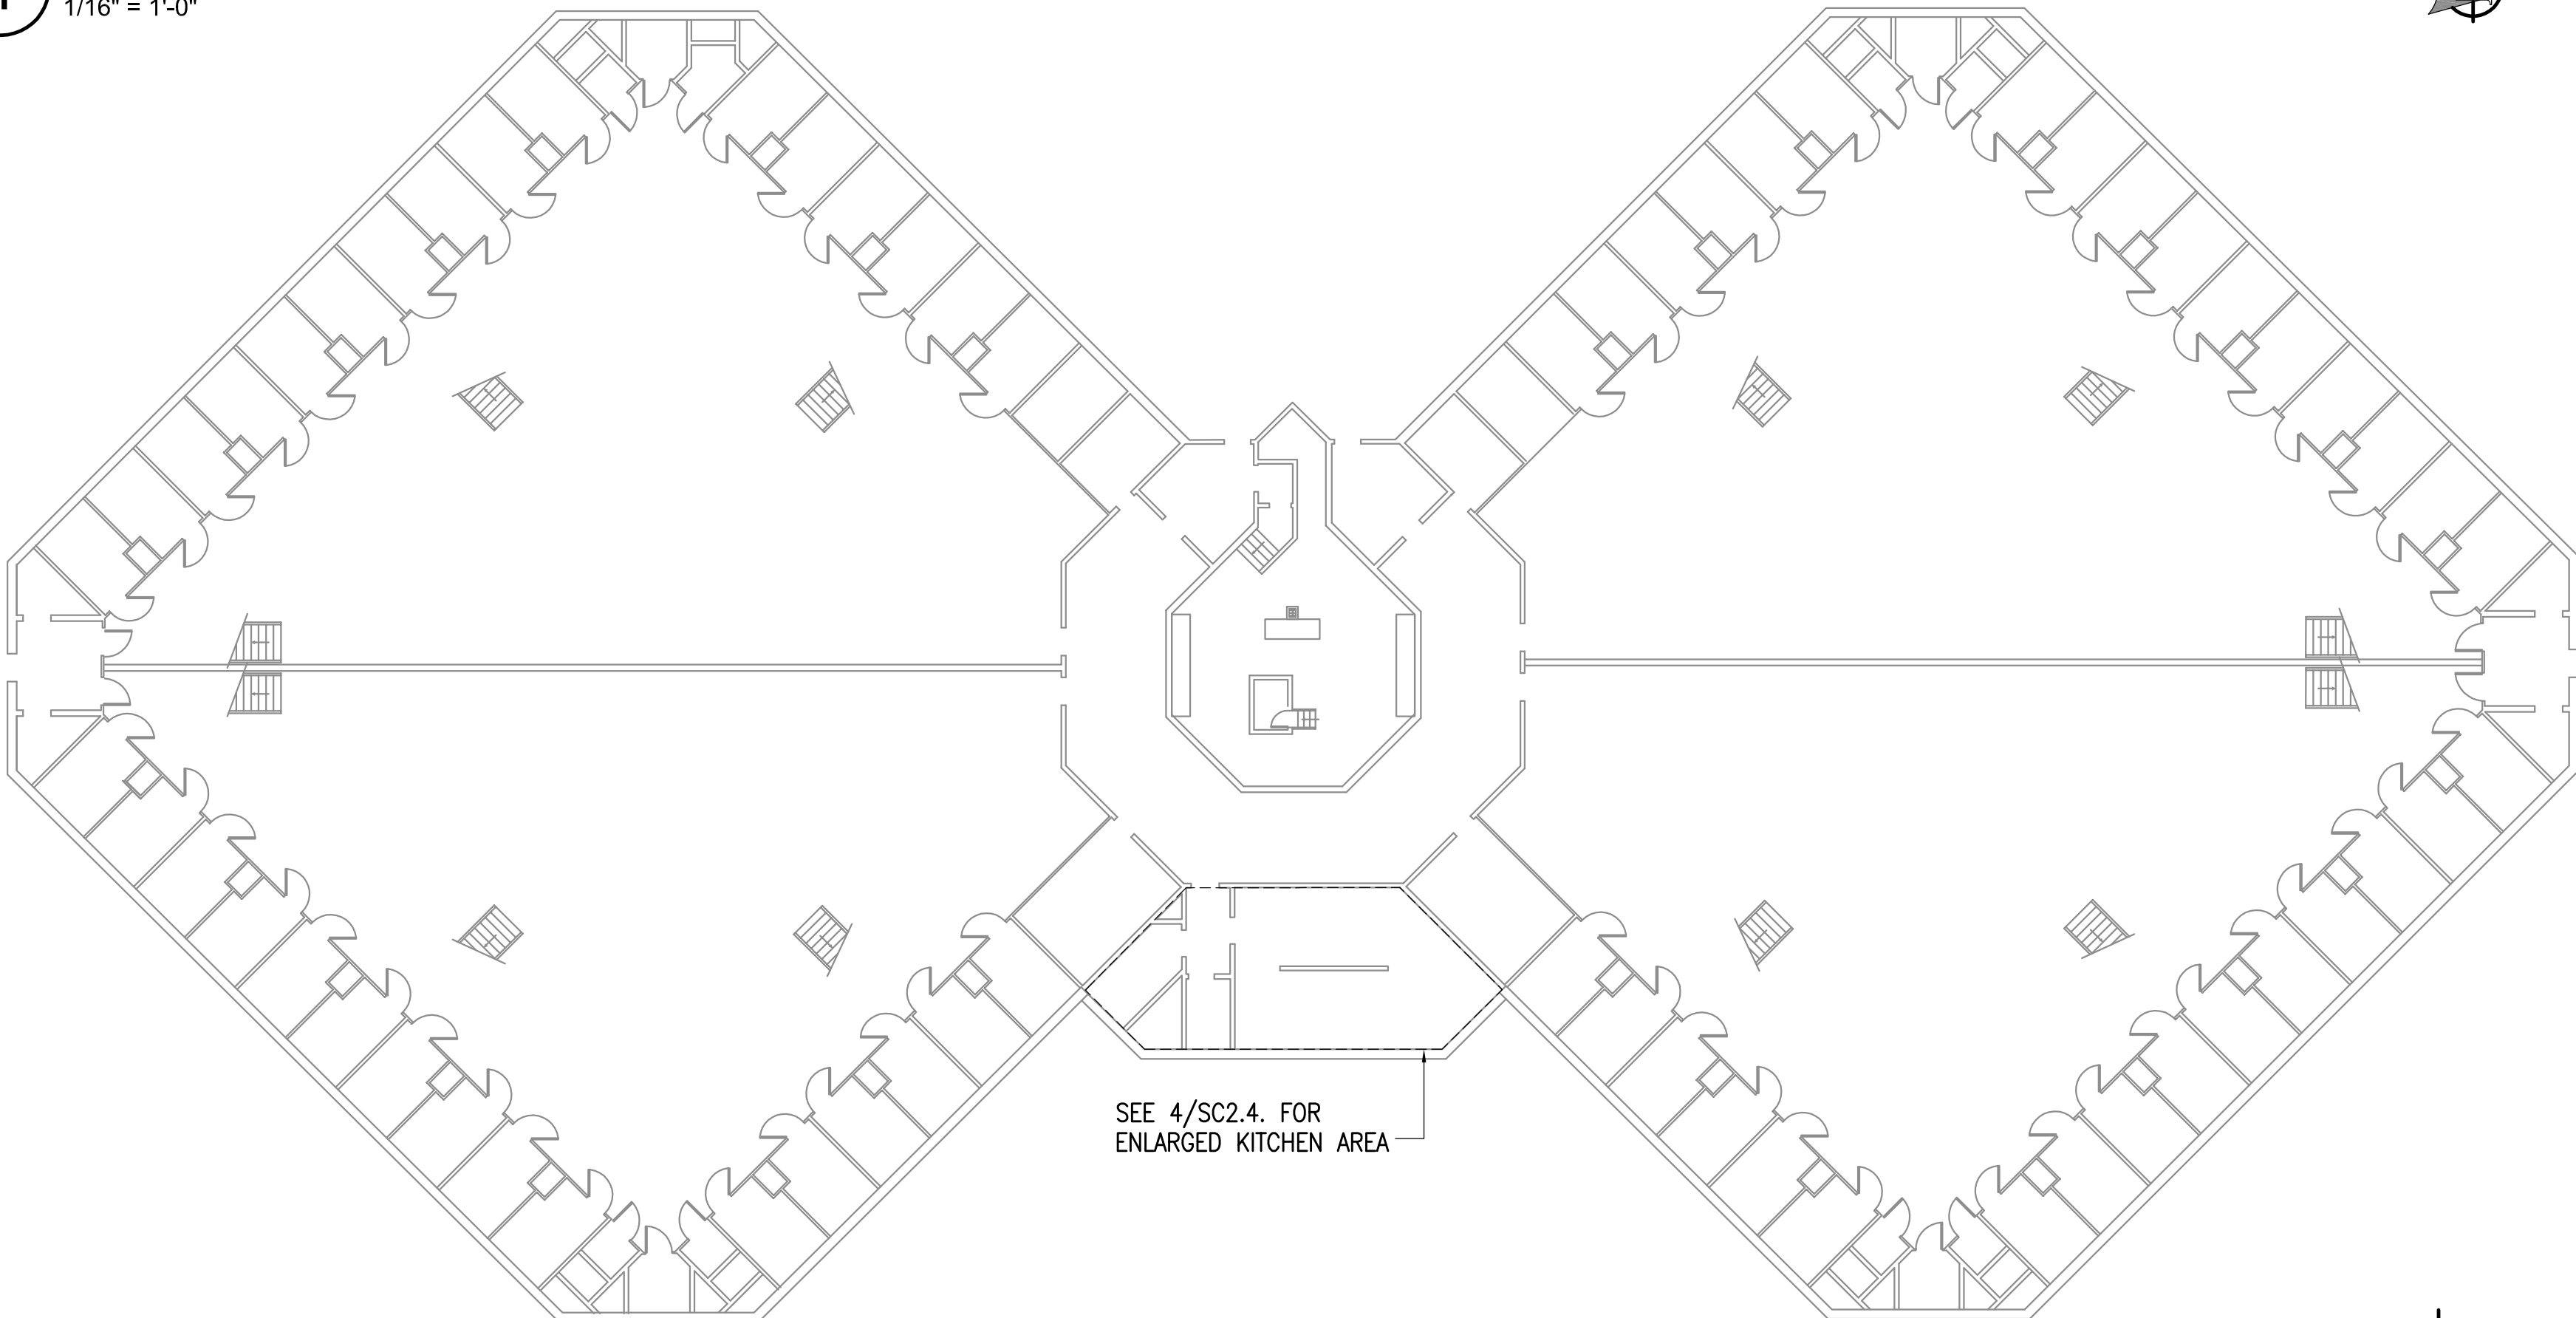

2 HOUSE #2 BUILDING PANEL MAP - 1ST. FLOOR
1/16" = 1'-0"

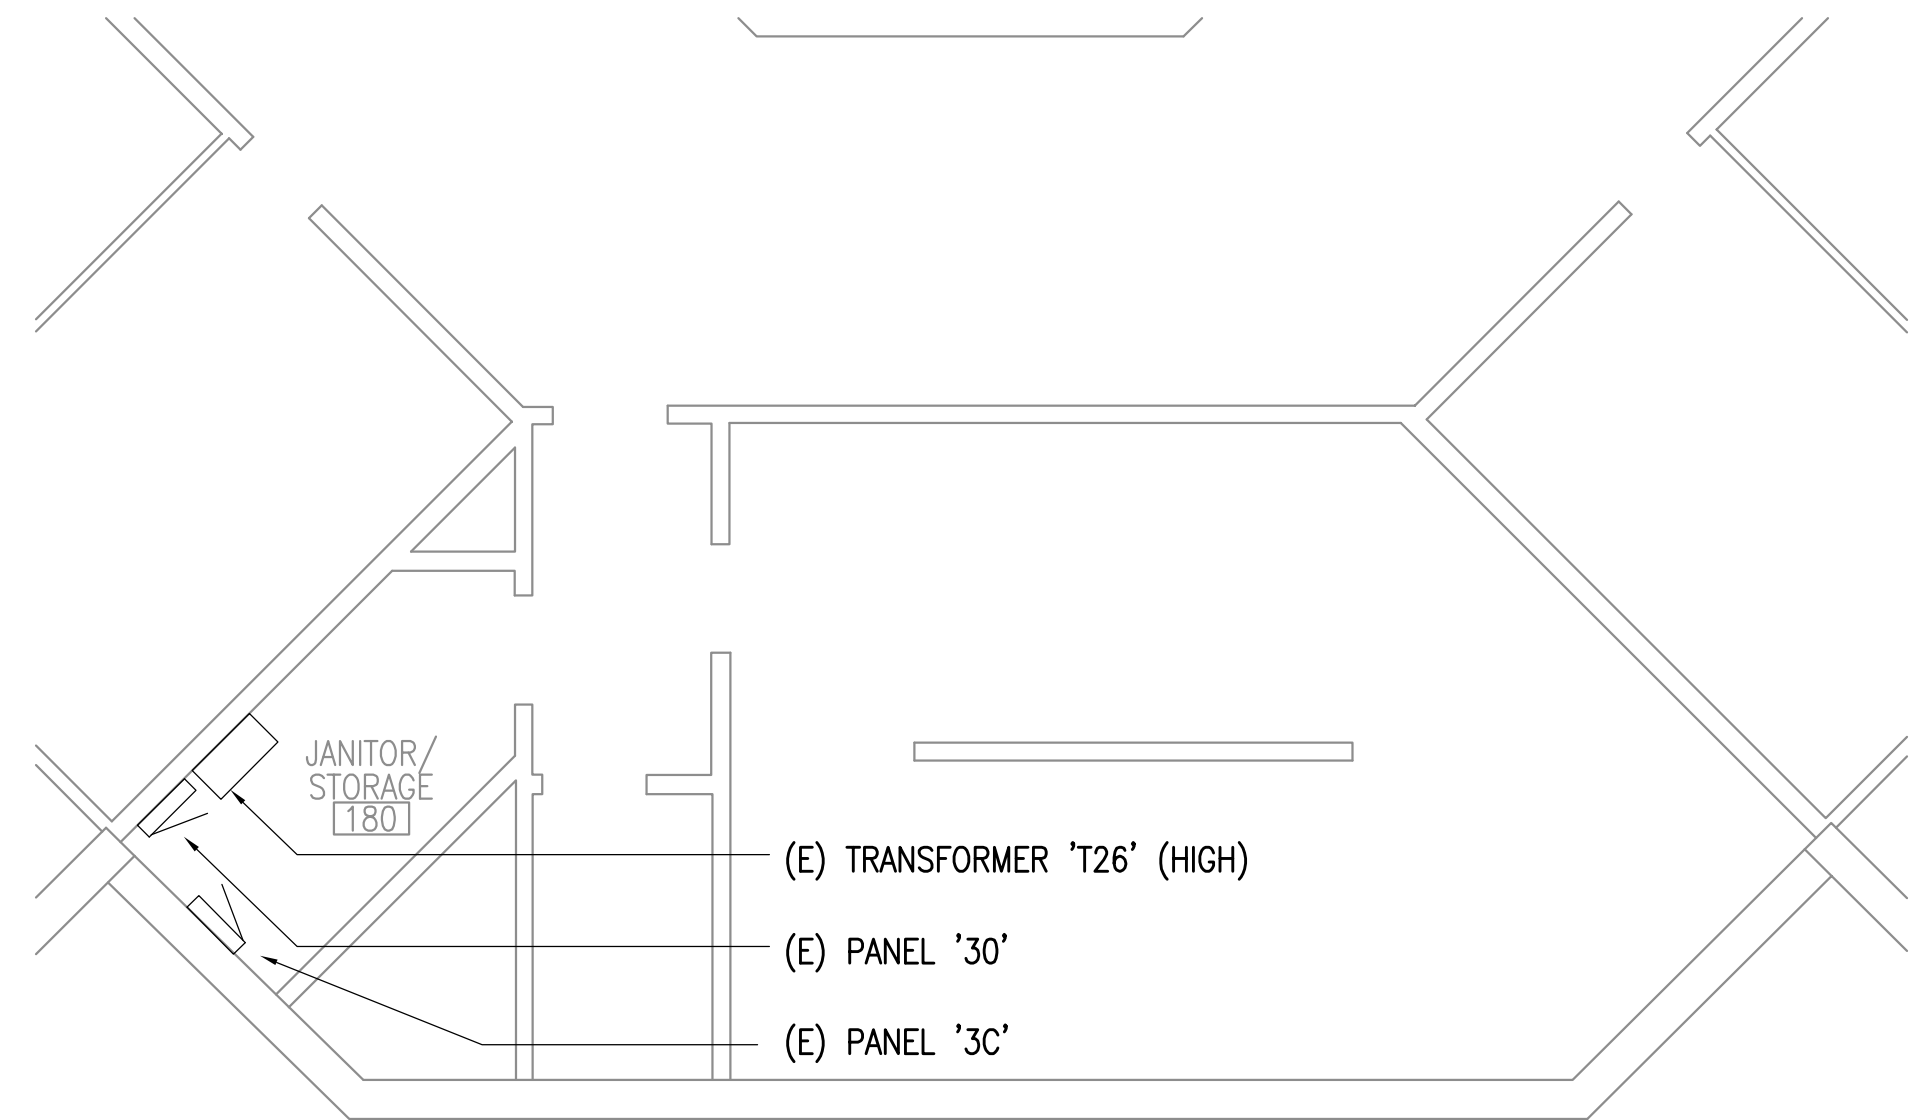

4 HOUSE #2 BUILDING PANEL MAP - KITCHEN AREA
1/16" = 1'-0"



REFERENCE
ONLY

ELECTRICAL ENGINEER
RSA ENGINEERING, INC.
670 W. Fireweed Ln., Suite 200
Anchorage, AK 99503-2516
Phone (907) 276-0521 Fax (907) 276-1751

State of Alaska
DOC Arc Flash Survey and Report
Spring Creek Correctional Center
Seward, AK


REVISIONS:

DRAWN BY: MJC
CHECKED BY: JAM
DATE: 10/13/2017
JOB NUMBER: L6206
DWG FILE: L6206_ESERIES



DRAWING TITLE:
HOUSE #2 & 3 BUILDING
PANEL MAP - 1ST. FLOOR

SHEET:
SC2.4


0"
1"
2"
3"

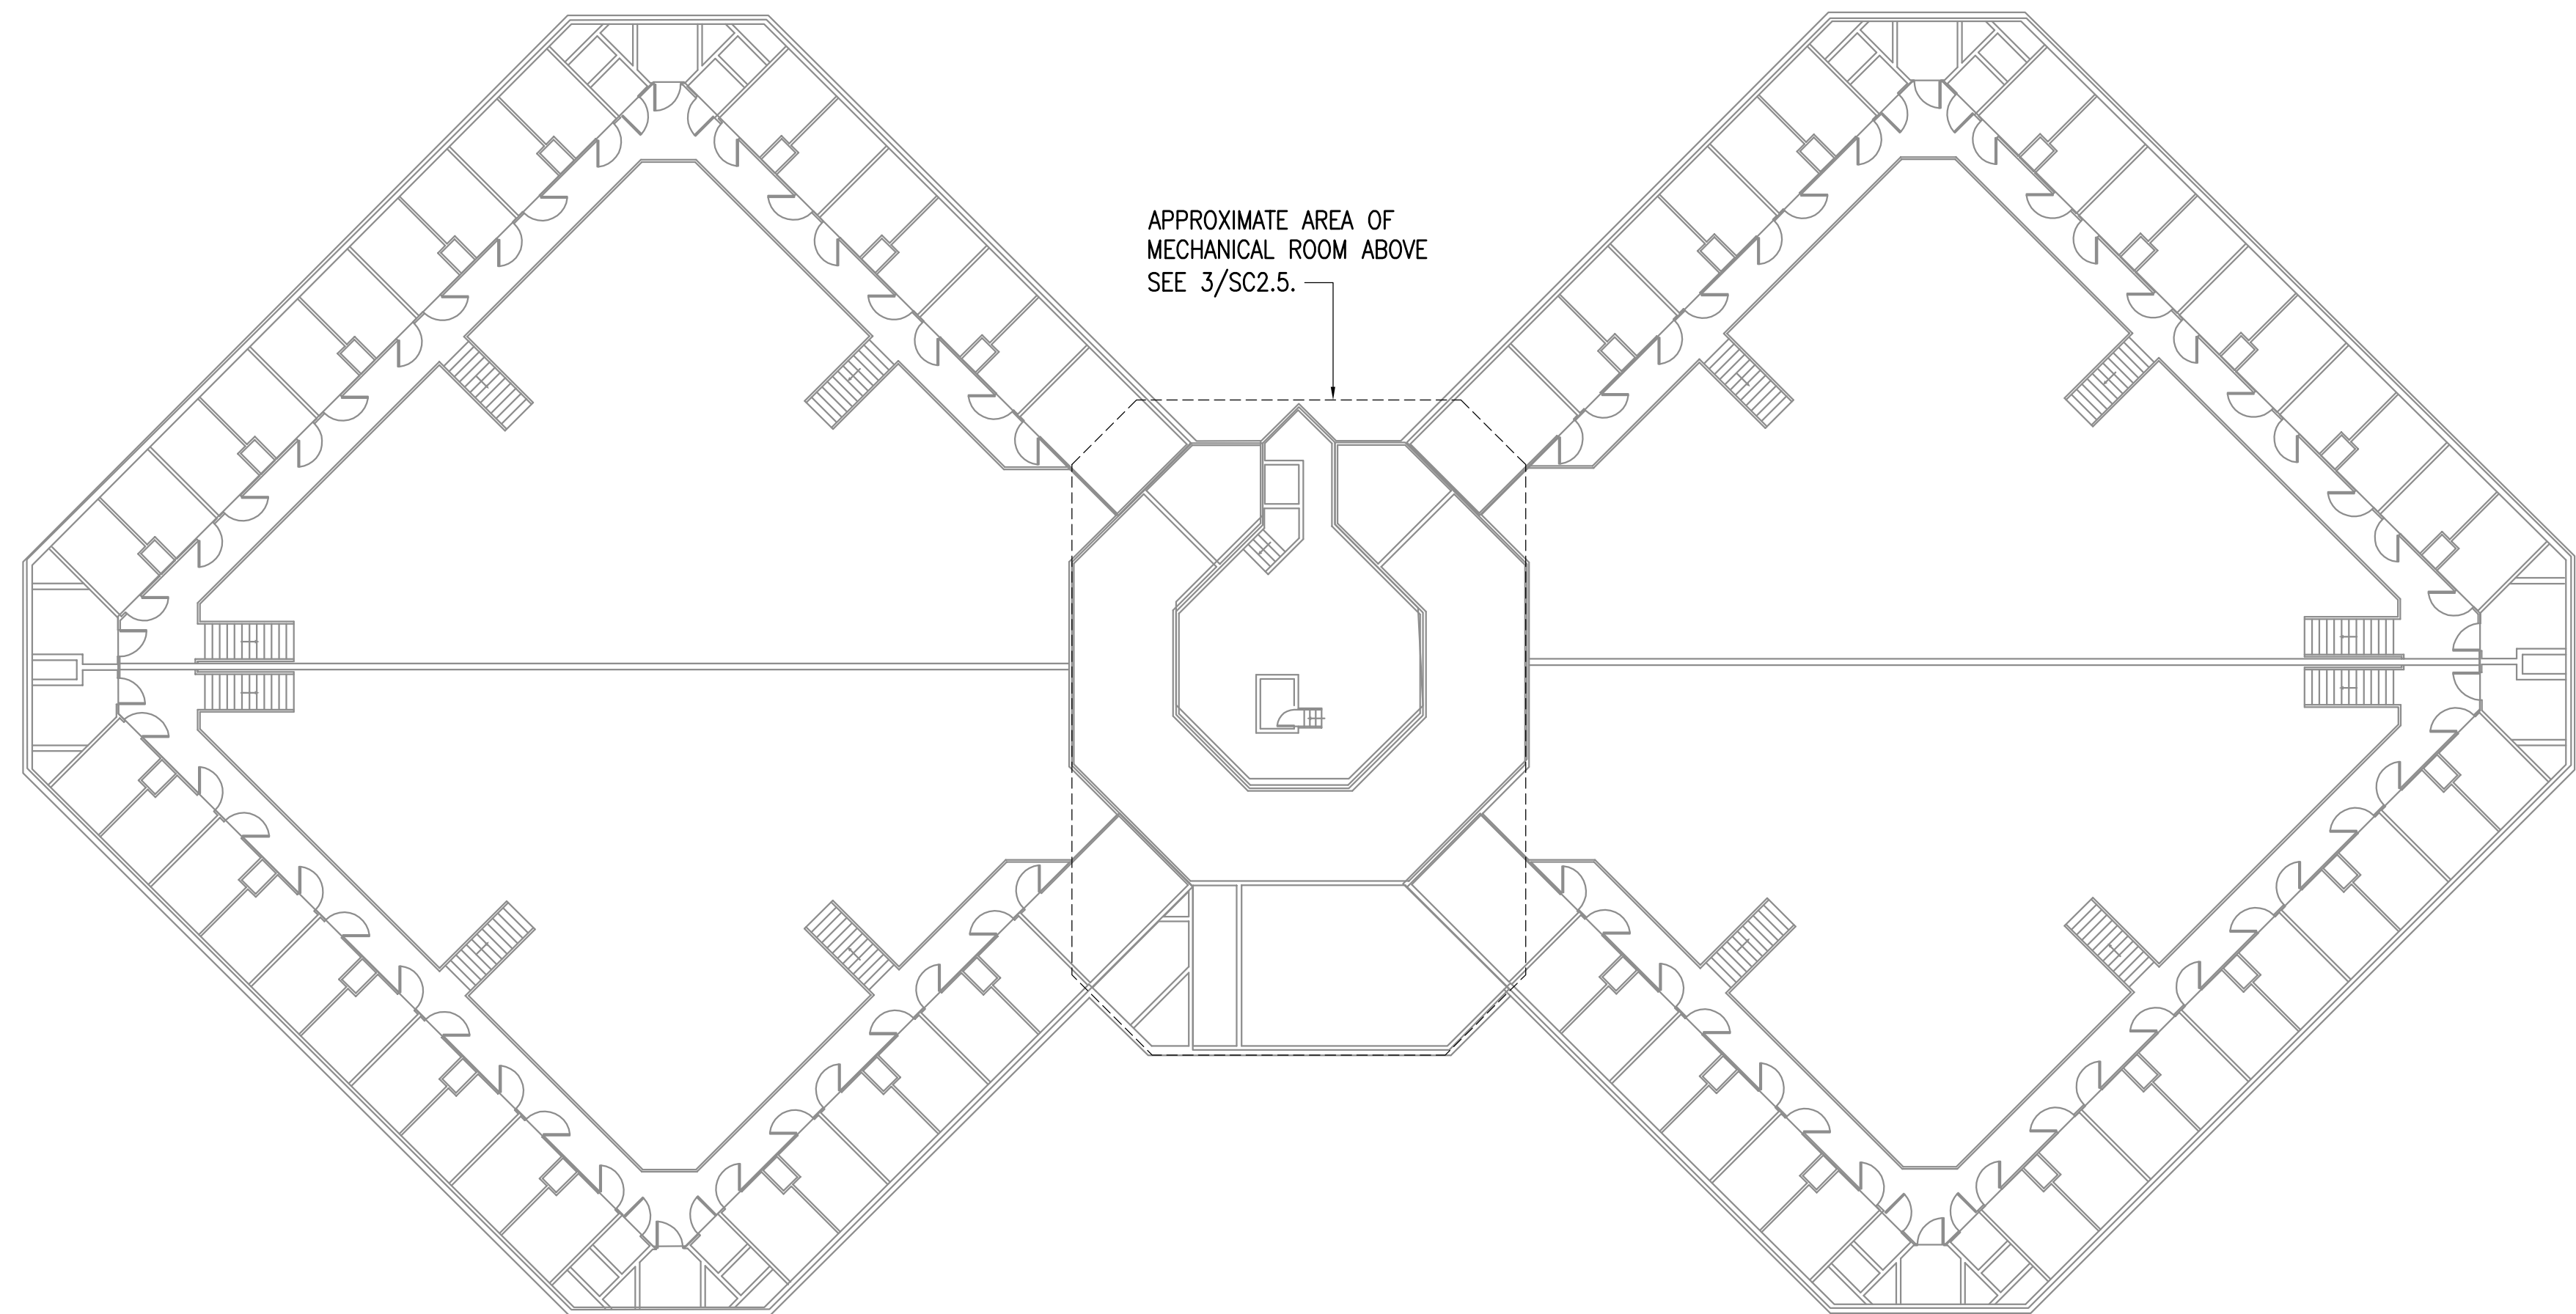

 
1 HOUSE #3 BUILDING PANEL MAP - 2ND. FLOOR
1/16" = 1'-0"

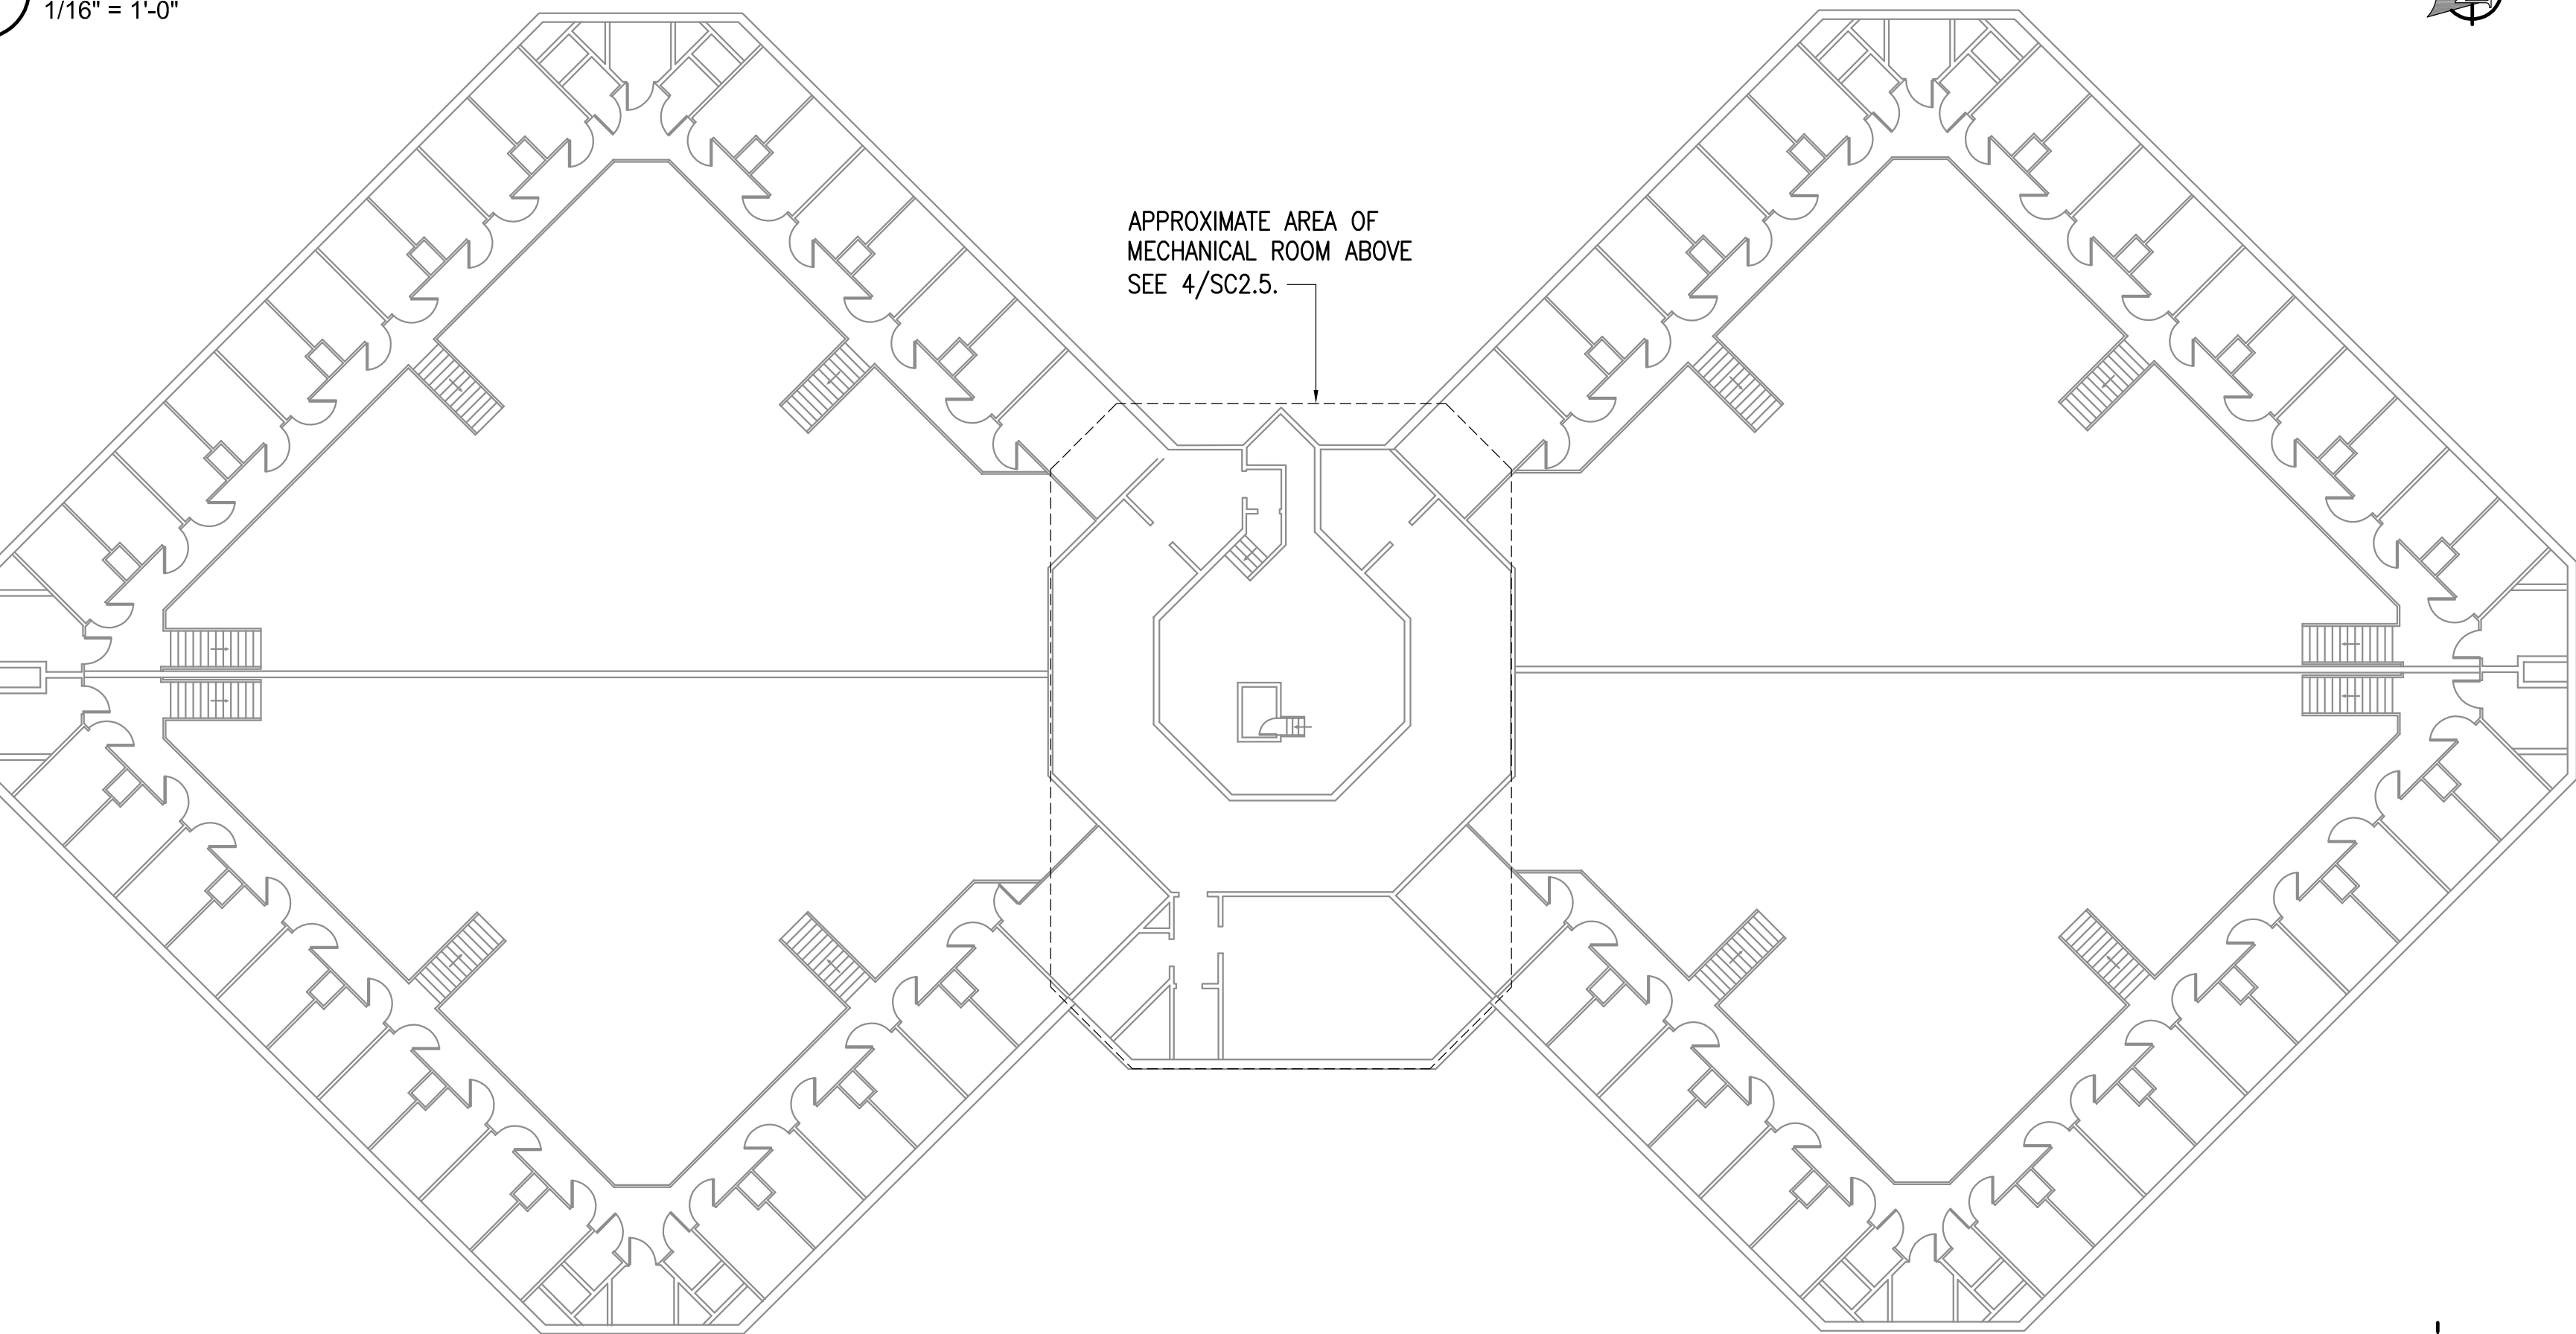

2 HOUSE #2 BUILDING PANEL MAP - 2ND. FLOOR
1/16" = 1'-0"

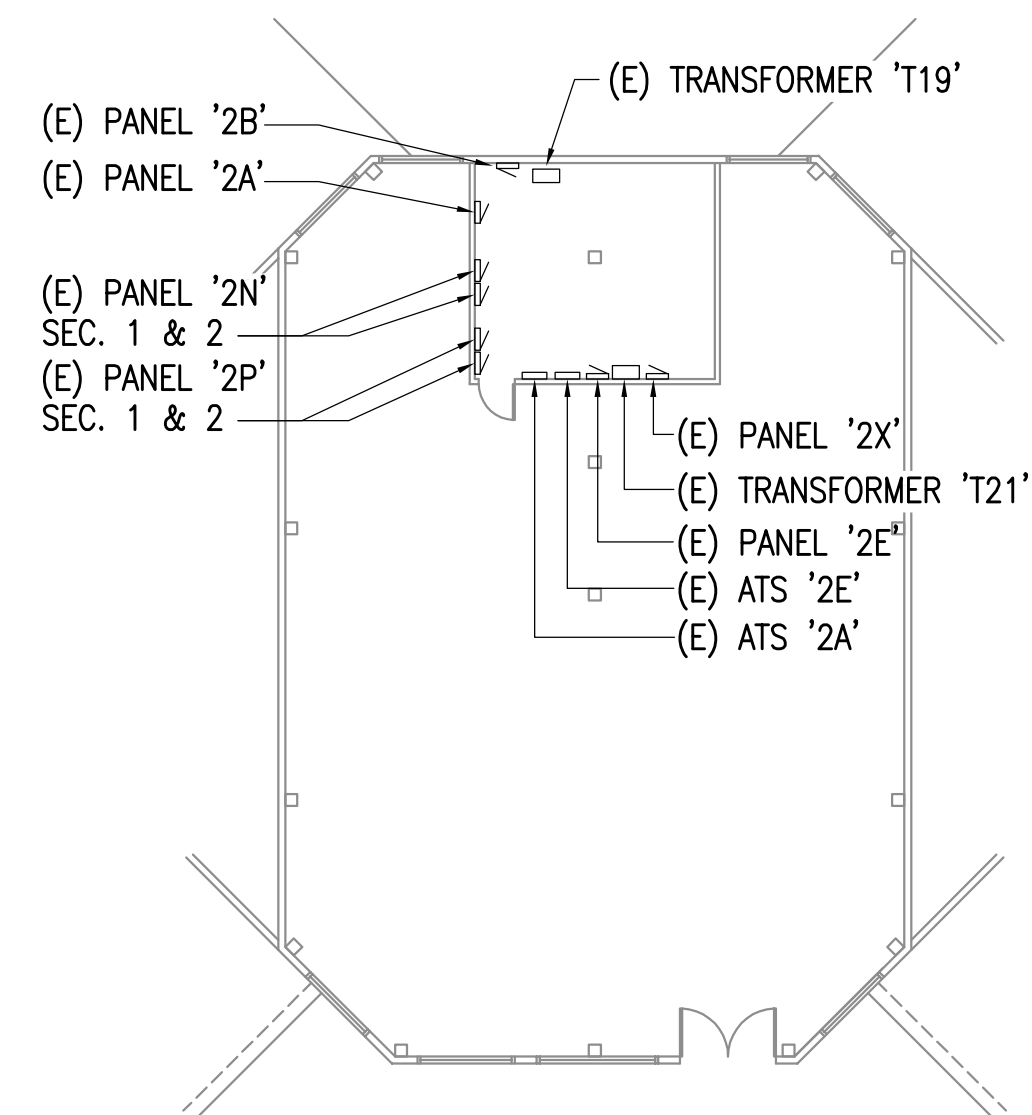

3 HOUSE #3 BUILDING PANEL MAP - MECHANICAL ROOM
1/16" = 1'-0"

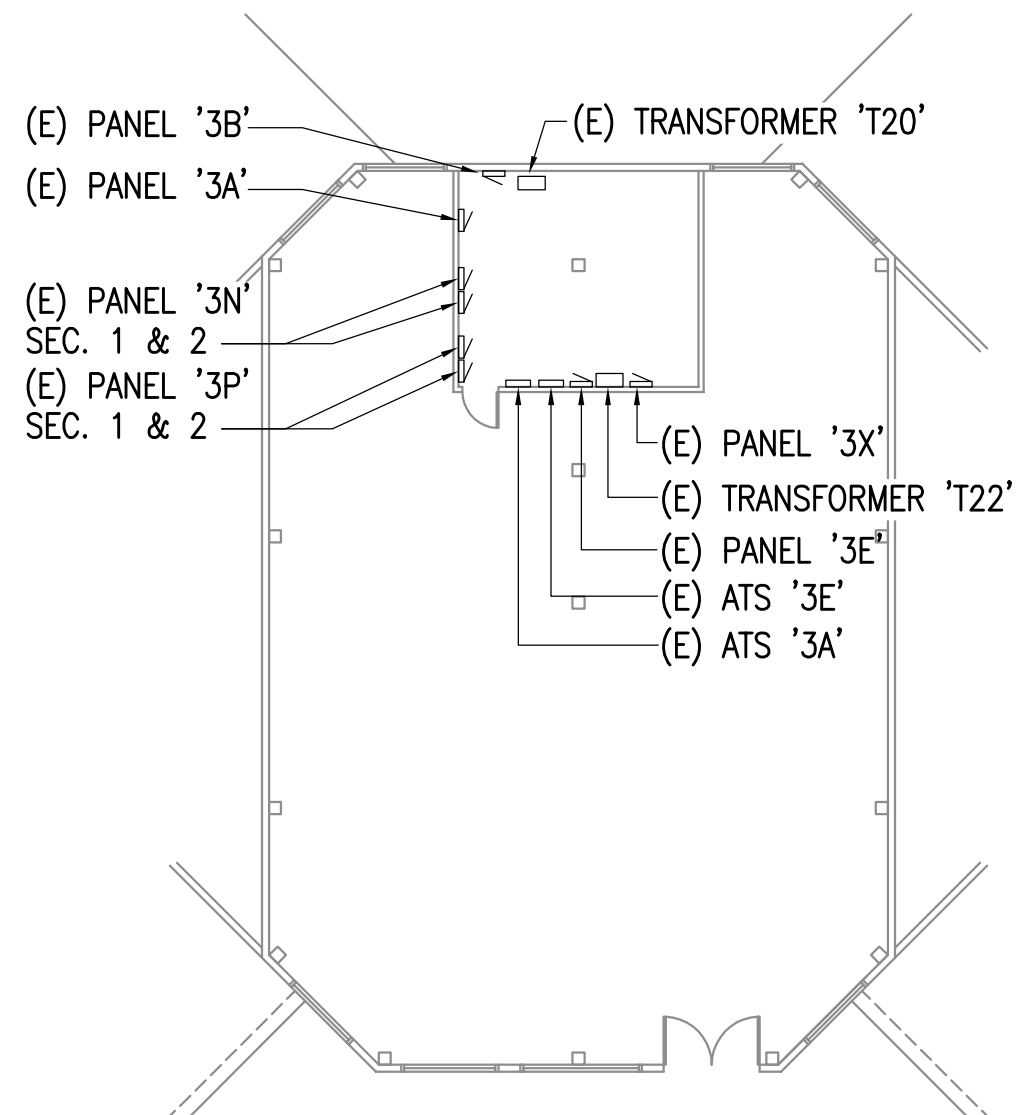

4 HOUSE #2 BUILDING PANEL MAP - MECHANICAL ROOM
1/16" = 1'-0"



REFERENCE
ONLY

ELECTRICAL ENGINEER
RSA ENGINEERING, INC.
670 W. Fireweed Ln., Suite 200
Anchorage, AK 99503-2516
Phone (907) 276-0521 Fax (907) 276-1751

State of Alaska
DOC Arc Flash Survey and Report
Spring Creek Correctional Center
Seward, AK


REVISIONS:

DRAWN BY: MJC
CHECKED BY: JAM
DATE: 10/13/2017
JOB NUMBER: L6206
DWG FILE: L6206_ESERIES


DRAWING TITLE:
HOUSE #2 & 3 BUILDING
PANEL MAP - 2ND. FLOOR

SHEET:
SC2.5


0"
1"
2"
3"

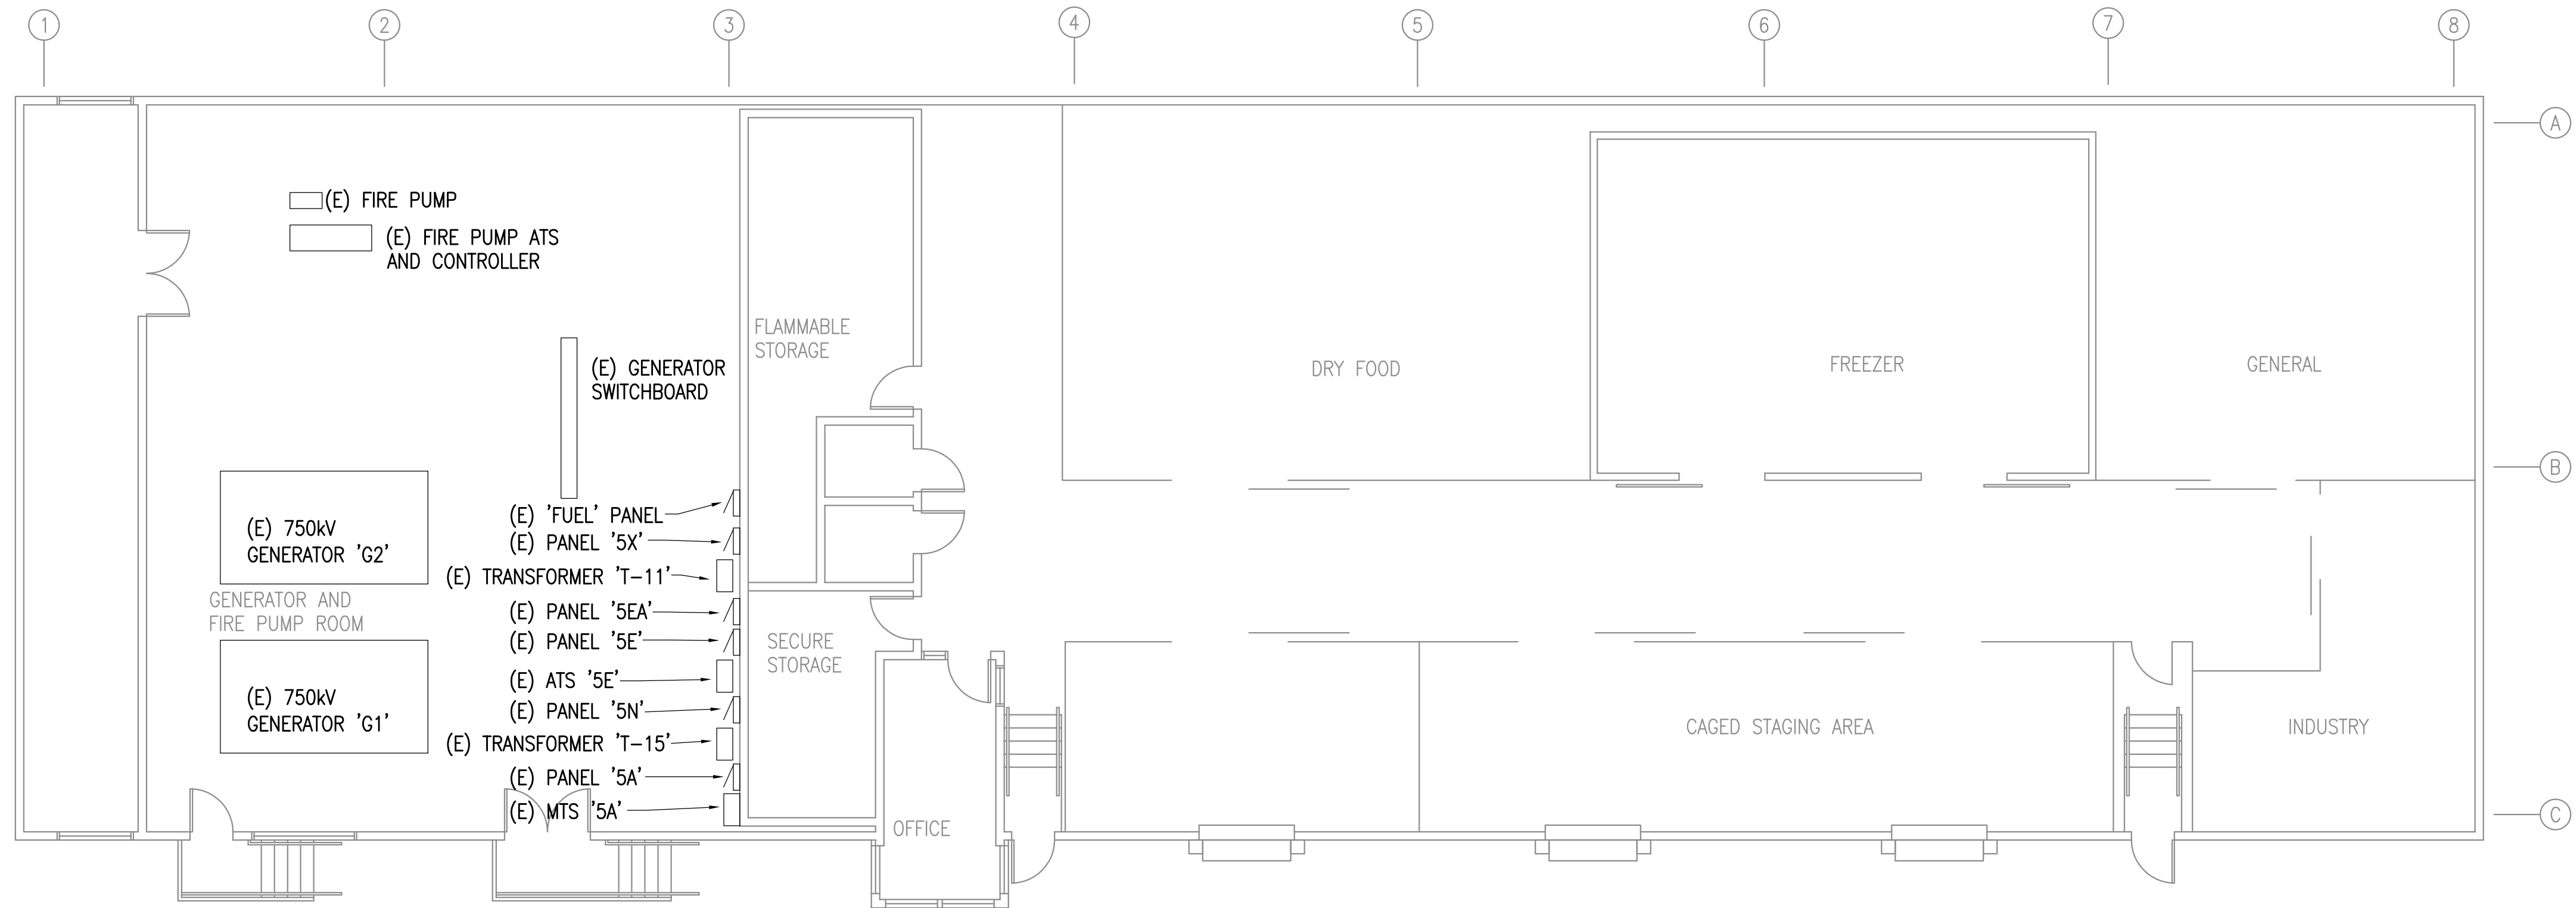

1 WAREHOUSE BUILDING PANEL MAP
1/8" = 1'-0"

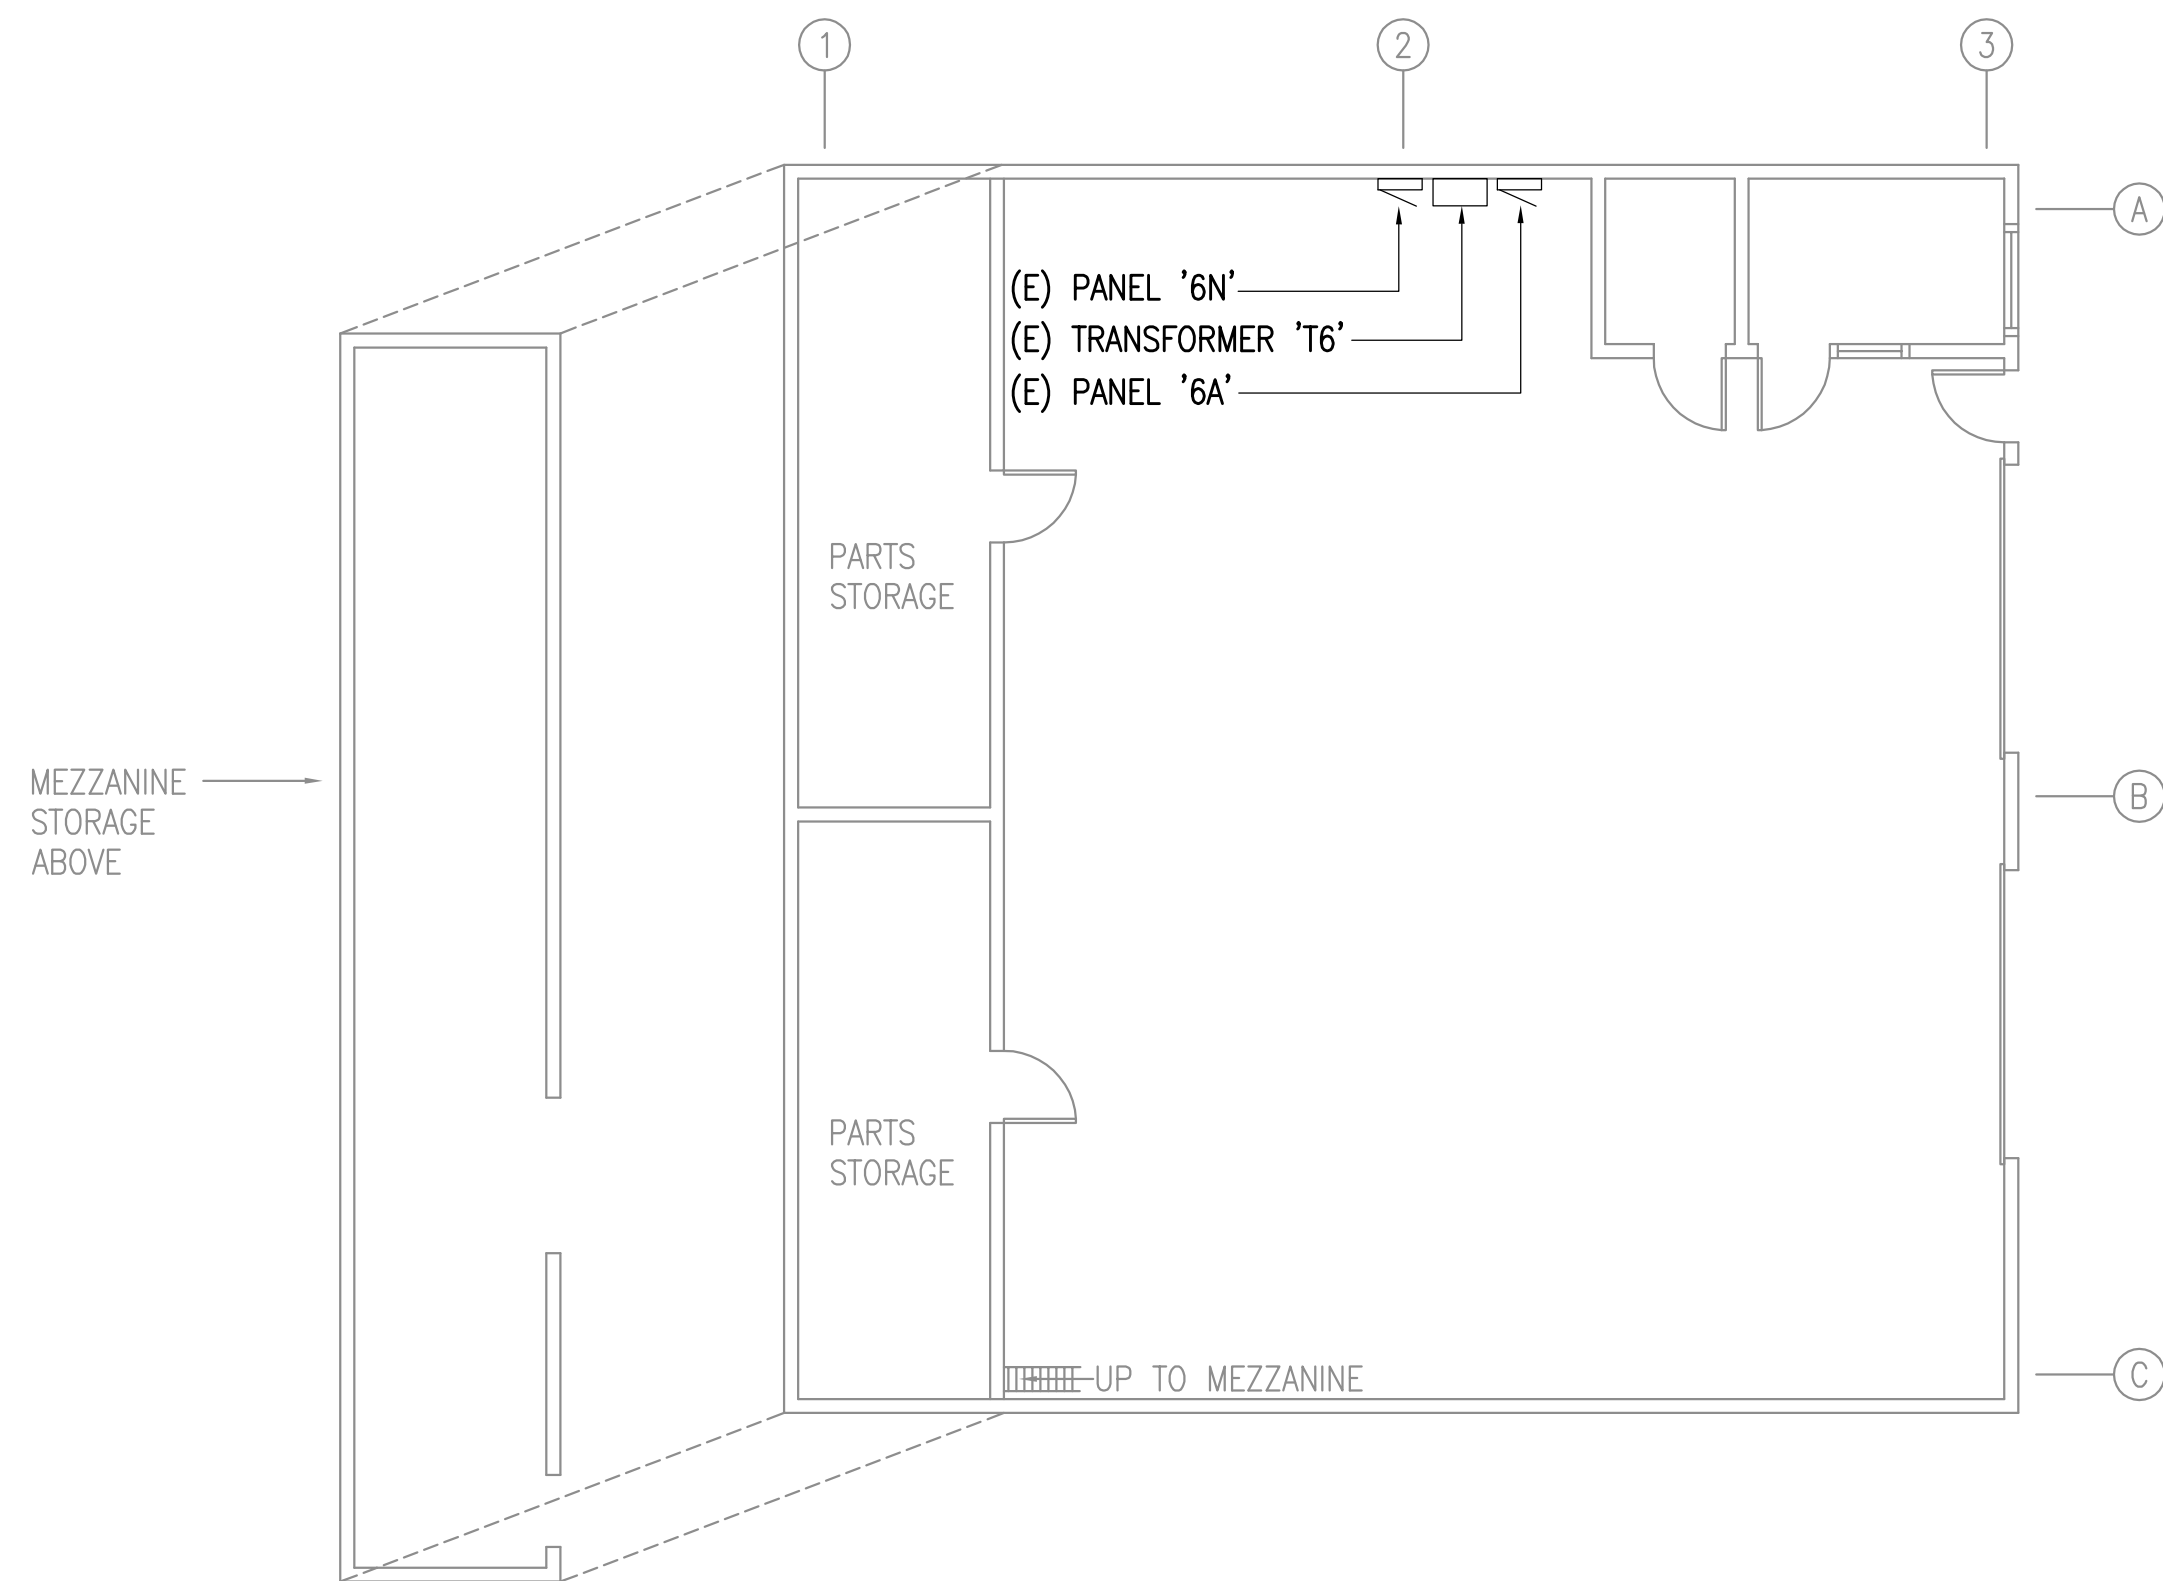

2 MOTOR POOL BUILDINGS PANEL MAP
1/8" = 1'-0"

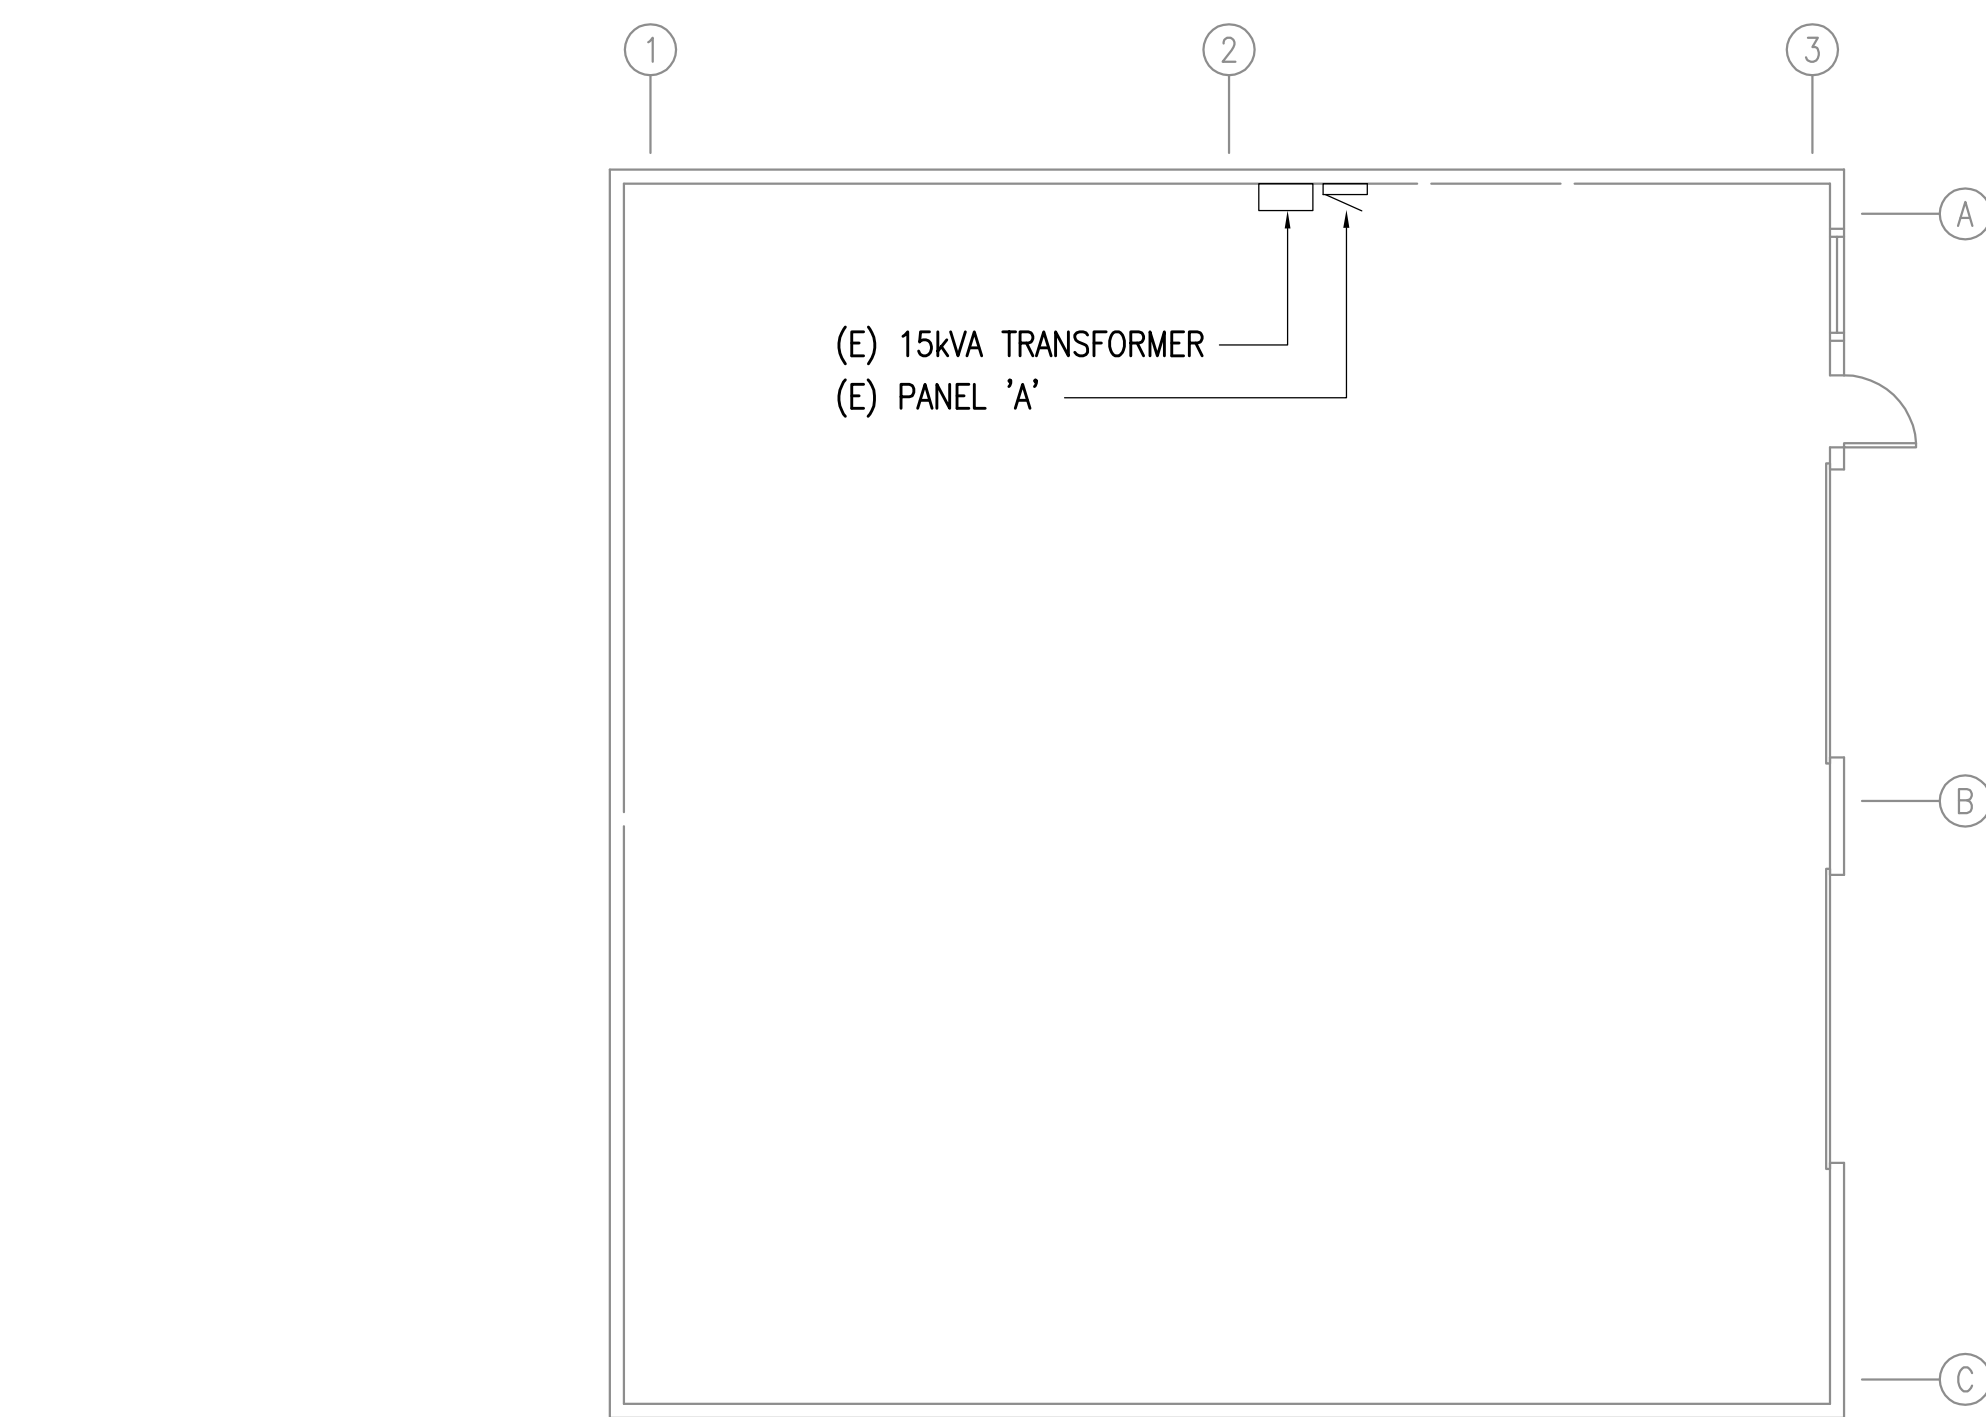

3 NEW MOTOR POOL BUILDING PANEL MAP
1/8" = 1'-0"



REFERENCE
ONLY

ELECTRICAL ENGINEER
RSA ENGINEERING, INC.
670 W. Fireweed Ln., Suite 200
Anchorage, AK 99503-2516
Phone (907) 276-0521 Fax (907) 276-1751

State of Alaska
DOC Arc Flash Survey and Report
Spring Creek Correctional Center
Seward, AK

REVISIONS:

DRAWN BY: MJC
CHECKED BY: JAM
DATE: 10/13/2017
JOB NUMBER: L6206
DWG FILE: L6206_ESERIES

DRAWING TITLE:
WAREHOUSE & MOTOR
POOL BUILDINGS PANEL
MAPS

SHEET:
SC2.6