



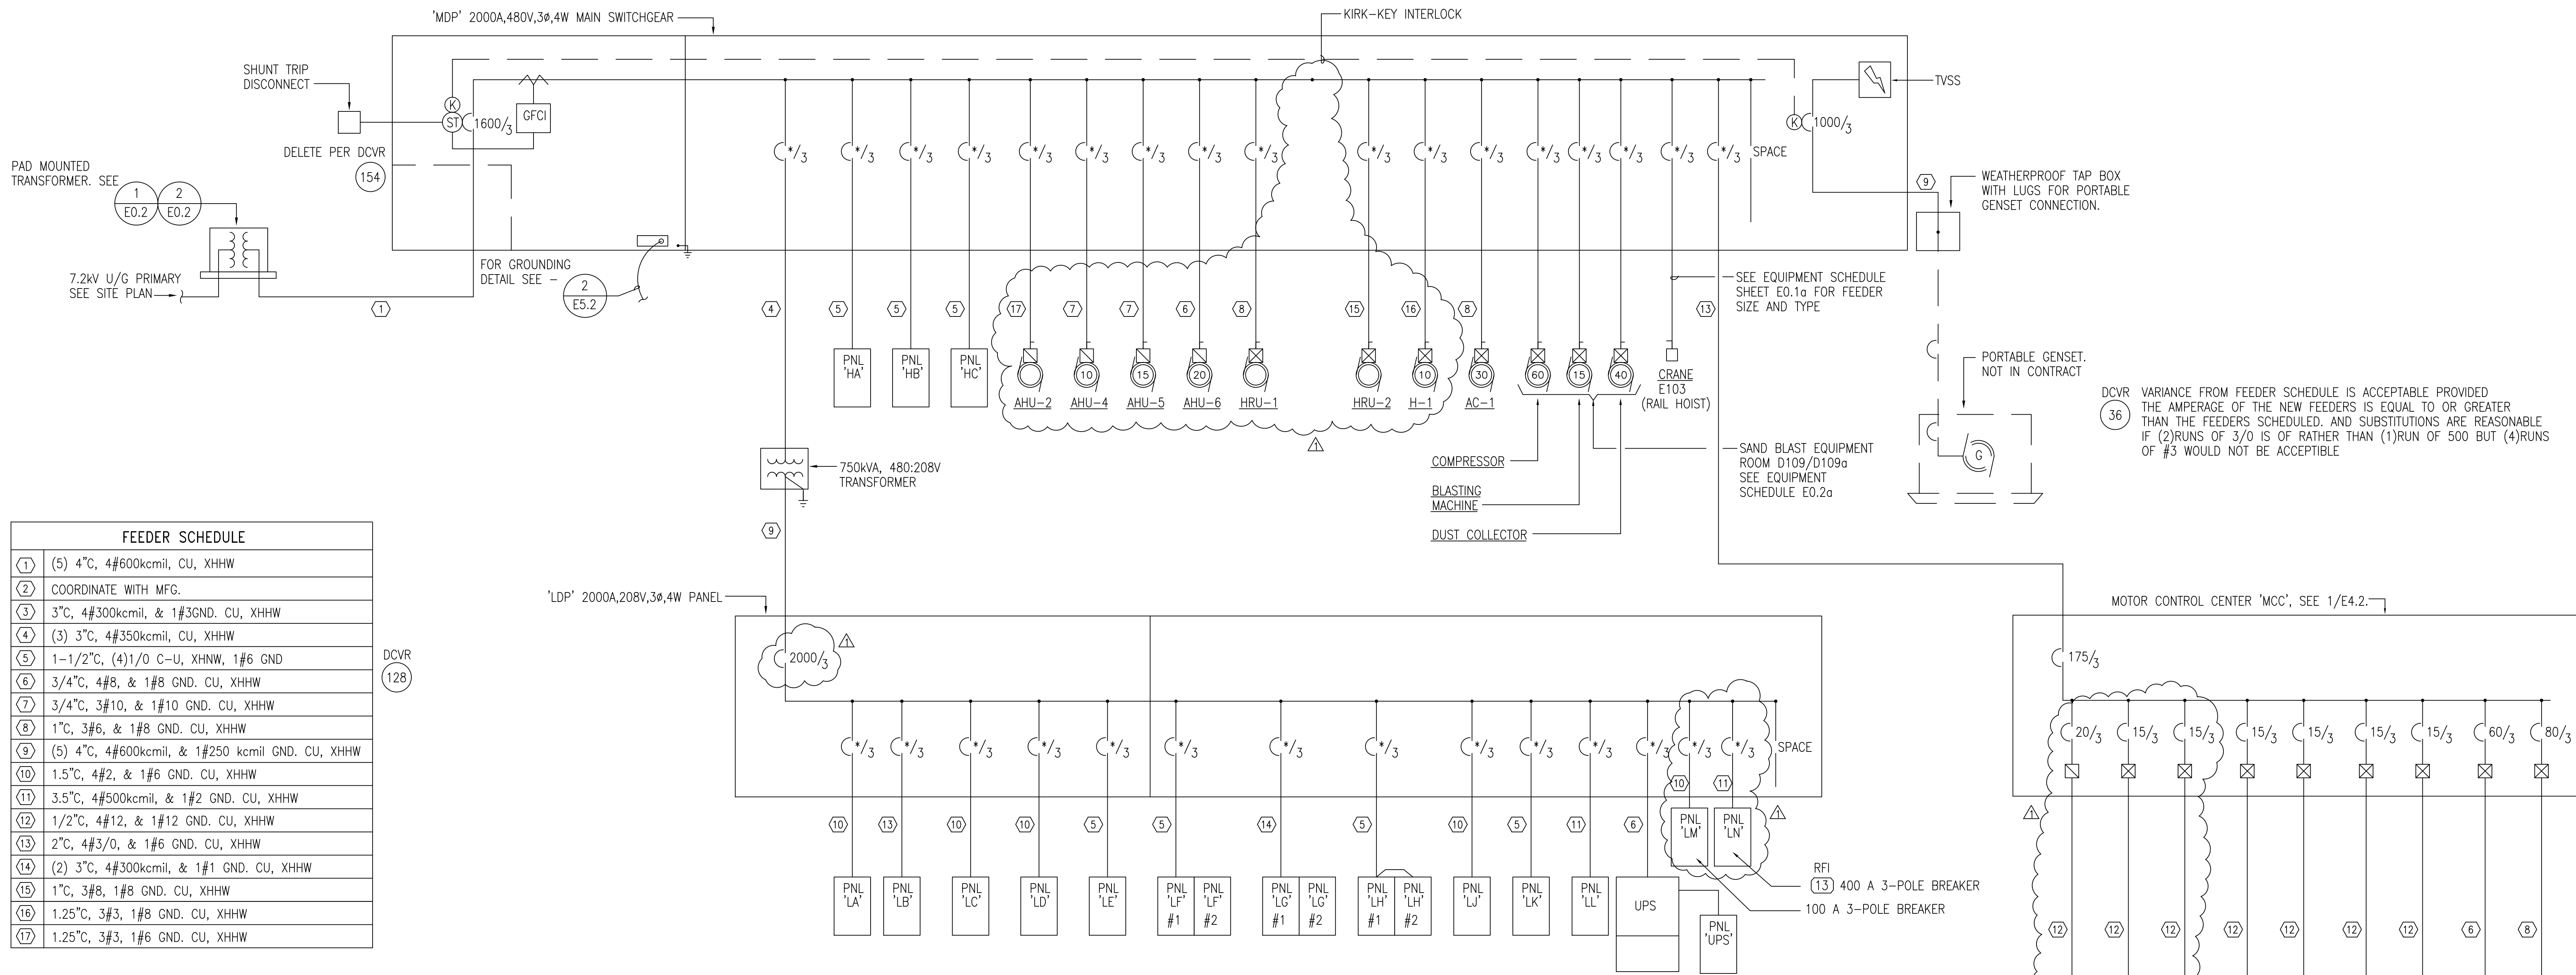


1 ELECTRICAL POWER ONE-LINE DIAGRAM

NTS

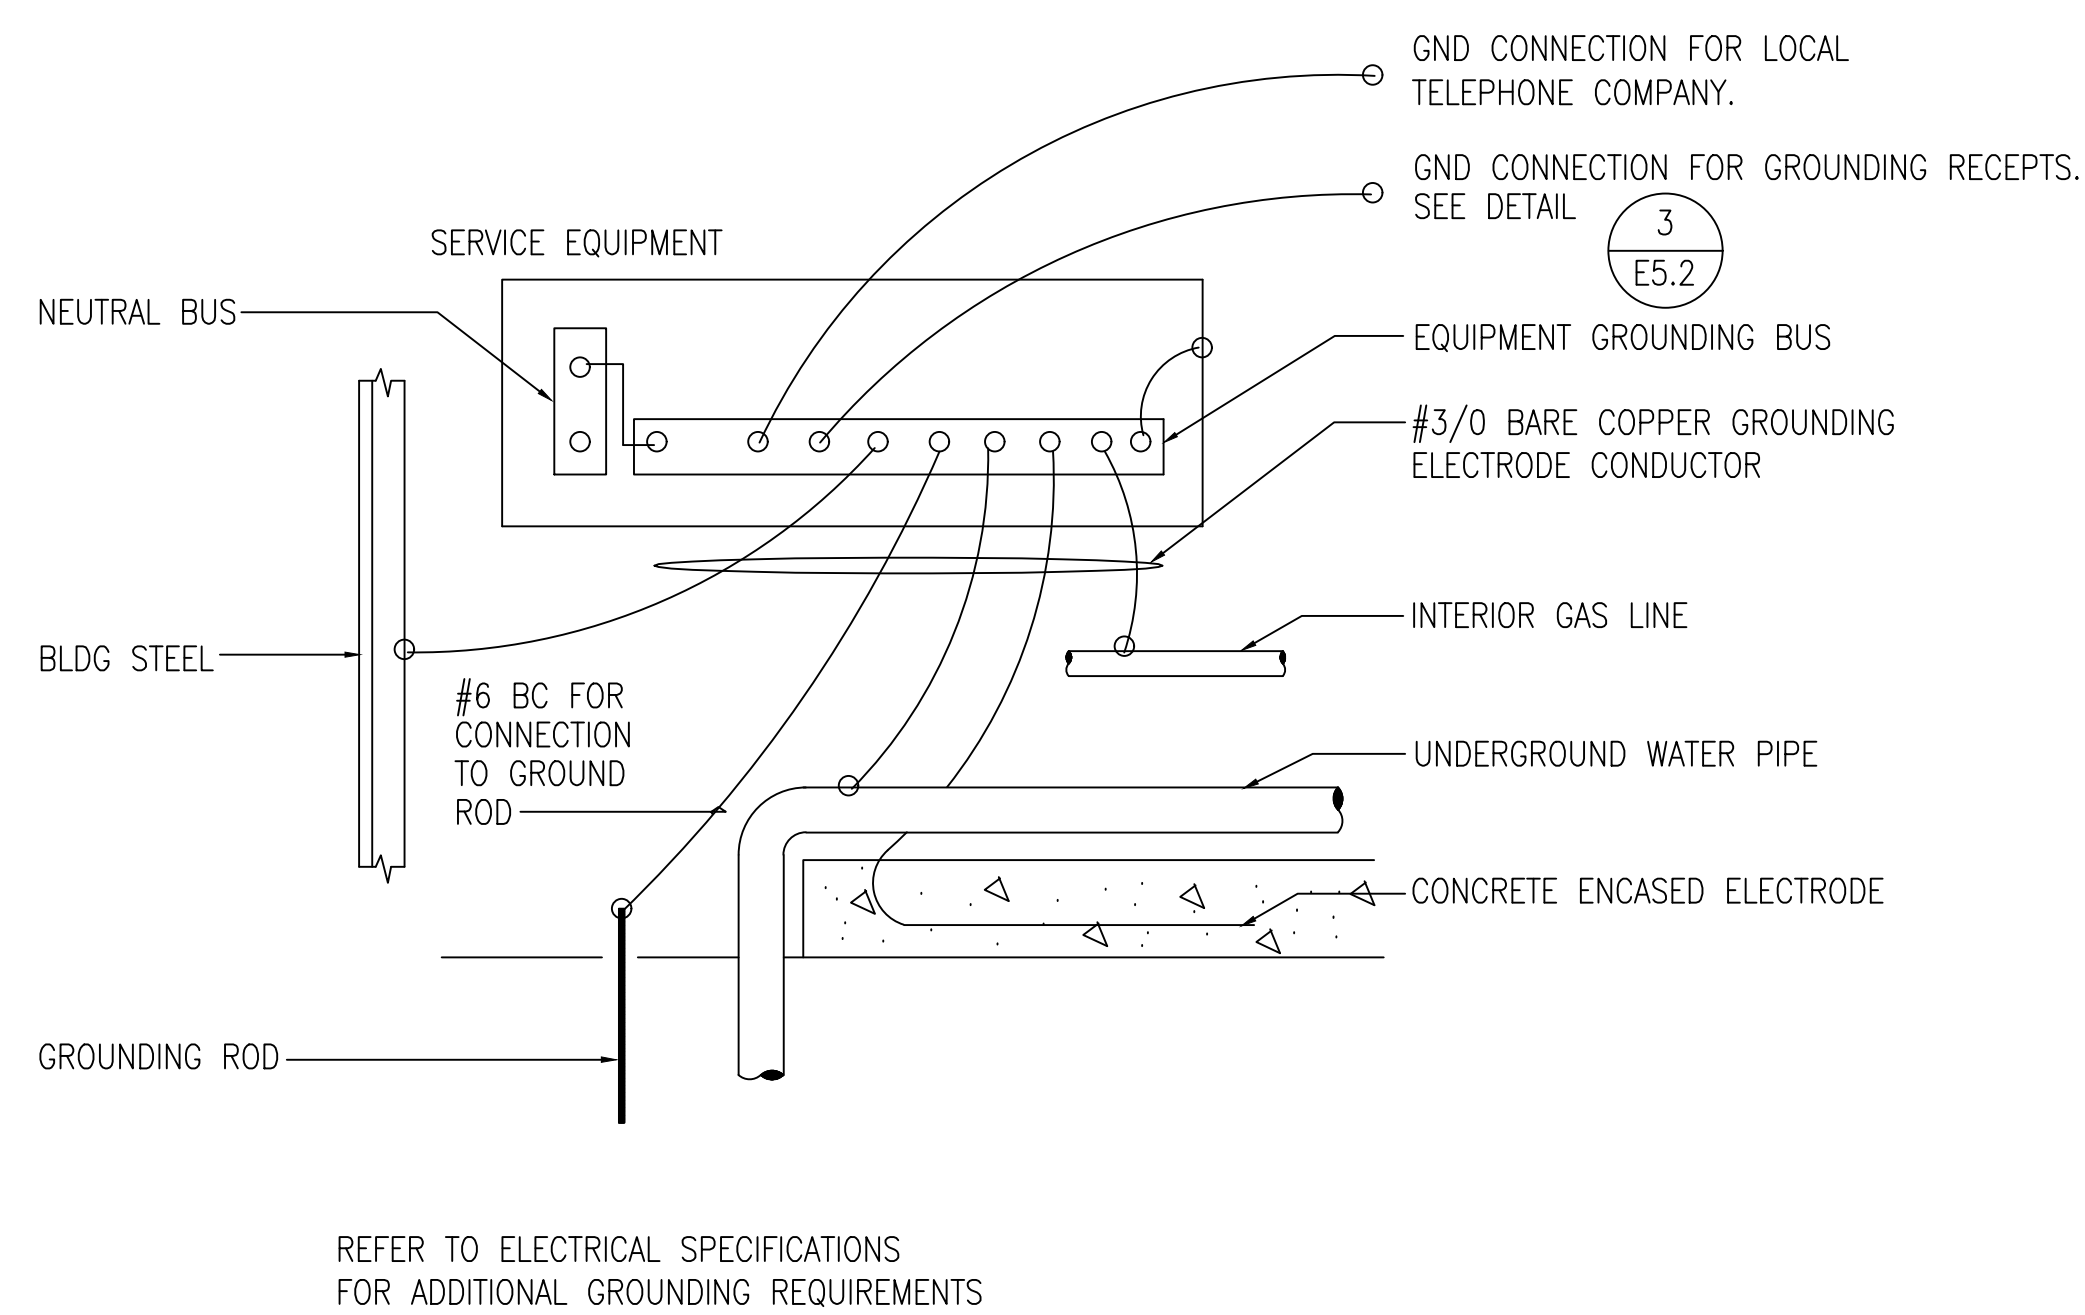


2 SERVICE GROUNDING DETAIL

NTS

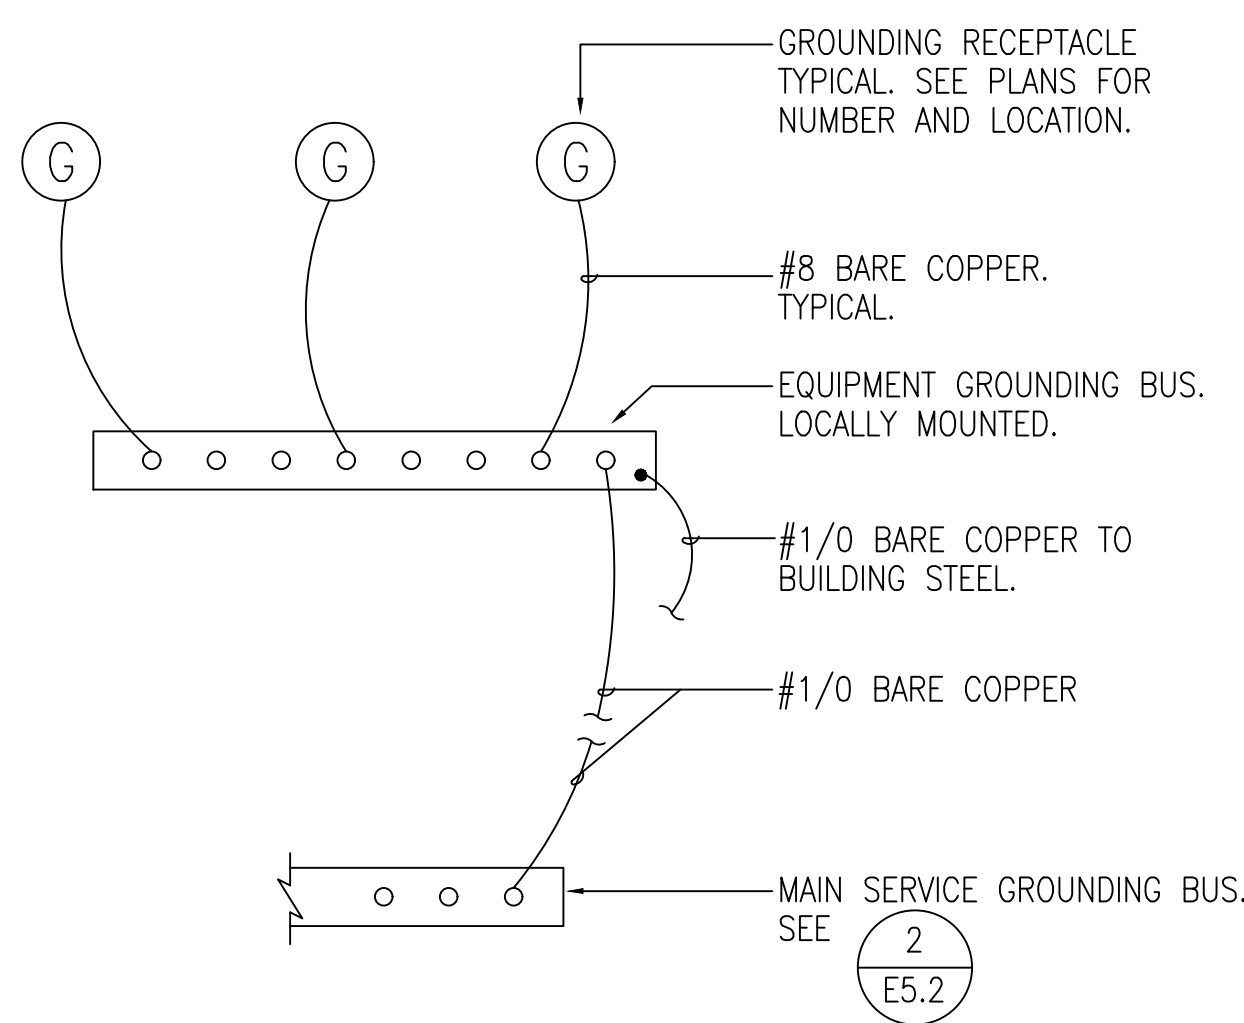


3 GROUNDING RECEPTACLE DETAIL

NTS

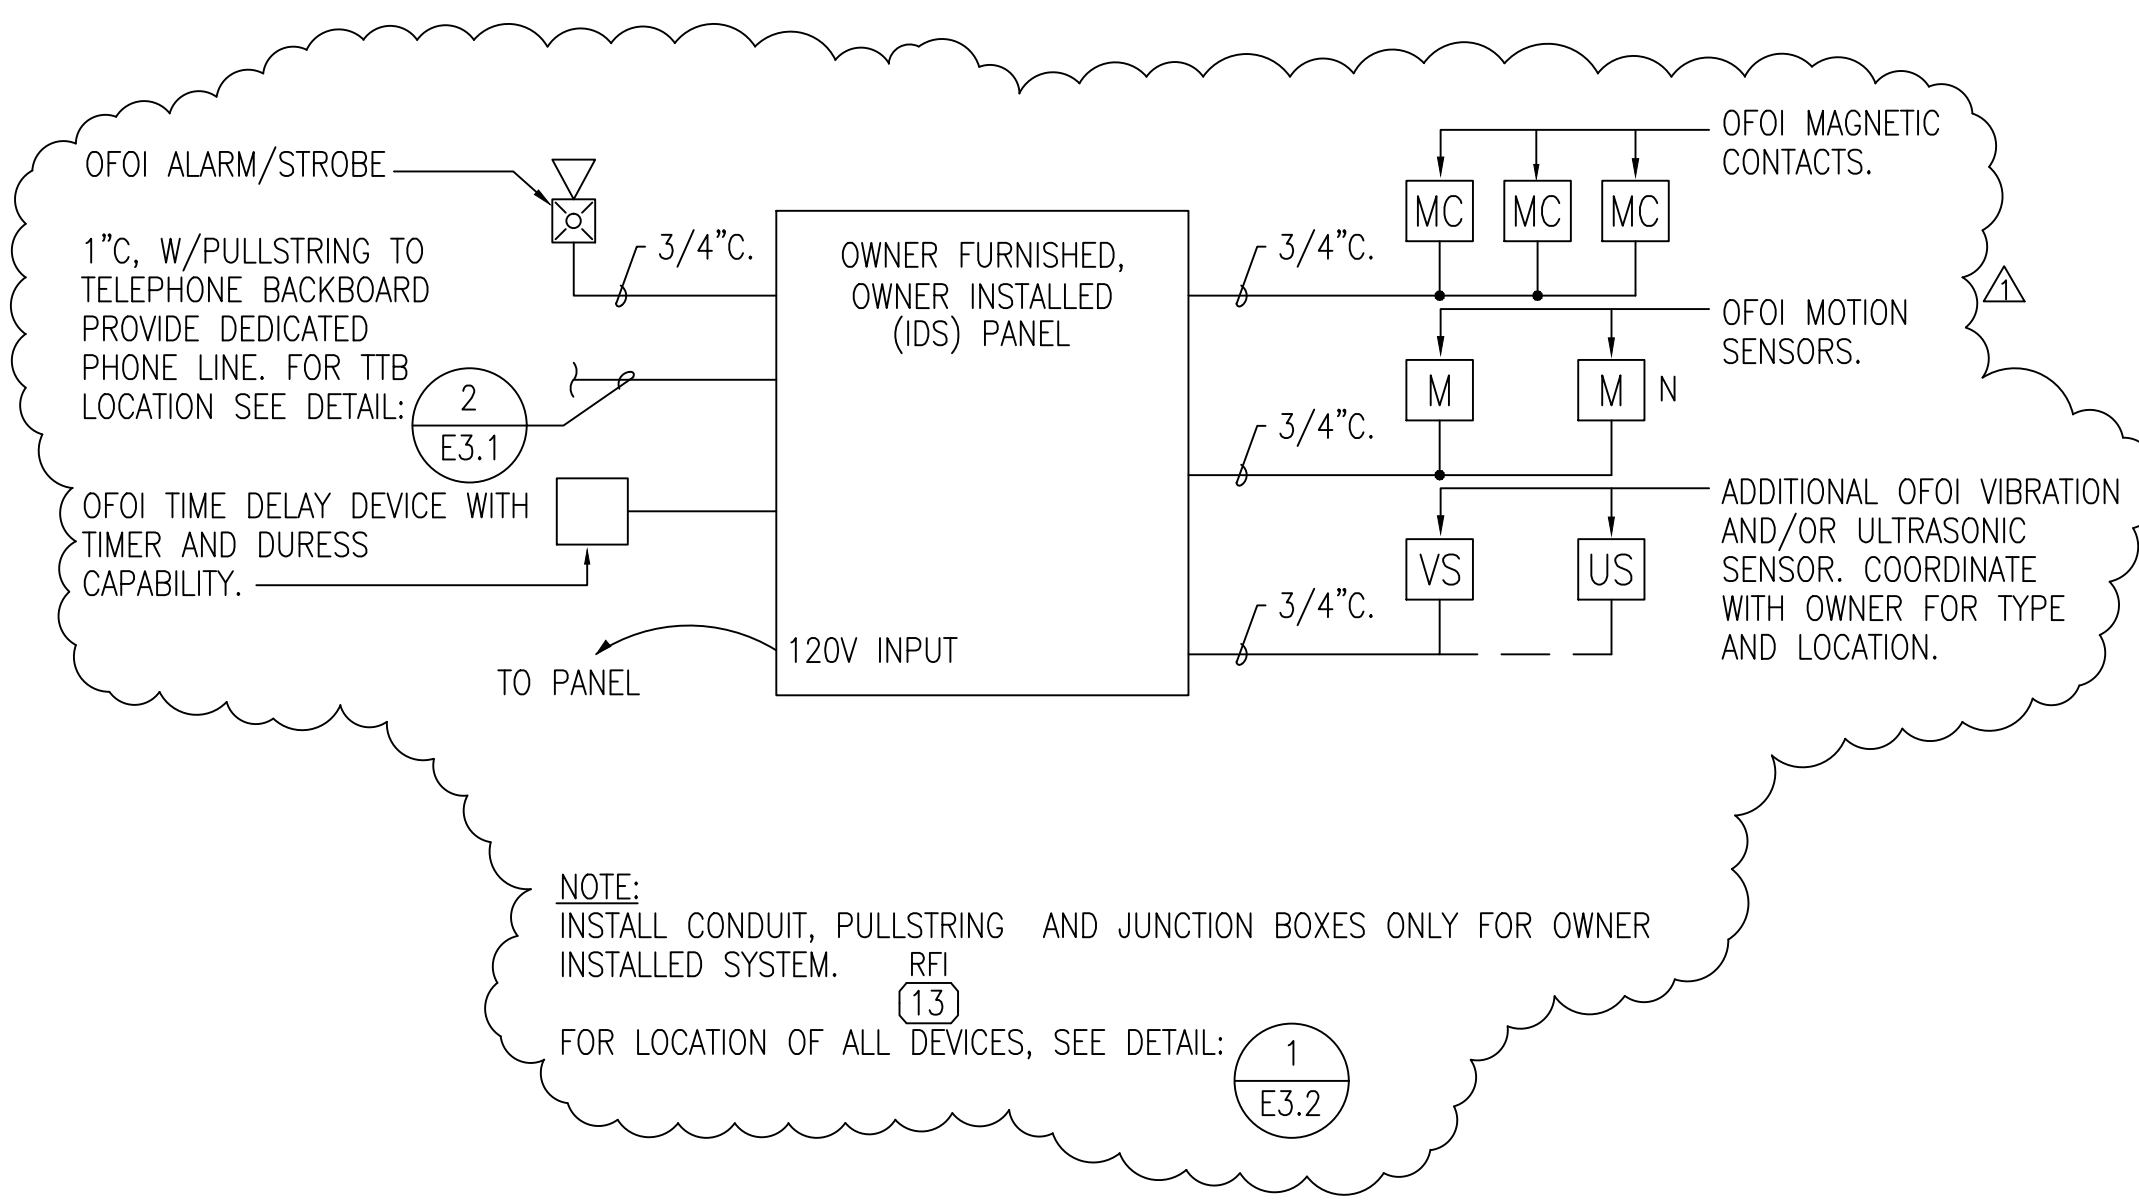

4 JOINT SERVICES INTERIOR INTRUSION DETECTION SYSTEM (JSIIDS) ONE-LINE DIAGRAM

NTS

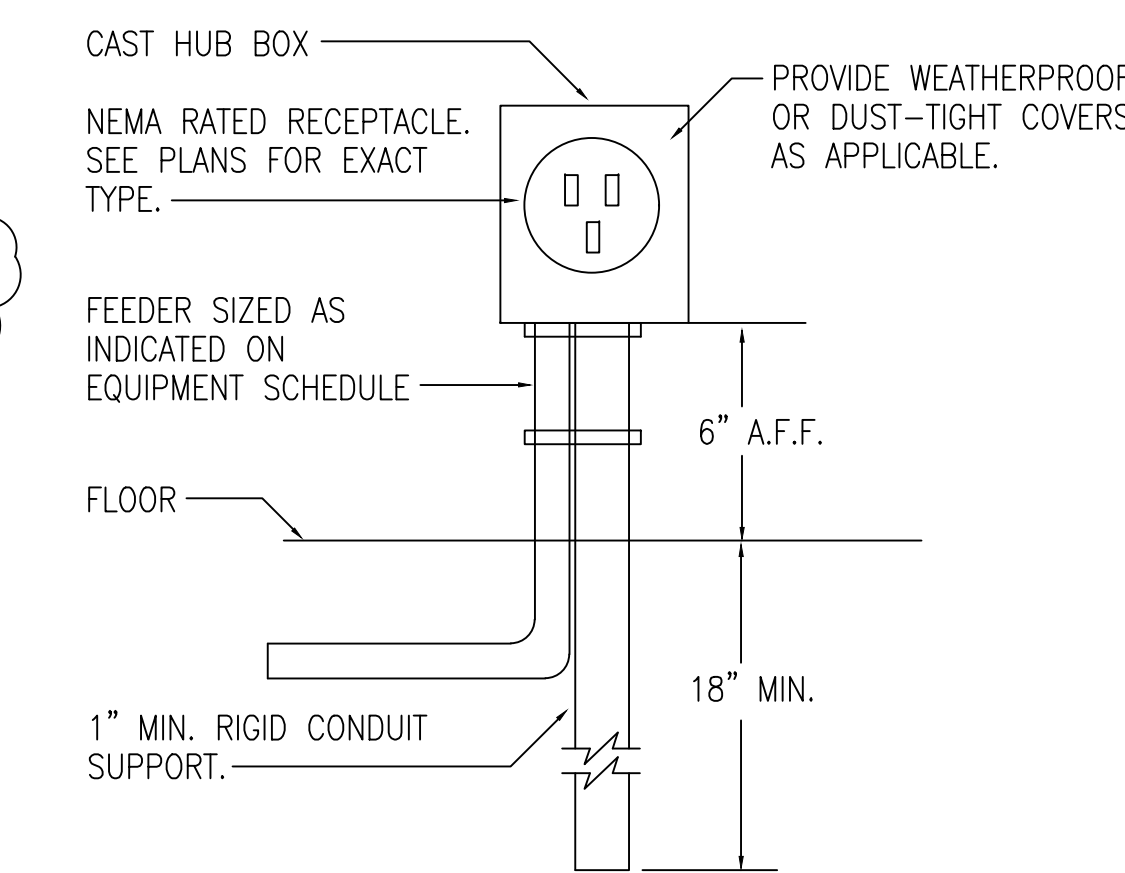

5 FLOOR BOX DETAIL

NTS

PROJECT RECORD DRAWINGS

THESE DRAWINGS HAVE BEEN PREPARED FROM INFORMATION FURNISHED BY THE GENERAL CONTRACTOR. THERE IS ABSOLUTELY NO GUARANTEE AS TO THE ACCURACY OF THE INFORMATION CONTAINED HEREIN, EITHER EXPRESSED OR IMPLIED.

RFI FEEDERS OVER 60 A TO BE IN RIGID STEEL CONDUIT INTERMEDIATE METAL CONDUIT CAN BE SUBSTITUTED FOR RIGID METAL CONDUIT UNLESS SPECIFICALLY NOTED.

RSIA Engineering, Inc.
MECHANICAL AND ELECTRICAL CONSULTING ENGINEERS
300 ARCTIC BLVD. SUITE 200 WILKINSON AL 99553-1907 (907) 276-4245



Date Stamped: _____

By: _____

Revision: _____

Date: _____

USKH
Architecture • Engineering
Land Surveying • Planning

2515 'A' Street
Anchorage, Alaska 99503
(907) 276-4245

3017 Clinton Drive, Ste. 201
Juneau, Alaska 99801
(907) 790-2901

1830 Second Ave.
Fairbanks, Alaska 99701
(907) 452-2128

809 S. Chugach St., Ste. 1
Palmer, Alaska 99645
(907) 746-7815

Project:
ALASKA NATIONAL GUARD CSMS/UTES

CONFORMED DOCUMENTS

Project Mgr.	W.W.A.
Drawn	X
Drawn	
Checked	
Date	15 SEPTEMBER 2000

Sheet Contents:

ELEC. DIAGRAMS
POWER ONE-LINE
DIAGRAM
DCVR RFI
(128) (13)
(154)
(36)

Sheet No.:
E5.2

USKH W.O. 584201