


MECHANICAL DRAWING INDEX

Sheet Number	Sheet Name
T1	COVER SHEET
M1.0	LEGEND AND SCHEDULES
M1.1	SPECIFICATIONS
M2.0	FLOOR PLAN - SUPPLY AIR BALANCE
M2.1	FLOOR PLAN - EXHAUST AIR BALANCE
M3.0	FLOOR PLAN - THERMAL ZONE BOUNDARIES
M4.0	ENLARGED MECHANICAL ROOM PLAN - LOWER LEVEL
M4.1	ENLARGED PLANS

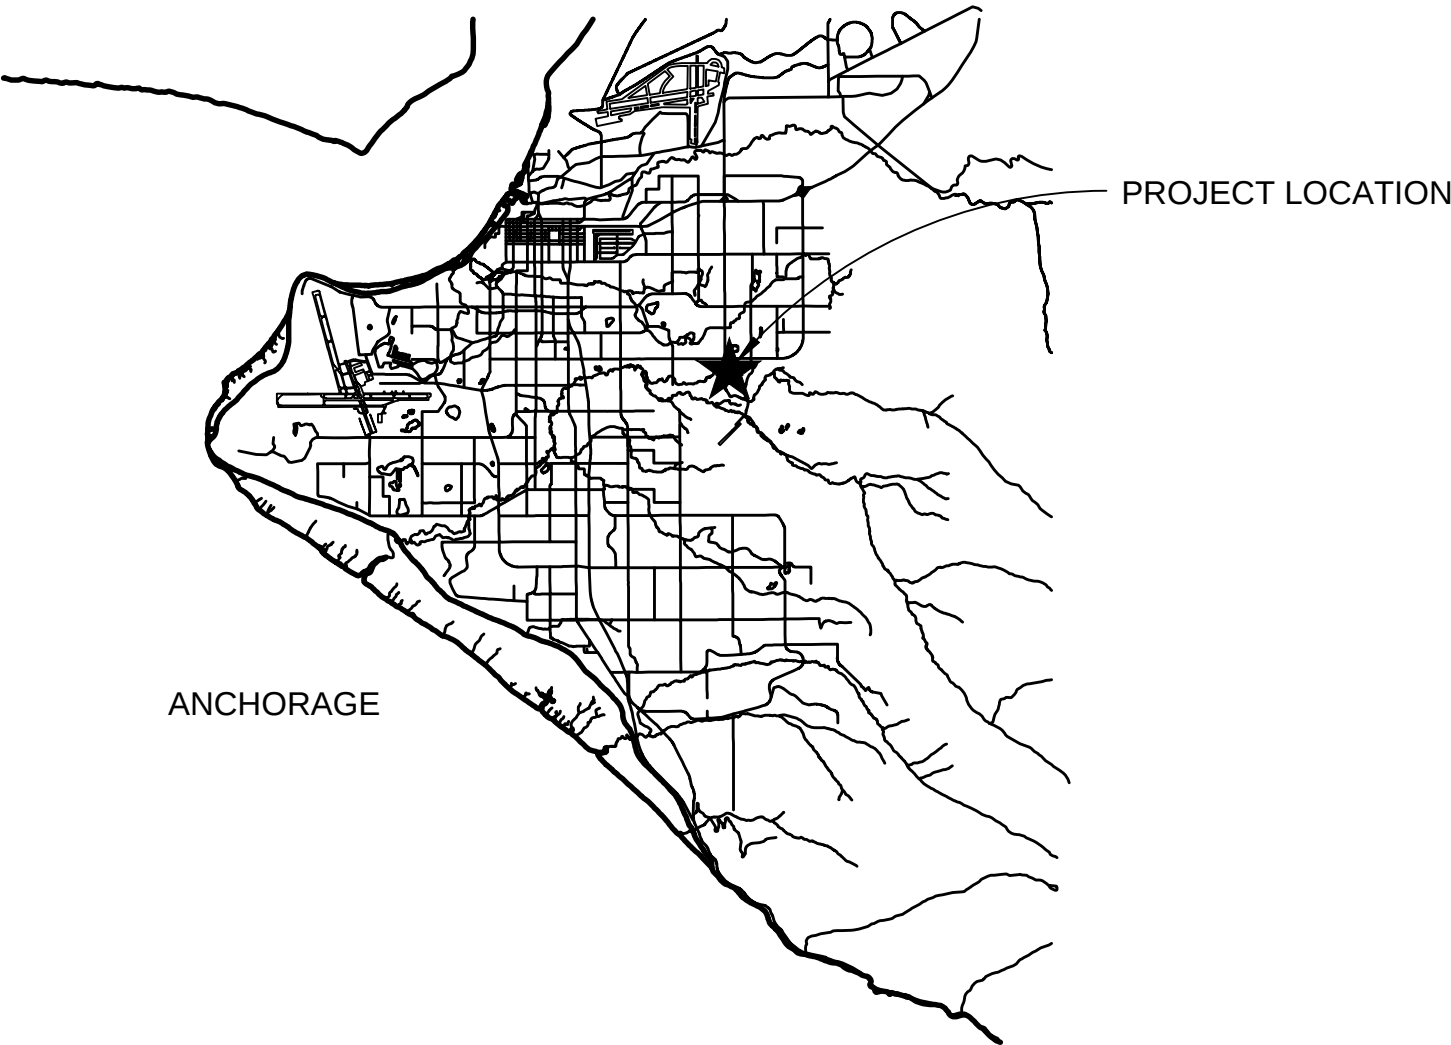

ALASKA BUREAU OF
INVESTIGATION
HVAC RENOVATON PROJECT
DPS PROJECT NO. 12-133434F

 
5500 E. TUDOR ROAD
ANCHORAGE, ALASKA 99507



PROJECT OWNER:
STATE OF ALASKA
DEPARTMENT OF PUBLIC SAFETY -
DIVISION OF ADMIN. SUPPLY SECTION
524 E. 48TH AVE
Anchorage, AK 99503
Phone: (907) 929-8952

PROJECT MANAGER:
AMERESCO
6643 Brayton Dr
Anchorage, AK 99507
Phone: (907) 278-1880

MECHANICAL ENGINEERS:
JERNSTROM ENGINEERING, LLC
6927 Old Seward Hwy, Suite 202
Anchorage, AK 99518
Phone: (907) 522-1042




JERNSTROM ENGINEERING
CONSULTING MECHANICAL ENGINEERS
6927 Old Seward Hwy, Suite 202, Anchorage, Alaska 99518
Phone: (907) 522-1042 Fax: (907) 522-1052
E-mail: rjernstrom@jernstromengineering.com

ALASKA BUREAU OF INVESTIGATION BUILDING
HVAC RENOVATION PROJECT
5500 E TUDOR ROAD
ANCHORAGE, ALASKA 99507

TITLE SHEET

Revisions	
Date	4/30/15
Drawn	JJ
Check	RJ
Project	2015-19

 Sheet No.
T 1



JERNSTROM ENGINEERING
CONSULTING MECHANICAL ENGINEERS
6927 Old Seward Hwy, Suite 202, Anchorage, Alaska 99518
Phone: (907) 522-1042 Fax: (907) 522-1052
Email: rjernstrom@jernstromengineering.com

ALASKA BUREAU OF INVESTIGATION BUILDING
HVAC RENOVATION PROJECT
5500 E TUDOR ROAD
ANCHORAGE, ALASKA 99507

LEGEND AND SCHEDULES


Revisions	
Date	4/30/15
Drawn	JJ
Check	RJ
Project	2015-19

Sheet No.

M1.0

MECHANICAL LEGEND AND ABBREVIATIONS																																																																																																																																									
GENERAL ABBREVIATIONS		PIPING SYSTEM REFERENCES																																																																																																																																							
ADA AMERICAN W/DISABILITIES ACT APPROX. APPROXIMATE ARCH ARCHITECT, ARCHITECTURAL BB BASEBOARD BHP BRAKE HORSEPOWER BMS BUILDING AUTOMATION SYSTEM BTU BTU PER HOUR BTUH BTU PER HOUR CFM CUBIC FEET PER MINUTE CO CARBON MONOXIDE CO2 CARBON DIOXIDE CONN. CONNECTION dB DECIBEL DB DRY BULB (AIR) DDC DIRECT DIGITAL CONTROL DEG. DEGREE DMPR DAMPER DN DOWN DPS DIFFERENTIAL PRESSURE SENSOR DWV DRAIN WASTE AND VENT EA EACH EAT ENTERING AIR TEMPERATURE EGT ENTERING GLYCOL TEMPERATURE ELEC ELECTRICAL ESP EXTERNAL STATIC PRESSURE EWT ENTERING WATER (GLYCOL) TEMPERATURE (E) EXISTING F FAHRENHEIT FDC FIRE DEPARTMENT CONNECTION FPM FEET PER MINUTE GAL GALLON GALV. GALVANIZED GC GENERAL CONTRACTOR GPH GALLON PER HOUR GPM GALLON PER MINUTE HP HORSEPOWER (ELEC.) Hz HERTZ (ELEC.) IAQ INDOOR AIR QUALITY IN.W.C. INCH. WATER COLUMN KW KILOWATT KWH KILOWATT HOUR LAT LEAVING AIR TEMPERATURE LB POUND LGT LEAVING GLYCOL TEMPERATURE LWT LEAVING WATER TEMPERATURE MAT MIXED AIR TEMPERATURE MAX MAXIMUM MBH 1,000 BTU PER HOUR MECH MECHANICAL MIN. MINIMUM MISC. MISCELLANEOUS NC NORMALLY CLOSED NIC NOT IN CONTRACT NO NORMALLY OPEN NTS NOT TO SCALE OAT OUTSIDE AIR TEMPERATURE OFCI OWNER FURNISHED CONTRACTOR INSTALLED OFOI OWNER FURNISHED OWNER INSTALLED PD PRESSURE DROP PG PROPYLENE GLYCOL PH PHASE (ELEC) PSI POUND PER SQUARE INCH PSIA PSI ABSOLUTE PSIG PSI GAGE RPBFP REDUCED PRESSURE BACKFLOW PREVENTER RPM REVOLUTION PER MINUTE SEC. SECOND SL ACOUSTIC OR SOUND LINED SS STAINLESS STEEL TEMP. TEMPERATURE TP TRAP PRIMER TYP TYPICAL V VOLT (ELEC.) VEL. VELOCITY VFD VARIABLE FREQUENCY DRIVE VTR VENT THRU ROOF W/ WITH W/O WITHOUT WB WET BULB ADDITIONAL ABBREVIATIONS NOTED BY EQUIPMENT TAGS, SYSTEM SYMBOLS, AND ACRONYMS GENERALLY ACCEPTED BY THE INDUSTRY SHALL BE APPLICABLE.		PLUMBING SYSTEMS CW DOMESTIC COLD WATER NPW NON-POTABLE COLD WATER HW DOMESTIC HOT WATER HWC DOMESTIC HOT WATER CIRCULATION ID INDIRECT DRAIN PS PRESSURE SEWER PW PUMPED WASTE RL RAIN LEADER V SANITARY VENT W SANITARY WASTE FUEL GAS SYSTEMS G NATURAL GAS FOR FUEL OIL RETURN FOS FUEL OIL SUPPLY FIRE PROTECTION SYSTEMS SP FIRE PROTECTION SPRINKLER PIPING F FIRE MAIN FDC FIRE DEPARTMENT CONNECTION HYDRONIC SYSTEMS CWR CHILLED WATER RETURN CWS CHILLED WATER SUPPLY HWR HEATING WATER RETURN HWS HEATING WATER SUPPLY GR GLYCOL RETURN GS GLYCOL SUPPLY																																																																																																																																							
GRAPHIC REFERENCES		PIPING COMPONENTS AND ASSEMBLIES																																																																																																																																							
AFF ABOVE FINISHED FLOOR AFG ABOVE FINISHED GRADE BOD BOTTOM OF DUCT BOP BOTTOM OF PIPE CL CENTER LINE ELEV. ELEVATION FFL FINISHED FLOOR LEVEL INV. INVERT TOD TOP OF DUCT TOP TOP OF PIPE OC ON CENTER		<table><tr><th>SYMBOL</th><th>ABBREV.</th><th>DESCRIPTION</th></tr><tr><td></td><td></td><td>PIPE UP</td></tr><tr><td></td><td></td><td>PIPE DOWN</td></tr><tr><td></td><td></td><td>PIPE TEE UP</td></tr><tr><td></td><td></td><td>PIPE TEE DOWN</td></tr><tr><td></td><td></td><td>FIXTURE CONNECTIONS/STOPS</td></tr><tr><td></td><td>FD</td><td>FLOOR DRAIN</td></tr><tr><td></td><td>RD</td><td>ROOF DRAIN</td></tr><tr><td></td><td>ORD</td><td>OVERFLOW ROOF DRAIN</td></tr><tr><td></td><td>CO</td><td>CLEANOUT, PIPE END PLUG</td></tr><tr><td></td><td>WCO</td><td>CLEANOUT, WALL, CONCEALED</td></tr><tr><td></td><td>FCO</td><td>CLEANOUT, FLOOR</td></tr><tr><td></td><td>YCO</td><td>CLEANOUT, YARD</td></tr><tr><td></td><td></td><td>W/CONCRETE COLLAR</td></tr><tr><td></td><td>WHA</td><td>WATER HAMMER ARRESTOR</td></tr><tr><td></td><td>AAV</td><td>AUTOMATIC AIR VENT</td></tr><tr><td></td><td></td><td>W/SHUT-OFF VALVE(NOT SHOWN)</td></tr><tr><td></td><td>MAV</td><td>MANUAL AIR VENT</td></tr><tr><td></td><td></td><td>W/SHUT-OFF VALVE(NOT SHOWN)</td></tr><tr><td></td><td>VTR</td><td>VENT THROUGH ROOF</td></tr><tr><td></td><td>TP</td><td>TRAP PRIMER, AUTOMATIC</td></tr><tr><td></td><td></td><td>GATE VALVE / SHUT-OFF VALVE /</td></tr><tr><td></td><td></td><td>BALL VALVE</td></tr><tr><td></td><td></td><td>GLOBE VALVE</td></tr><tr><td></td><td></td><td>CHECK VALVE</td></tr><tr><td></td><td></td><td>NON-SLAM CHECK VALVE</td></tr><tr><td></td><td>ST</td><td>STRAINER, IN-LINE W/HOSE-END DRAIN</td></tr><tr><td></td><td></td><td>DRAIN VALVE W/HOSE END</td></tr><tr><td></td><td>BLV</td><td>BALANCING VALVE</td></tr><tr><td></td><td>FCV</td><td>FLOW CONTROL VALVE</td></tr><tr><td></td><td>MOV</td><td>CONTROL VALVE, 2-WAY</td></tr><tr><td></td><td>3MV</td><td>CONTROL VALVE, 3-WAY MIXING</td></tr><tr><td></td><td>3DV</td><td>CONTROL VALVE, 3-WAY DIVERTING</td></tr><tr><td></td><td>RV</td><td>RELIEF VALVE</td></tr><tr><td></td><td></td><td>PRESSURE GAGE W/ ISOLATION VALVE</td></tr><tr><td></td><td></td><td>PRESSURE REDUCING VALVE</td></tr><tr><td></td><td></td><td>PIPE REDUCER</td></tr><tr><td></td><td></td><td>UNION CONNECTION</td></tr><tr><td></td><td></td><td>FLANGE CONNECTION</td></tr><tr><td></td><td></td><td>FLEXIBLE JOINT</td></tr><tr><td></td><td></td><td>PIPE ANCHOR</td></tr><tr><td></td><td></td><td>PIPE ALIGNMENT GUIDE</td></tr><tr><td></td><td></td><td>PIPING SEISMIC FLEXIBLE JOINT</td></tr><tr><td></td><td></td><td>PIPE EXPANSION COMPENSATOR</td></tr><tr><td></td><td>POC</td><td>POINT OF CONNECTION</td></tr></table>	SYMBOL	ABBREV.	DESCRIPTION			PIPE UP			PIPE DOWN			PIPE TEE UP			PIPE TEE DOWN			FIXTURE CONNECTIONS/STOPS		FD	FLOOR DRAIN		RD	ROOF DRAIN		ORD	OVERFLOW ROOF DRAIN		CO	CLEANOUT, PIPE END PLUG		WCO	CLEANOUT, WALL, CONCEALED		FCO	CLEANOUT, FLOOR		YCO	CLEANOUT, YARD			W/CONCRETE COLLAR		WHA	WATER HAMMER ARRESTOR		AAV	AUTOMATIC AIR VENT			W/SHUT-OFF VALVE(NOT SHOWN)		MAV	MANUAL AIR VENT			W/SHUT-OFF VALVE(NOT SHOWN)		VTR	VENT THROUGH ROOF		TP	TRAP PRIMER, AUTOMATIC			GATE VALVE / SHUT-OFF VALVE /			BALL VALVE			GLOBE VALVE			CHECK VALVE			NON-SLAM CHECK VALVE		ST	STRAINER, IN-LINE W/HOSE-END DRAIN			DRAIN VALVE W/HOSE END		BLV	BALANCING VALVE		FCV	FLOW CONTROL VALVE		MOV	CONTROL VALVE, 2-WAY		3MV	CONTROL VALVE, 3-WAY MIXING		3DV	CONTROL VALVE, 3-WAY DIVERTING		RV	RELIEF VALVE			PRESSURE GAGE W/ ISOLATION VALVE			PRESSURE REDUCING VALVE			PIPE REDUCER			UNION CONNECTION			FLANGE CONNECTION			FLEXIBLE JOINT			PIPE ANCHOR			PIPE ALIGNMENT GUIDE			PIPING SEISMIC FLEXIBLE JOINT			PIPE EXPANSION COMPENSATOR		POC	POINT OF CONNECTION
SYMBOL	ABBREV.	DESCRIPTION																																																																																																																																							
		PIPE UP																																																																																																																																							
		PIPE DOWN																																																																																																																																							
		PIPE TEE UP																																																																																																																																							
		PIPE TEE DOWN																																																																																																																																							
		FIXTURE CONNECTIONS/STOPS																																																																																																																																							
	FD	FLOOR DRAIN																																																																																																																																							
	RD	ROOF DRAIN																																																																																																																																							
	ORD	OVERFLOW ROOF DRAIN																																																																																																																																							
	CO	CLEANOUT, PIPE END PLUG																																																																																																																																							
	WCO	CLEANOUT, WALL, CONCEALED																																																																																																																																							
	FCO	CLEANOUT, FLOOR																																																																																																																																							
	YCO	CLEANOUT, YARD																																																																																																																																							
		W/CONCRETE COLLAR																																																																																																																																							
	WHA	WATER HAMMER ARRESTOR																																																																																																																																							
	AAV	AUTOMATIC AIR VENT																																																																																																																																							
		W/SHUT-OFF VALVE(NOT SHOWN)																																																																																																																																							
	MAV	MANUAL AIR VENT																																																																																																																																							
		W/SHUT-OFF VALVE(NOT SHOWN)																																																																																																																																							
	VTR	VENT THROUGH ROOF																																																																																																																																							
	TP	TRAP PRIMER, AUTOMATIC																																																																																																																																							
		GATE VALVE / SHUT-OFF VALVE /																																																																																																																																							
		BALL VALVE																																																																																																																																							
		GLOBE VALVE																																																																																																																																							
		CHECK VALVE																																																																																																																																							
		NON-SLAM CHECK VALVE																																																																																																																																							
	ST	STRAINER, IN-LINE W/HOSE-END DRAIN																																																																																																																																							
		DRAIN VALVE W/HOSE END																																																																																																																																							
	BLV	BALANCING VALVE																																																																																																																																							
	FCV	FLOW CONTROL VALVE																																																																																																																																							
	MOV	CONTROL VALVE, 2-WAY																																																																																																																																							
	3MV	CONTROL VALVE, 3-WAY MIXING																																																																																																																																							
	3DV	CONTROL VALVE, 3-WAY DIVERTING																																																																																																																																							
	RV	RELIEF VALVE																																																																																																																																							
		PRESSURE GAGE W/ ISOLATION VALVE																																																																																																																																							
		PRESSURE REDUCING VALVE																																																																																																																																							
		PIPE REDUCER																																																																																																																																							
		UNION CONNECTION																																																																																																																																							
		FLANGE CONNECTION																																																																																																																																							
		FLEXIBLE JOINT																																																																																																																																							
		PIPE ANCHOR																																																																																																																																							
		PIPE ALIGNMENT GUIDE																																																																																																																																							
		PIPING SEISMIC FLEXIBLE JOINT																																																																																																																																							
		PIPE EXPANSION COMPENSATOR																																																																																																																																							
	POC	POINT OF CONNECTION																																																																																																																																							
DUCTWORK AND ACCESSORIES		DUCTWORK COMPONENTS AND ASSEMBLIES																																																																																																																																							
E/A EXHAUST AIR O/A OUTSIDE AIR R/A RETURN AIR S/A SUPPLY AIR T/A TRANSFER AIR FD FIRE DAMPER FSD FIRE-SMOKE DAMPER BD BALANCING DAMPER BDD BACK DRAFT DAMPER CBBDD COUNTERBALANCED BACK DRAFT DAMPER SM SHEET METAL		<table><tr><th>SYMBOL</th><th>ABBREV.</th><th>DESCRIPTION</th></tr><tr><td></td><td></td><td>ACOUSTICALLY LINED DUCT</td></tr><tr><td></td><td></td><td>THERMALLY INSULATED DUCT</td></tr><tr><td></td><td></td><td>DUCTWORK DOWN</td></tr><tr><td></td><td></td><td>DUCTWORK UP</td></tr><tr><td></td><td></td><td>TURNING VANES</td></tr><tr><td></td><td></td><td>SUPPLY</td></tr><tr><td></td><td></td><td>RETURN OR EXHAUST</td></tr><tr><td></td><td>WW</td><td>FLEX DUCT</td></tr><tr><td></td><td></td><td>FLEX CONNECTION</td></tr><tr><td></td><td>VD, BD</td><td>VOLUME DAMPER</td></tr><tr><td></td><td>FD / FSD</td><td>FIRE DAMPER / FIRE/SMOKE DAMPER</td></tr><tr><td></td><td>HC</td><td>HEATING COIL</td></tr><tr><td></td><td>T'STAT</td><td>THERMOSTAT (W/ INS. BASE)</td></tr><tr><td></td><td>S/A, O/A</td><td>SUPPLY AIR, OUTSIDE AIR</td></tr><tr><td></td><td>E/A, R/A</td><td>EXHAUST AIR, RETURN / RELIEF AIR</td></tr></table>	SYMBOL	ABBREV.	DESCRIPTION			ACOUSTICALLY LINED DUCT			THERMALLY INSULATED DUCT			DUCTWORK DOWN			DUCTWORK UP			TURNING VANES			SUPPLY			RETURN OR EXHAUST		WW	FLEX DUCT			FLEX CONNECTION		VD, BD	VOLUME DAMPER		FD / FSD	FIRE DAMPER / FIRE/SMOKE DAMPER		HC	HEATING COIL		T'STAT	THERMOSTAT (W/ INS. BASE)		S/A, O/A	SUPPLY AIR, OUTSIDE AIR		E/A, R/A	EXHAUST AIR, RETURN / RELIEF AIR																																																																																							
SYMBOL	ABBREV.	DESCRIPTION																																																																																																																																							
		ACOUSTICALLY LINED DUCT																																																																																																																																							
		THERMALLY INSULATED DUCT																																																																																																																																							
		DUCTWORK DOWN																																																																																																																																							
		DUCTWORK UP																																																																																																																																							
		TURNING VANES																																																																																																																																							
		SUPPLY																																																																																																																																							
		RETURN OR EXHAUST																																																																																																																																							
	WW	FLEX DUCT																																																																																																																																							
		FLEX CONNECTION																																																																																																																																							
	VD, BD	VOLUME DAMPER																																																																																																																																							
	FD / FSD	FIRE DAMPER / FIRE/SMOKE DAMPER																																																																																																																																							
	HC	HEATING COIL																																																																																																																																							
	T'STAT	THERMOSTAT (W/ INS. BASE)																																																																																																																																							
	S/A, O/A	SUPPLY AIR, OUTSIDE AIR																																																																																																																																							
	E/A, R/A	EXHAUST AIR, RETURN / RELIEF AIR																																																																																																																																							

 MECHANICAL SPECIFICATIONS
SUMMARY OF WORK
This project is generally described as comprising of adding heating, ventilation, air conditioning and control systems to the Alaska Bureau of Investigation HVAC Renovation project. It includes the addition of equipment and systems to serve the heating, ventilation, air conditioning and control functions in the facility.
COORDINATION & SCHEDULING
Provide all required administrative and supervisory requirements for the coordination of the work. The mechanical contractor shall coordinate his work with the work of his subcontractors, suppliers, and the Owner.
QUALITY CONTROL
The contractor shall be required to maintain complete control of the constructed project, such that the complete project shall be free of defects and in full conformance of the project documents.
CONTRACTOR RESPONSIBILITY
The contractor shall utilize procedures that assure quality construction throughout, with use of the best industry standards for the specific process used. Remove and replace any work found defective or not complying with requirements of the contract documents, at no additional cost to the Owner.
INSPECTION SERVICES
The Owner has full authority to see that the work is performed in strict accordance with the contract documents.
FINAL CHECKOUT & PROJECT CLOSEOUT
The Owner will require a complete final inspection of all parts of the work. Work shall include but not be limited to the following: plumbing, piping, equipment, ductwork, wiring, and finish work.
CLEAN-UP
Remove all waste materials and rubbish from the site, thoroughly clean all surfaces of work, and leave ready for occupancy by the Owner. The Owner will verify the completion and/or correction of the items above.
PERMITS, INSPECTIONS & FEES
Obtain permits and inspections and pay fees required by the local authorities. During its progress, the work shall be inspected by the Owner. Present Inspector's certificates of compliance to the Owner.
SUBMITTED DATA
Submit technical data and required information on all equipment and materials.
QUALITY
Contractor shall comply with the applicable local and national codes, ordinances and regulations affecting materials and methods used; and recommended practices as set down by the International Building and Mechanical Codes, Uniform Plumbing Codes, and the National Electric Code.
WORKMANSHIP
All work to be done by workmen skilled in and regularly employed at that trade.
CUTTING & PATCHING
Cutting and patching shall be kept to a minimum. All patching to match existing finish work. Do not cut structural members.
MEASUREMENTS
Contractor shall field verify prior to bidding. Verify space availability prior to fabrication and installation of any work.
BASIC MATERIALS & METHODS
1. Ductwork: All ductwork shall be galvanized steel, fabricated and installed in accordance with SMACNA HVAC Duct Construction Standards, 2" W.G. Pressure Class for low pressure systems and 4" W.G. for medium pressure systems. Duct Sealer shall be UL Labeled duct sealer as manufactured by 3M Company or equal. Duct Fittings shall be fabricated in accordance with SMACNA Standards. Duct runs shall coordinate with walls, suspended ceilings, light fixtures, roof trusses and similar finished work. Duct opening shall be covered during construction to prevent entrance of dust and debris. 2. Flexible Ducts, Insulated: Factory-fabricated, insulated, round duct, with an outer jacket enclosing 1-inch-thick, glass-fiber insulation around a continuous inner liner. Rated for maximum pressures of 10-inches wg positive and 1-inch wg negative. Reinforcement: Steel spring coated wire helix supporting the inner liner. Outer Jacket: Metalized fiberglass crosshatched jacketing. Inner Liner: Chlorinated Polyethylene, acoustically rated. 3. Coordinate all new work with the conduits, lights, hangers, structural members and other trades. 4. See schedules for equipment requirements and specifications. 5. Install all equipment according to manufacturer's recommendations. Install only products specifically designed and approved for the type of operation or service.
BALANCING & STARTUP
1. An independent air balancing company will perform the air balancing of the complete heating and HVAC systems per the SMACNA Balancing and Adjustment Manual. Adjust air quantities to within 5% of the design values. 2. Complete and submit the final testing and balancing report before the project is complete. 3. Field Services: The manufacturer's representative shall provide the services of a local factory authorized service technician to supervise all phases of the startup for the variable frequency drives.
CONTROLS
1. Provide a complete automatic temperature control system to provide the equipment control sequences noted below. 2. All components used will be only commercial grade. Provide all equipment for a complete and operational system. 3. Control Wiring: Provide electric wiring and wiring connections required for the installation of the control system. Comply with the requirements of the National Electric Code. 4. The control contractor shall work with and coordinate with the engineer on the components, sequences of operation and system capabilities.
SEQUENCE OF OPERATION
TBD




JERNSTROM ENGINEERING
CONSULTING MECHANICAL ENGINEERS
6927 Old Seward Hwy, Suite 202, Anchorage, Alaska 99518
Phone: (907) 522-1042 Fax: (907) 522-1052
E-mail: rjernstrom@jernstromengineering.com

ALASKA BUREAU OF INVESTIGATION BUILDING HVAC RENOVATION PROJECT 5500 E TUDOR ROAD ANCHORAGE, ALASKA 99507	SPECIFICATIONS
--	-----------------------

Revisions	
Date	4/30/15
Drawn	JJ
Check	RJ
Project	2015-19

Sheet No.

M1.1

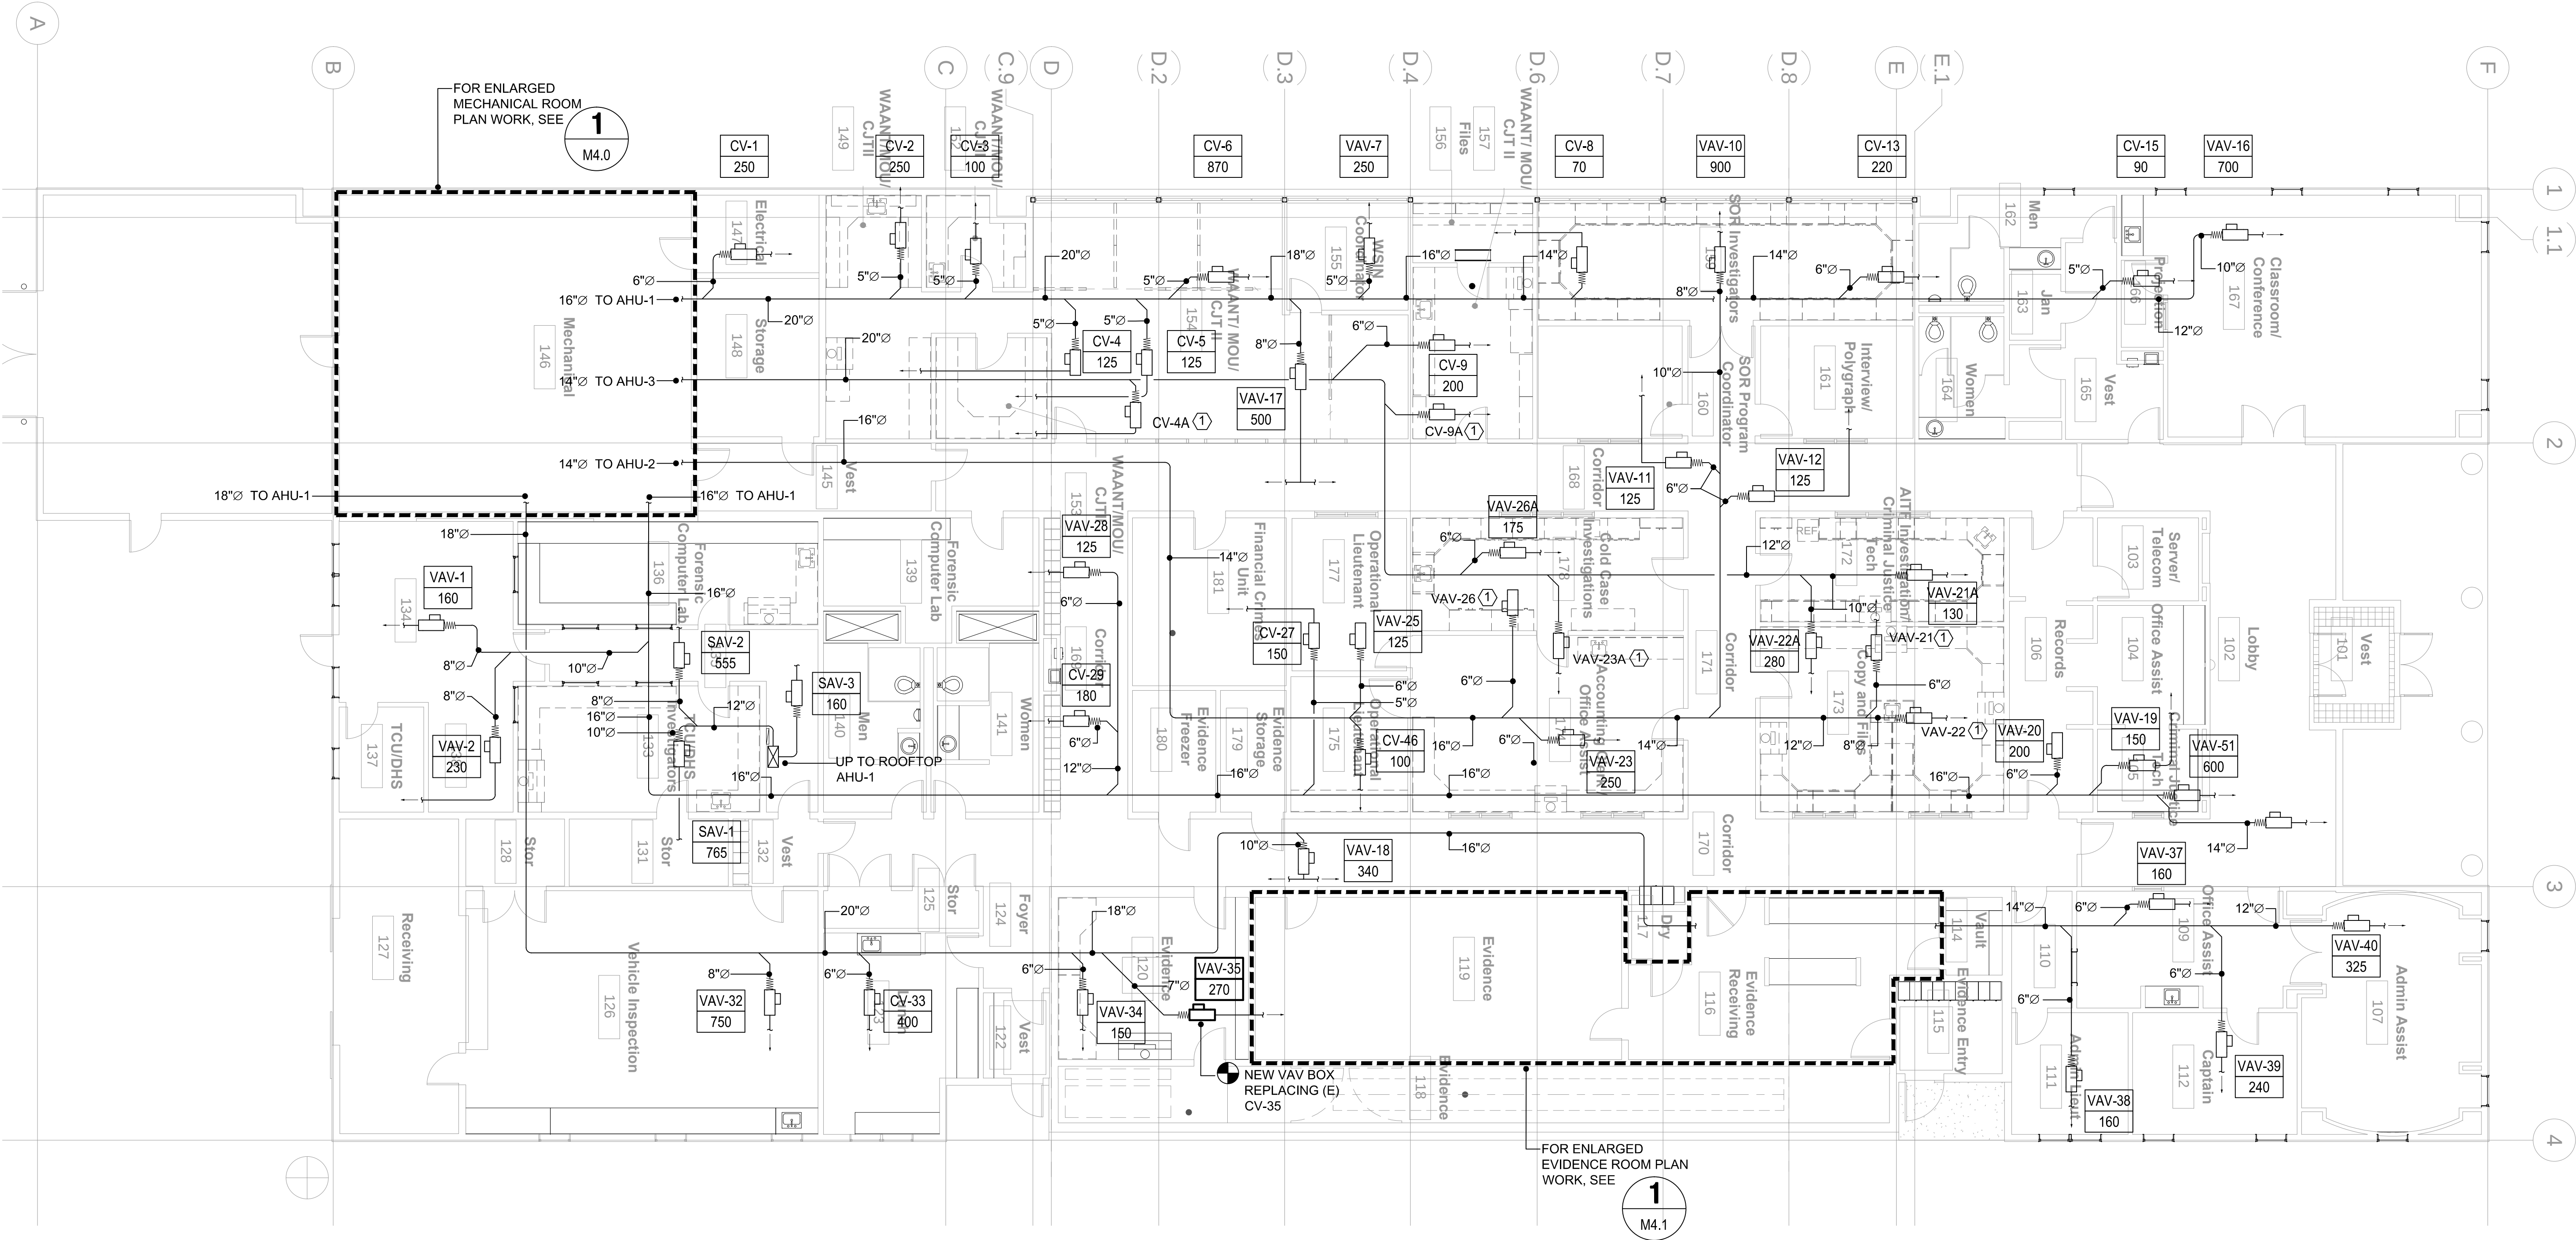


1 FLOOR PLAN - SUPPLY AIR BALANCE
M2.0 SCALE: 1/8"=1'-0"

NOTES:

(1) NOT USED.

 2. TERMINAL UNIT KEY PLAN



3. PROVIDE DDC VAV CONTROL RETRO FIT KITS FOR ALL CONSTANT VOLUME (CV) BOXES. CONTROLS TO BE INSTALLED AND PROGRAMMED AS PART OF A FUTURE CONTROLS PROJECT.



JERNSTROM ENGINEERING
CONSULTING MECHANICAL ENGINEERS
6927 Old Seward Hwy, Suite 202, Anchorage, Alaska 99518
Phone: (907) 522-1042 Fax: (907) 522-1052
Email: jernstrom@jernstromengineering.com

ALASKA BUREAU OF INVESTIGATION BUILDING
HVAC RENOVATION PROJECT

5500 E TUDOR ROAD
ANCHORAGE, ALASKA 99507


FLOOR PLAN - SUPPLY AIR BALANCE

Revisions

Date	4/30/15
Drawn	JJ
Check	RJ
Project	2015-19

Sheet No.

 M2.0



ALASKA BUREAU OF INVESTIGATION BUILDING
HVAC RENOVATION PROJECT
5500 E TUDOR ROAD
ANCHORAGE, ALASKA 99507
FLOOR PLAN VENTILATION - EXHAUST AIR

M2.1





JERNSTROM ENGINEERING
CONSULTING MECHANICAL ENGINEERS
6927 Old Seward Hwy, Suite 202, Anchorage, Alaska 99518
Phone: (907) 522-1042 Fax: (907) 522-1052
Email: jernstrom@jernstromengineering.com


ALASKA BUREAU OF INVESTIGATION BUILDING
HVAC RENOVATION PROJECT

5500 E TUDOR ROAD
ANCHORAGE, ALASKA 99507



FLOOR PLAN - PLAN THERMAL ZONE BOUNDARIES

Revisions	
Date	4/30/15
Drawn	JJ
Check	RJ
Project	2015-19

Sheet No.
M3.0

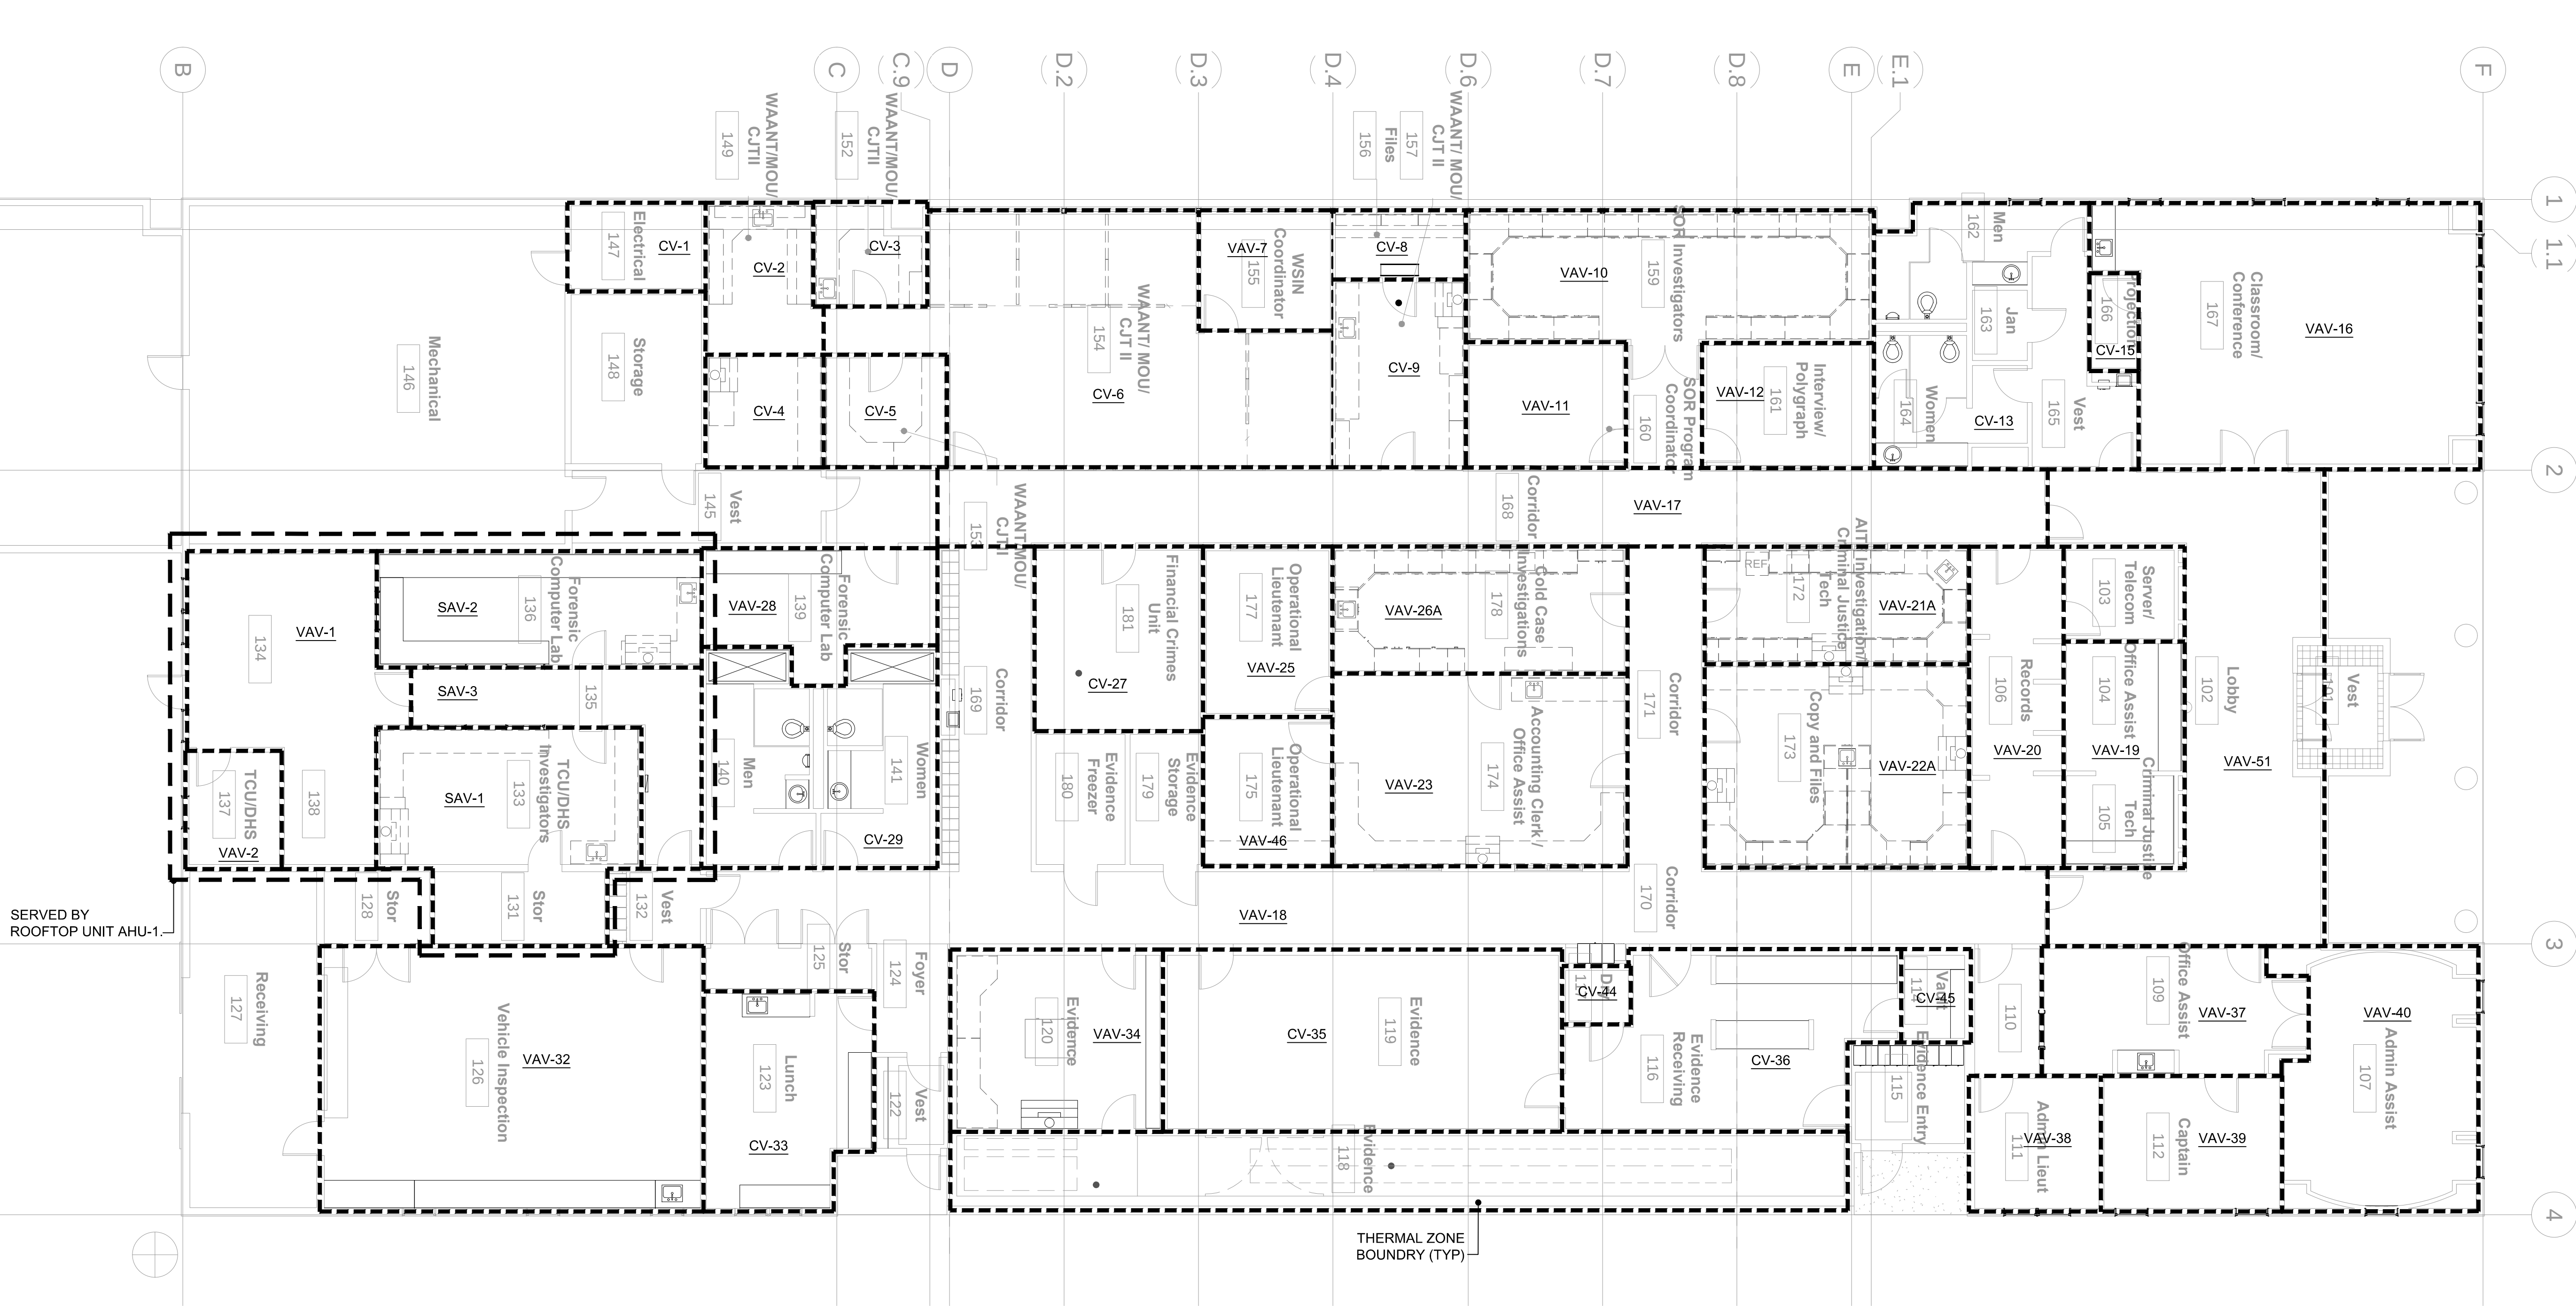

1 FLOOR PLAN - THERMAL ZONE BOUNDARIES
M3.0 SCALE: 1/8"=1'-0"

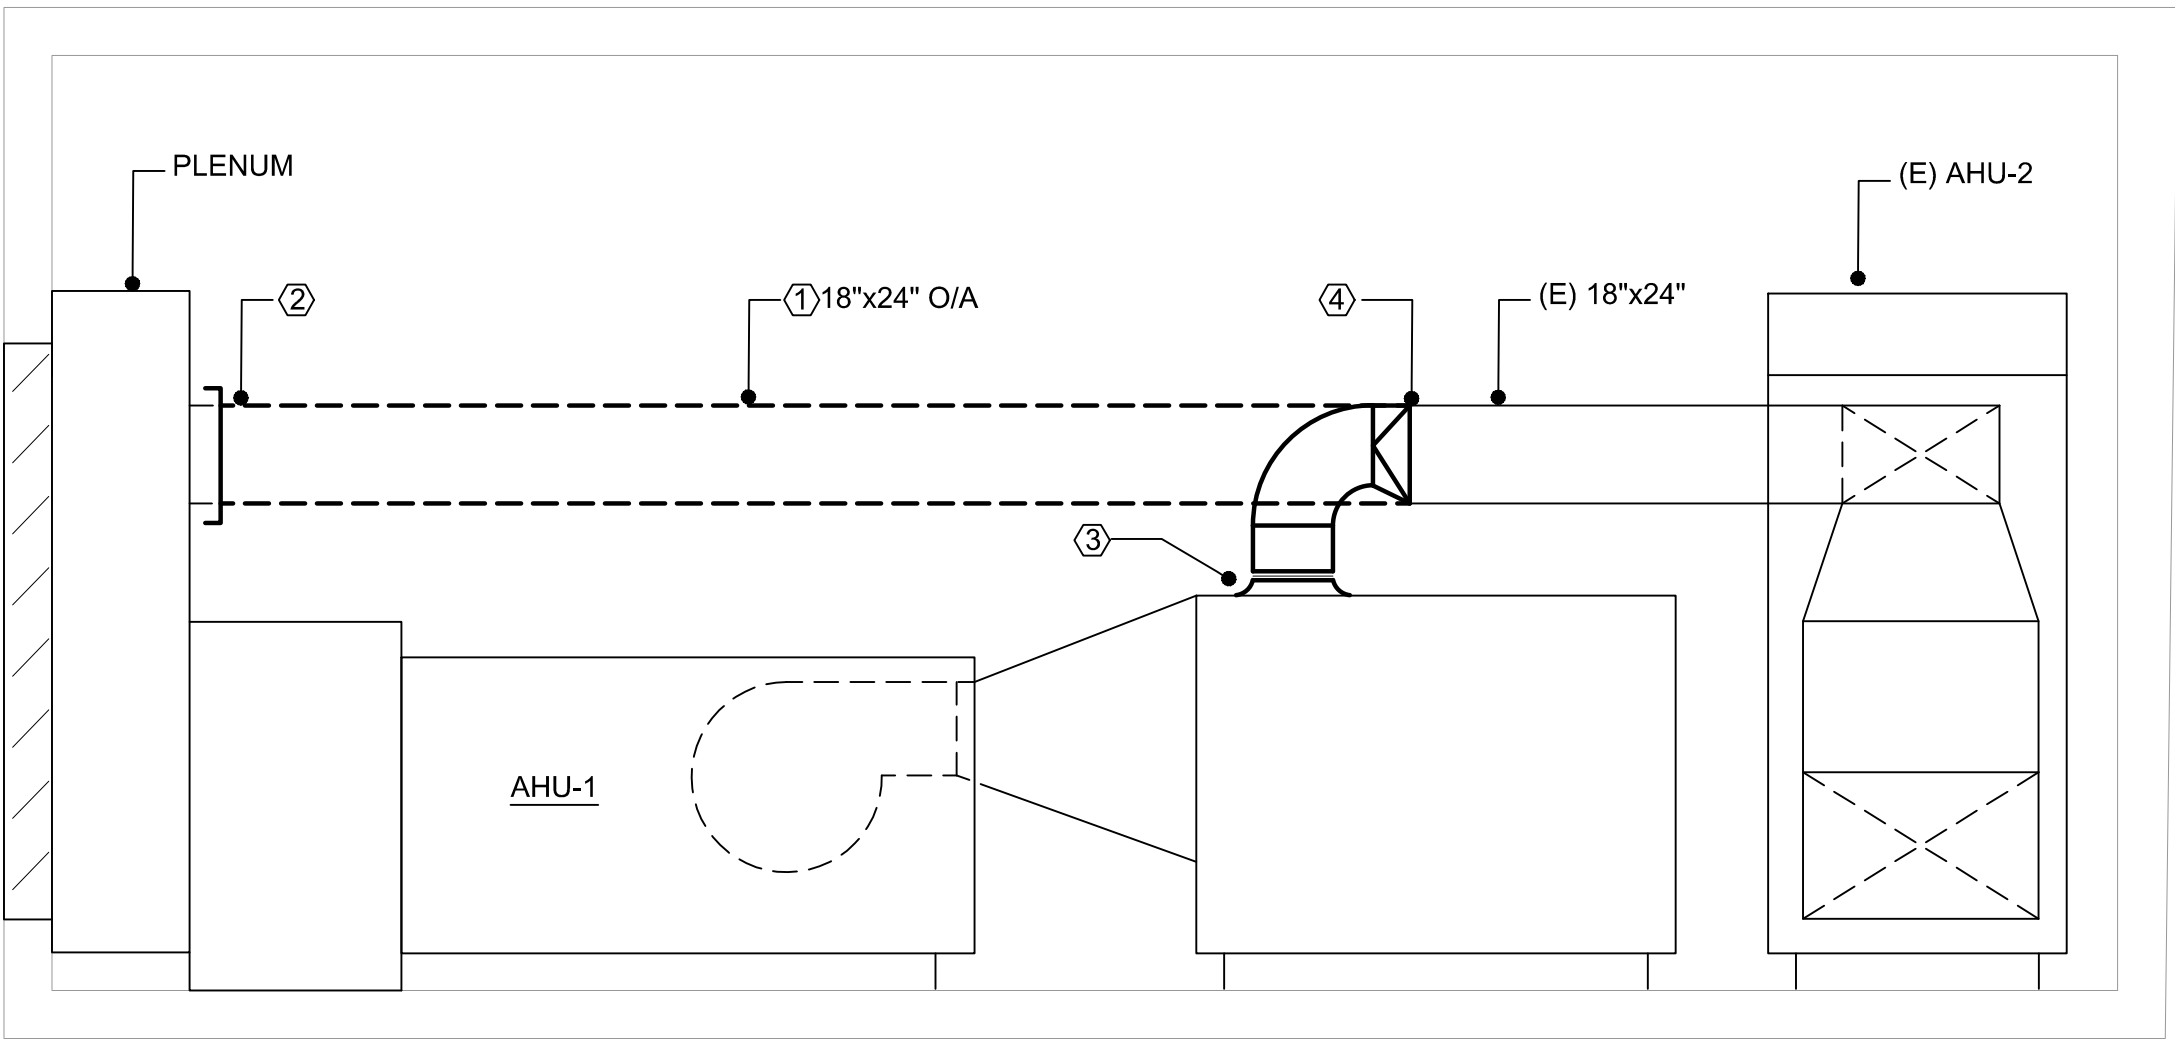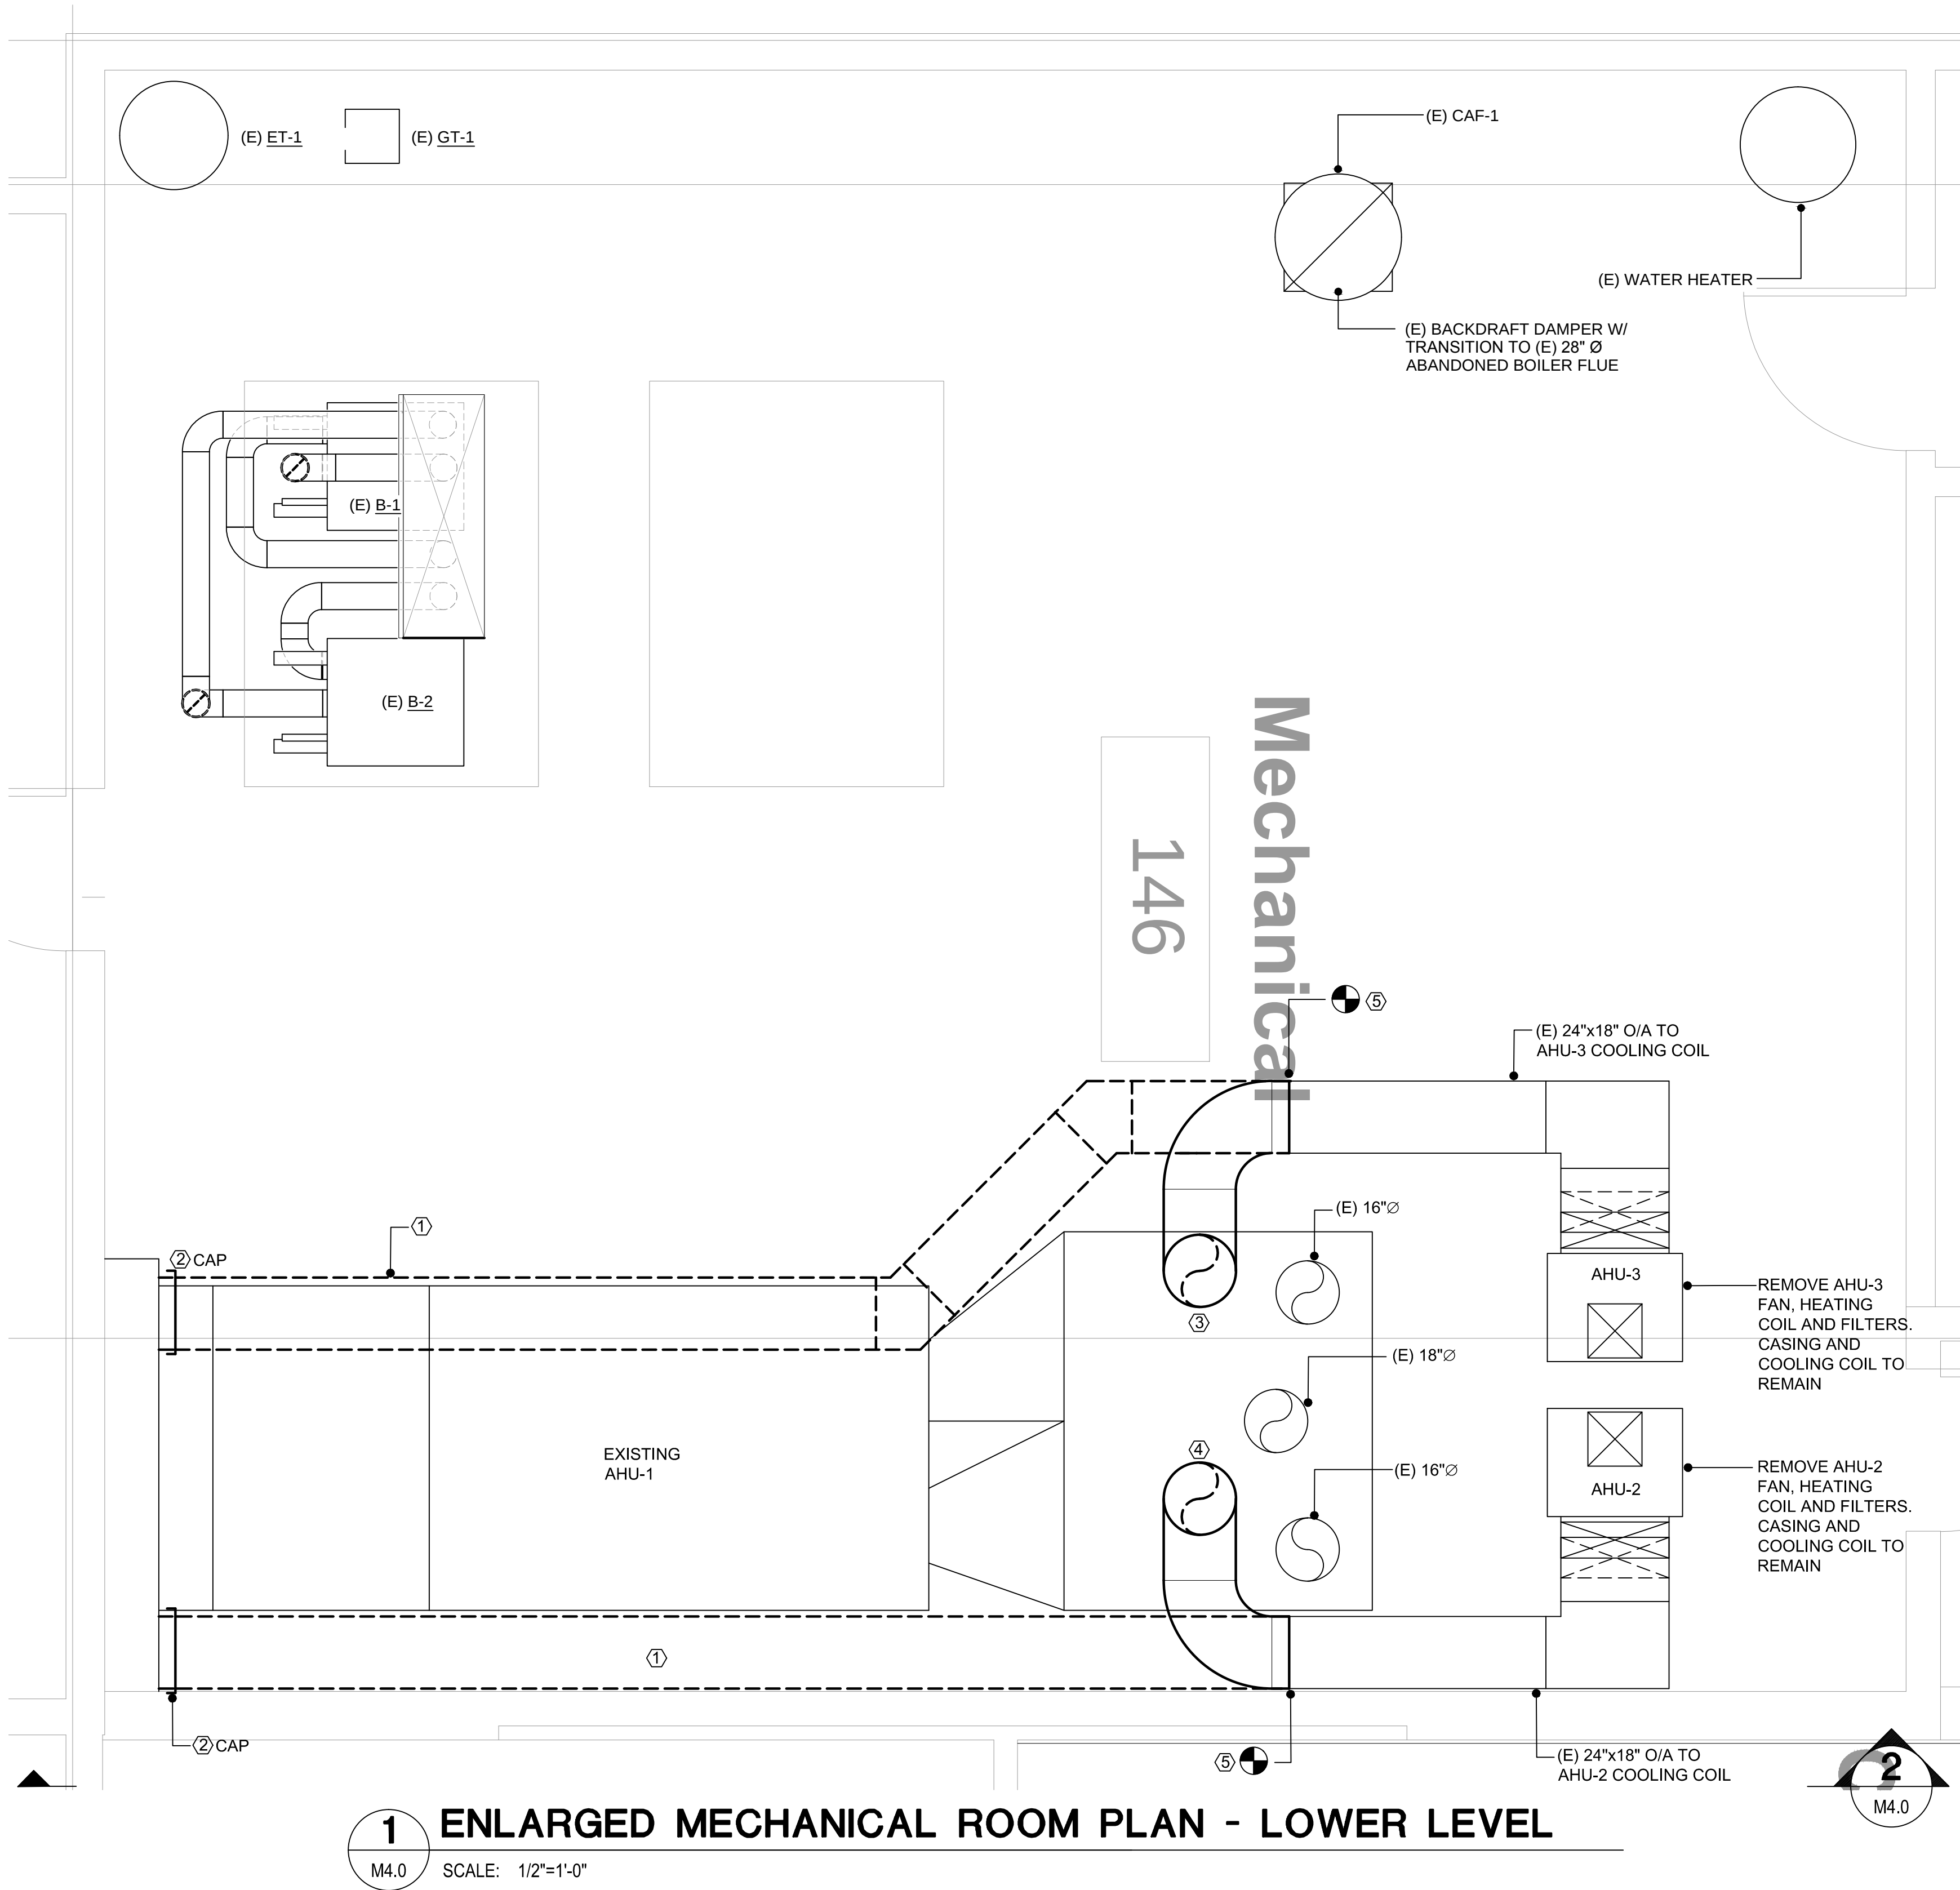

2 SECTION AT AHU-1
M4.0 SCALE: NTS

NOTES:

- ① DEMO EXIST. 24"x18" O/A DUCT AS SHOWN.
- ② CAP AND INSULATE O/A DUCT CONNECTION TO AHU-2 AND AHU-3.
- ③ 16"Ø BELLMOUTH AND FLEX CONN. TO AHU-1.
- ④ CONNECT TO EXIST. 24"x18" O/A DUCT AS SHOWN.



JERNSTROM ENGINEERING
CONSULTING MECHANICAL ENGINEERS
6927 Old Seward Hwy, Suite 202, Anchorage, Alaska 99518
Phone: (907) 522-1042 Fax: (907) 522-1052
Email: rjernstrom@jernstromengineering.com

**ALASKA BUREAU OF INVESTIGATION BUILDING
HVAC RENOVATION PROJECT**

5500 E TUDOR ROAD
ANCHORAGE, ALASKA 99507


ENLARGED MECHANICAL ROOM PLAN - LOWER LEVEL

Revisions


Date	4/30/15
Drawn	JJ
Check	RJ
Project	2015-19

Sheet No.

M4.0

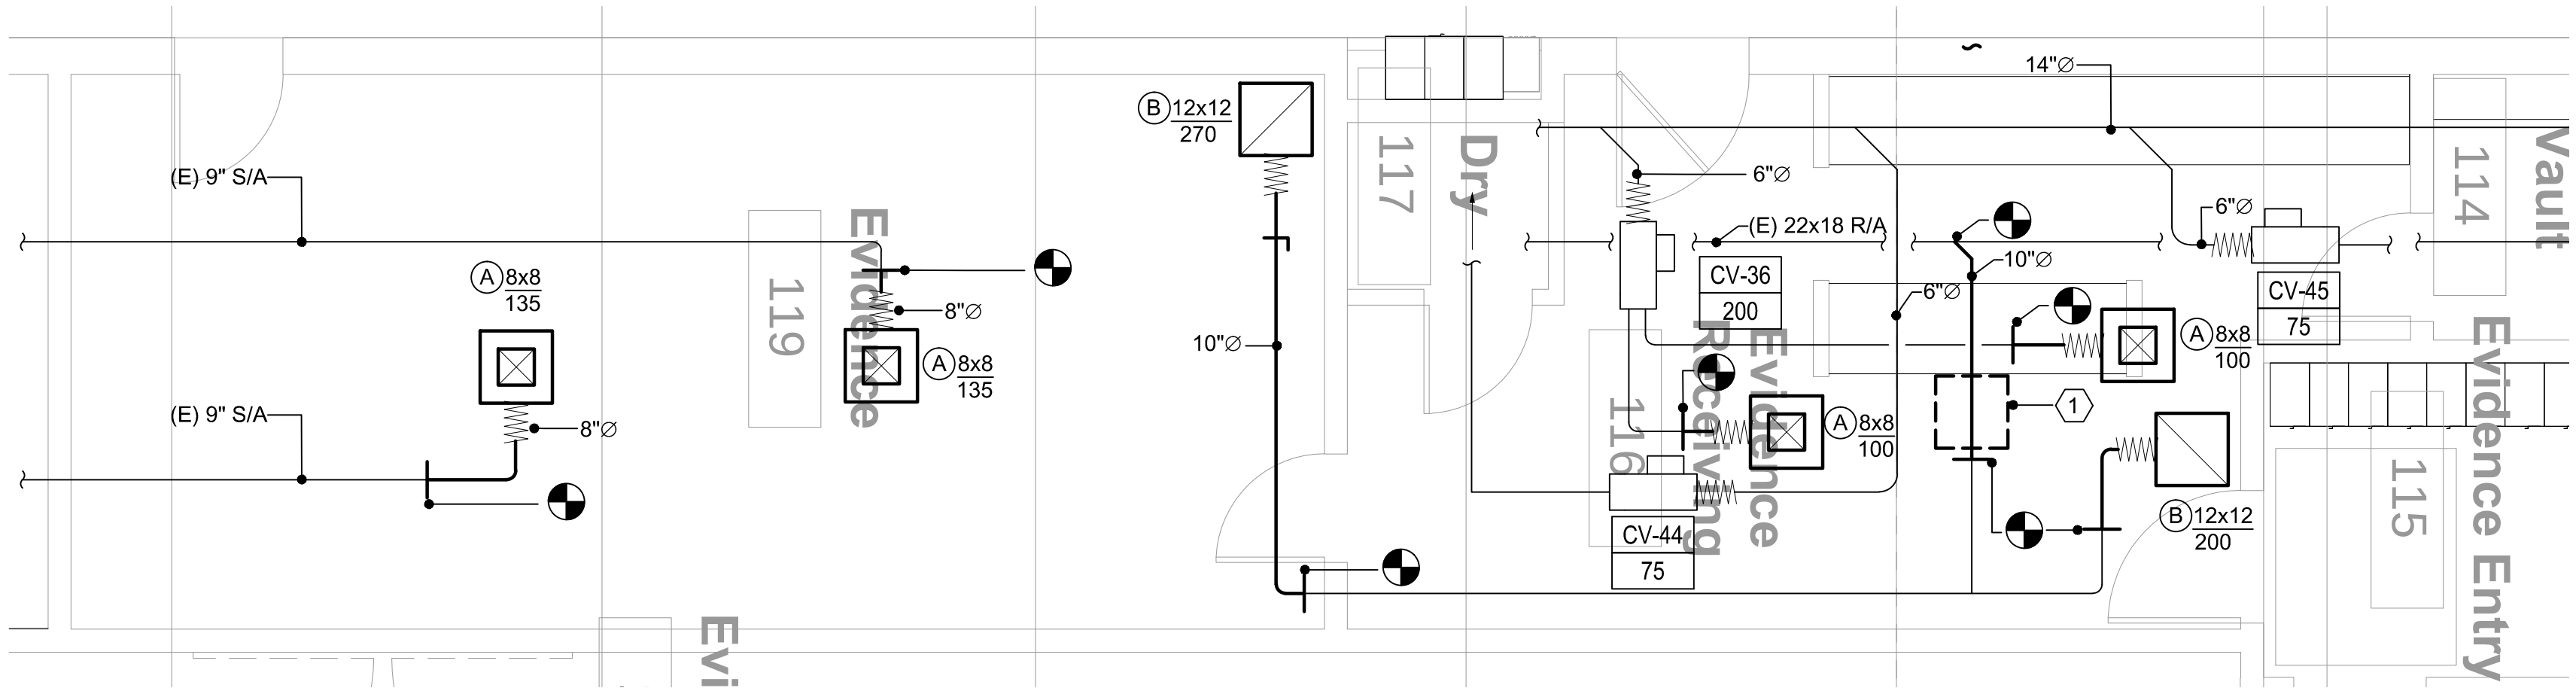

1 ENLARGED EVIDENCE ROOM PLAN
M4.1 SCALE: 1/4"=1'-0"

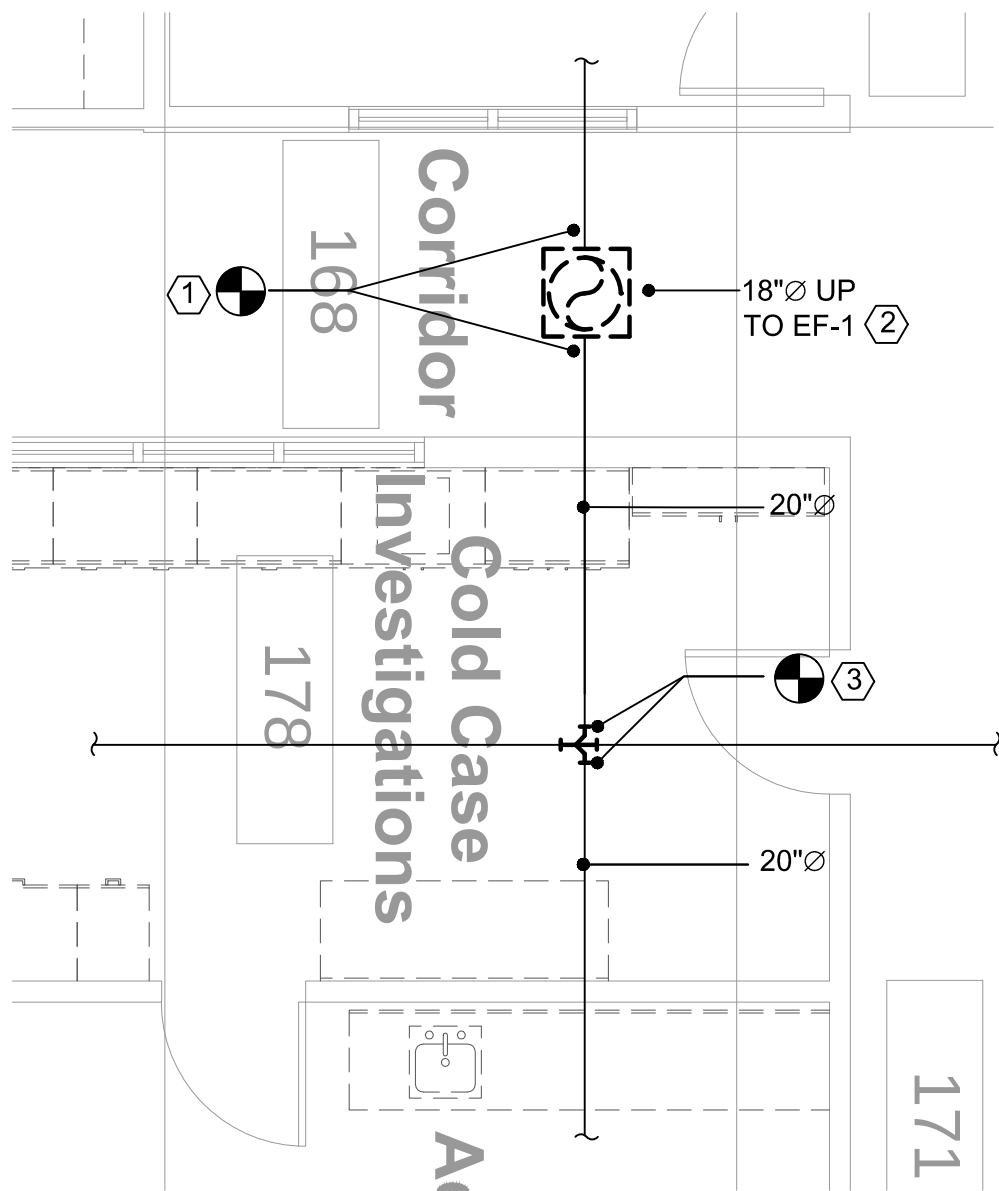

NOTES:
① EF-14 TO BE REMOVED AND DUCTWORK THRU ROOF CAPPED. PREVIOUS EXHAUST DUCT FROM ROOMS TO BE RECONNECTED TO RETURN DUCT SYSTEM.

NOTES:
① PROVIDE 18"Ø TO 20"Ø DUCT TRANSITION.
② REMOVE EXIST EF-1 AND 18"Ø DUCT DROP.
③ CONNECT TO (E) 16"x16" WITH 45-90 DEGREE BOOT TEE FITTING.

2 ENLARGED RETURN AIR PLAN
M4.1 SCALE: 1/4"=1'-0"



JERNSTROM ENGINEERING
CONSULTING MECHANICAL ENGINEERS
6927 Old Seward Hwy, Suite 202, Anchorage, Alaska 99518
Phone: (907) 522-1042 Fax: (907) 522-1052
E-mail: rjernstrom@jernstromengineering.com

ALASKA BUREAU OF INVESTIGATION BUILDING
HVAC RENOVATION PROJECT

5500 E TUDOR ROAD
ANCHORAGE, ALASKA 99507

ENLARGED PLANS

Revisions

Date 4/30/15
Drawn JJ
Check RJ
Project 2015-19

Sheet No.

M4.1