


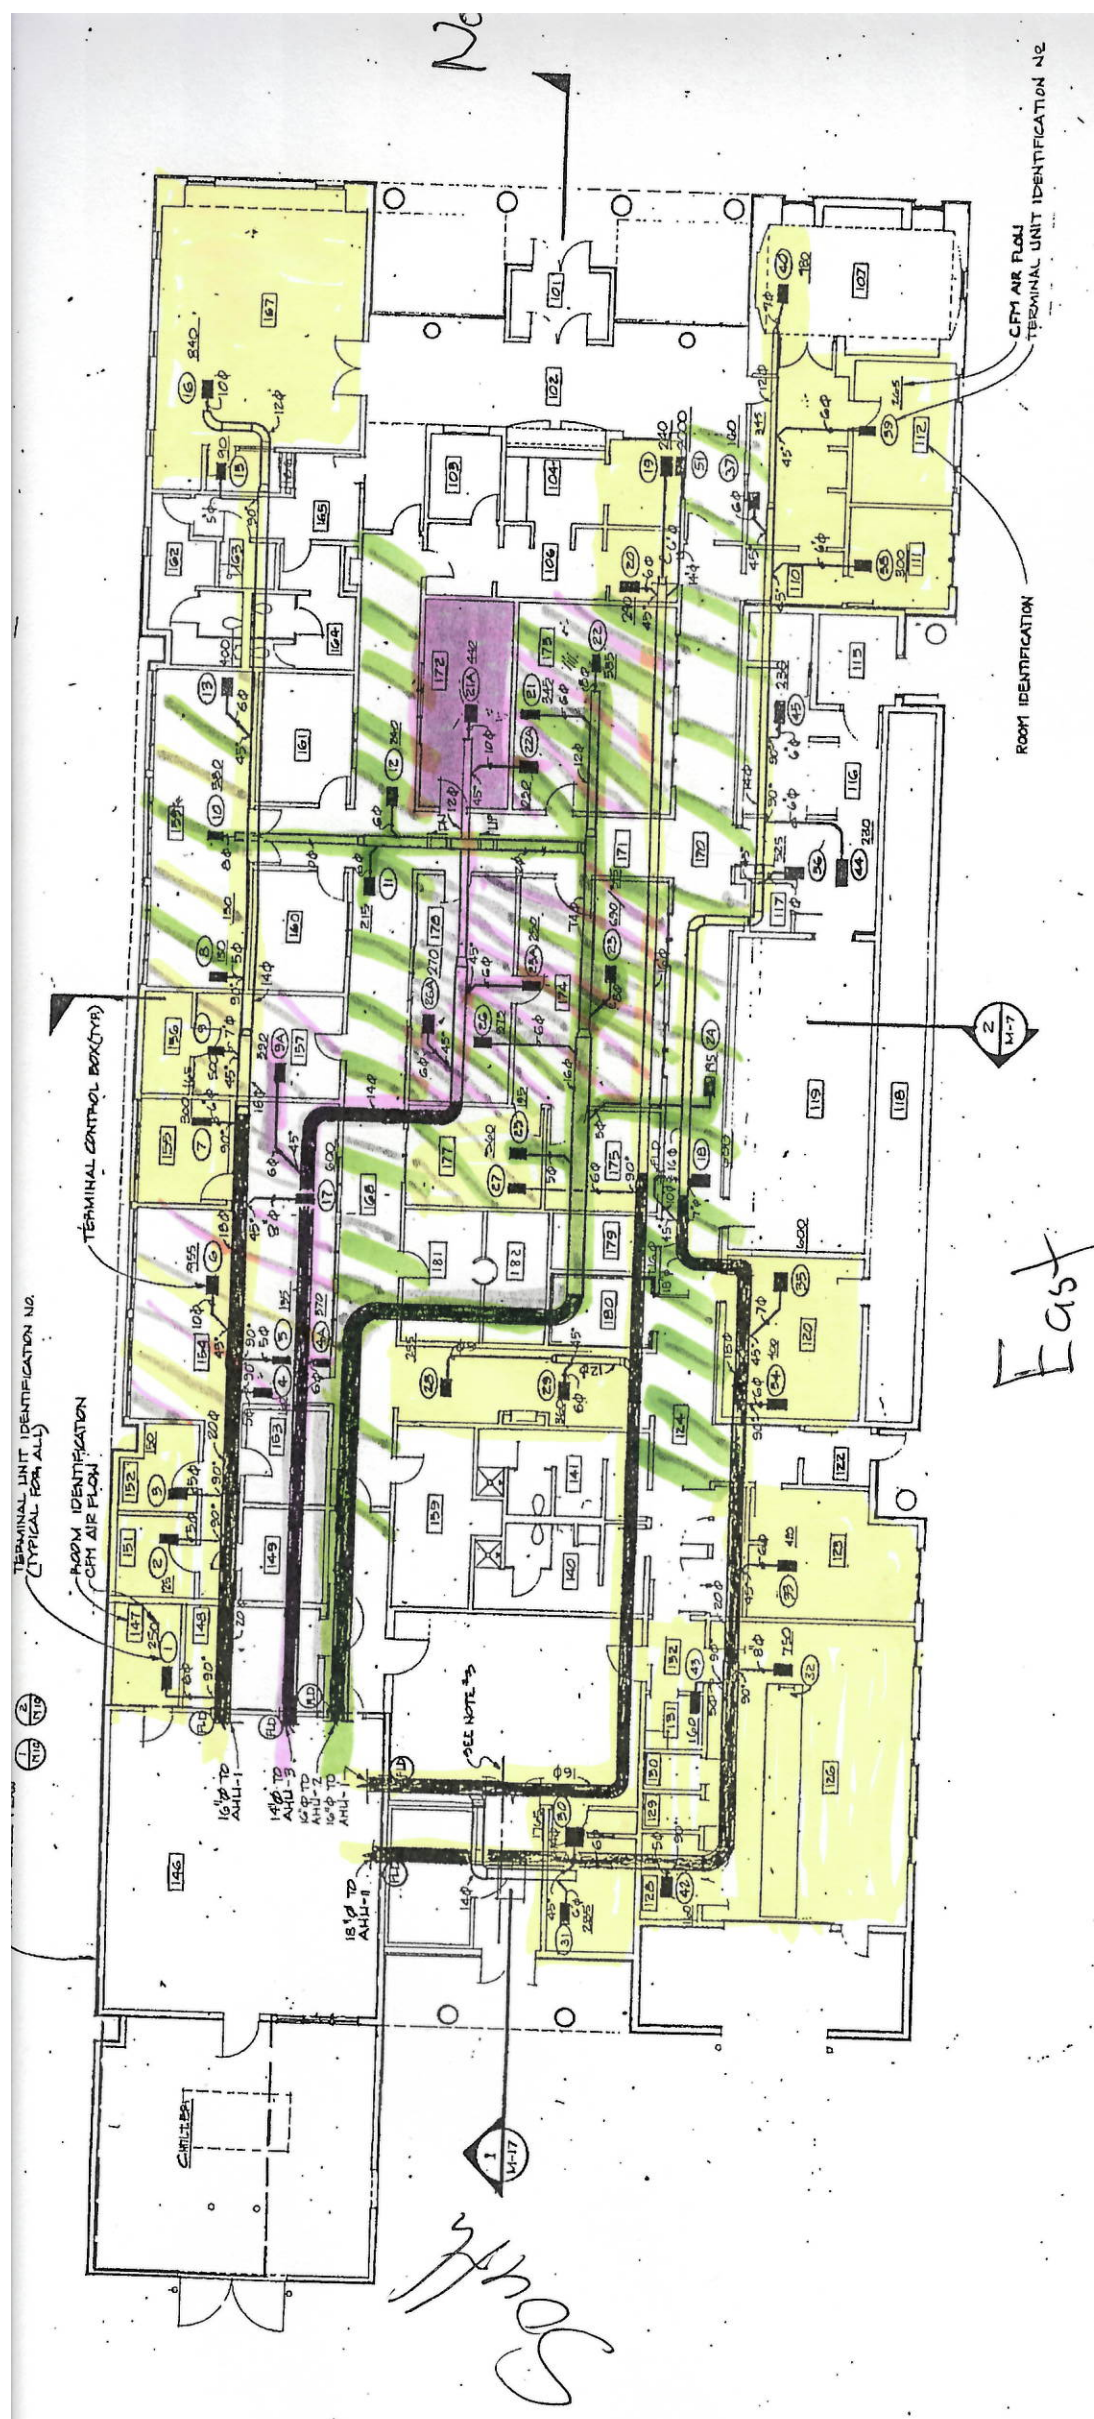

AHU-1
AHU-2
AHU-3

FLOOR PLAN - SUPPLY DUCTWORK MAINS
1/8" = 1'-0"

ABI HVAC UPGRADES
RFQ 12-133443F
5500 TUDOR ROAD

SHEET NOTES

- SEE 1/4" FOR LARGE SCALE AIR DISTRIBUTION NORTH HALF
 - SEE 1/8" FOR LARGE SCALE AIR DISTRIBUTION SOUTH HALF
- NOTE: DUCT SIZES ARE NET FREE AREA IS ACTUAL DUCT SIZE IS LARGER WHEN LINED WITH SOUND ATTENUATION LINER.
DUCT LINED WITH SOUND ATTENUATION LINER
3. COORDINATE DUCTS LOCATION WITH MINORAIL HANGER RODS AT THIS LOCATION